
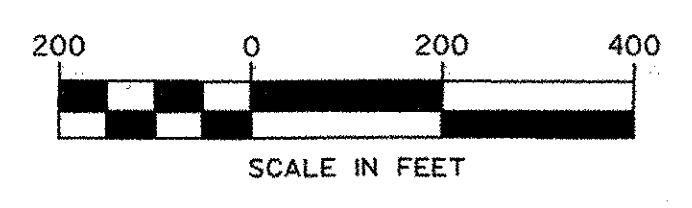


VT STATE PLANE GRID

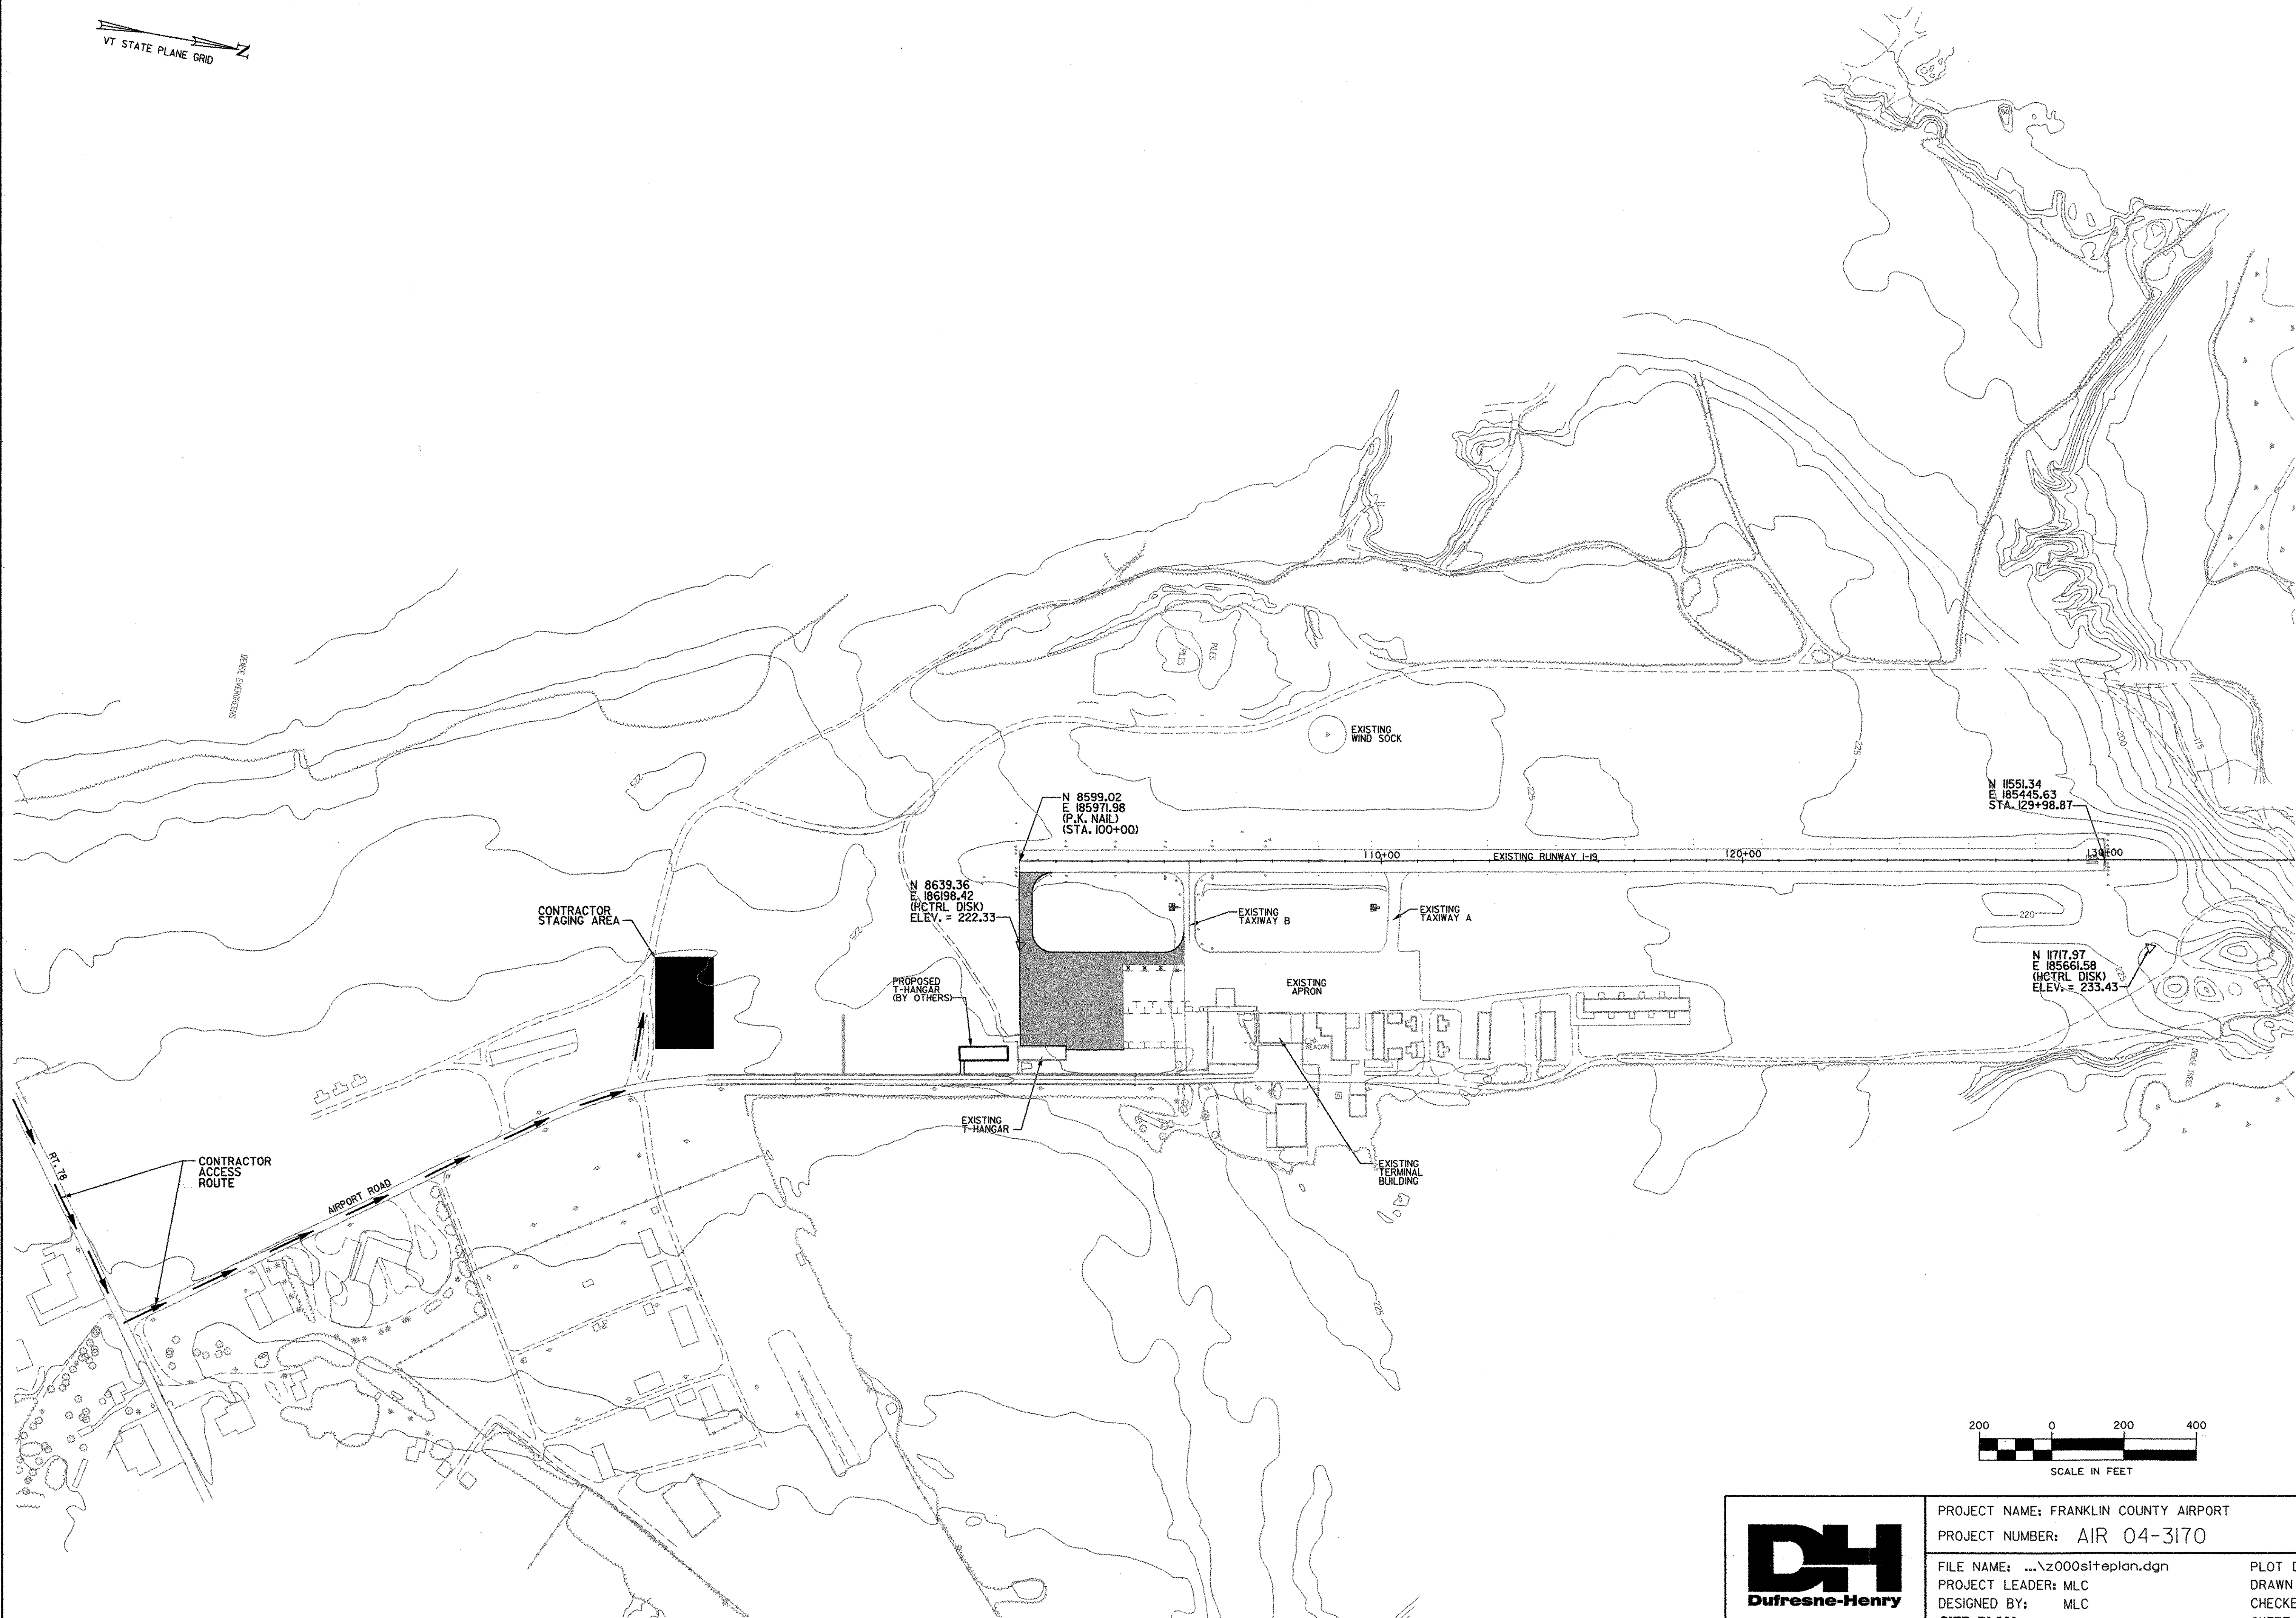

PROJECT NAME: FRANKLIN COUNTY AIRPORT
 PROJECT NUMBER: AIR 04-3170
 FILE NAME: ...z000siteplan.dgn
 PROJECT LEADER: MLC
 DESIGNED BY: MLC
SITE PLAN

PLOT DATE: 04/06/2004
 DRAWN BY: JDO
 CHECKED BY: DPD
 SHEET 5 OF 17