




1 BASE MOUNTED LIGHT (ITEM 864.11)
NOT TO SCALE

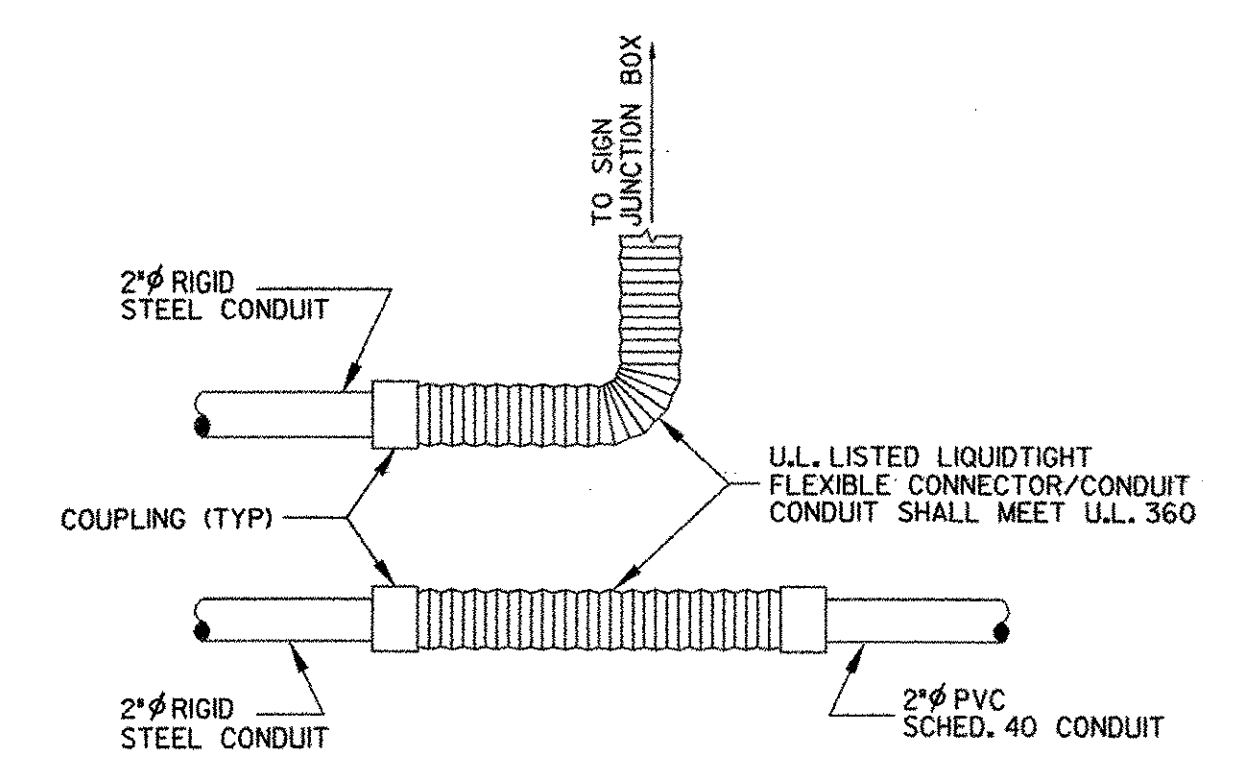

2 FLEXIBLE CONNECTOR / CONDUIT
NOT TO SCALE

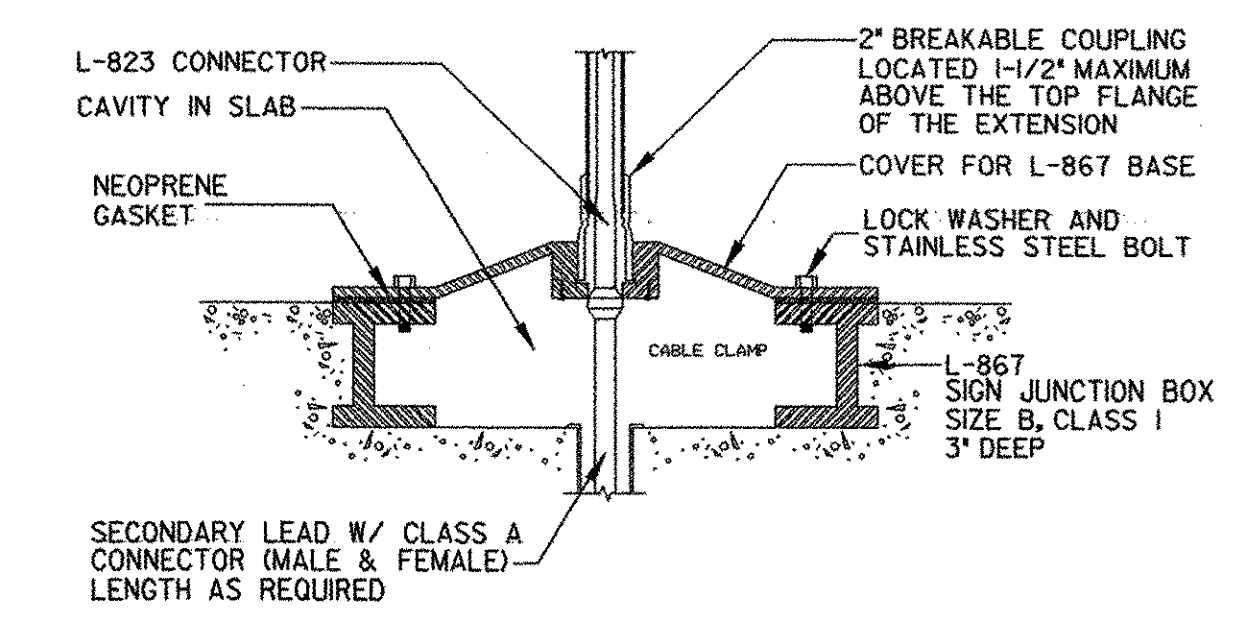

3 L-867 SIGN JUNCTION BOX
NOT TO SCALE

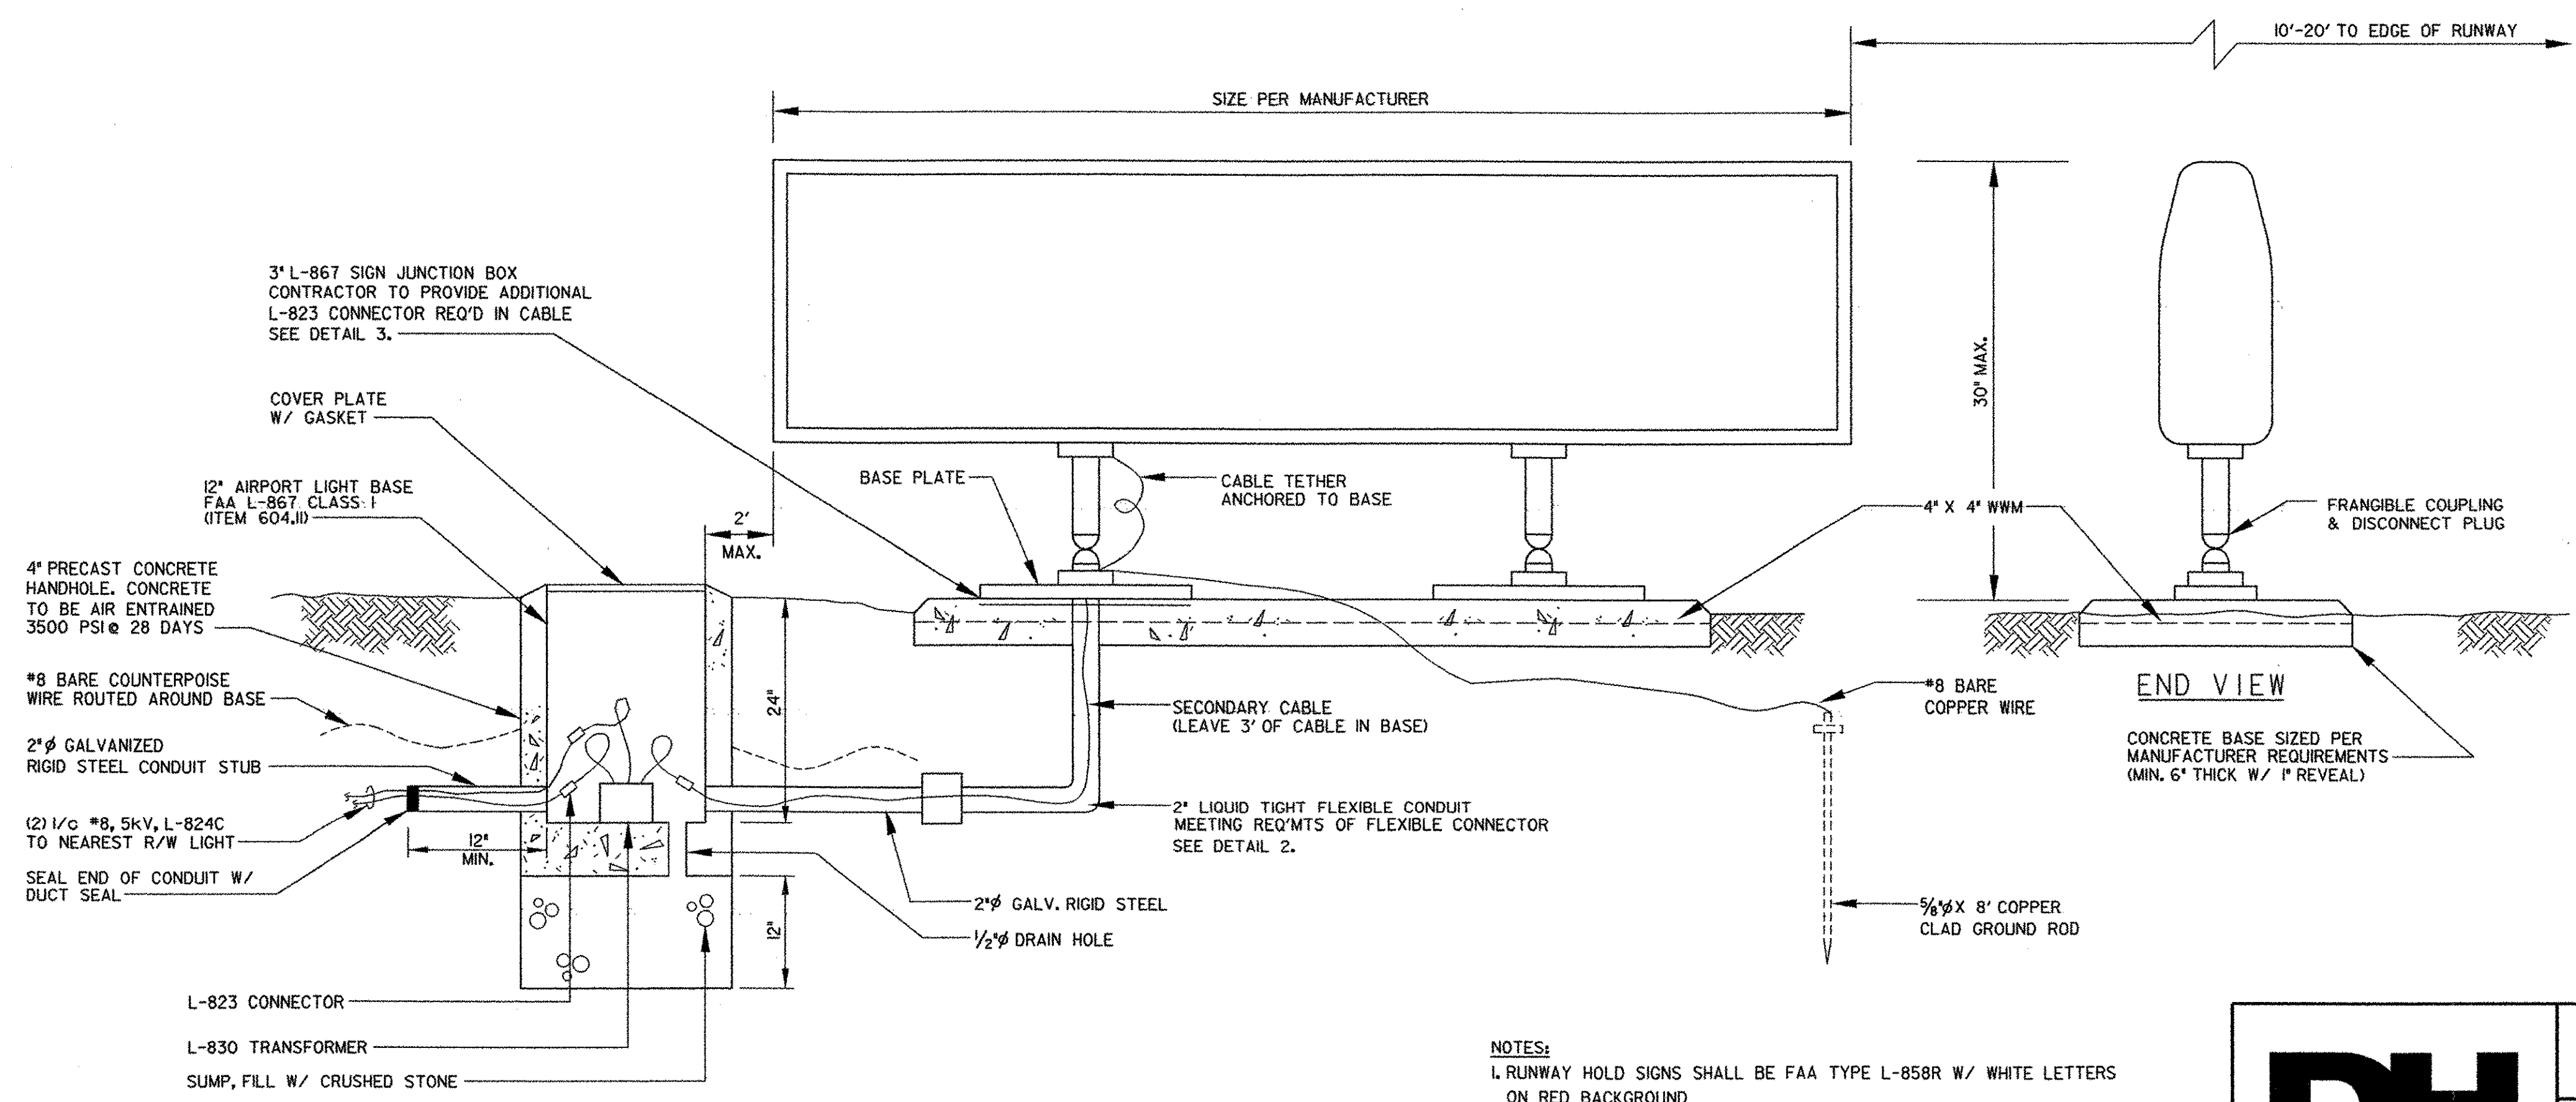

4 TAXIWAY GUIDANCE SIGN (ITEM 864.14)
NOT TO SCALE

NOTES:
1. RUNWAY HOLD SIGNS SHALL BE FAA TYPE L-858R W/ WHITE LETTERS ON RED BACKGROUND
SIZE 1; CLASS 2; STYLE 2; LOW VA; HIGH POWER FACTOR
2. SEE SHEET 12 FOR LOCATIONS.

	PROJECT NAME: FRANKLIN COUNTY AIRPORT
	PROJECT NUMBER: AIR 04-3170
	FILE NAME: ...z000frm.dgn
	DESIGNED BY: MLC
	ELECTRICAL DETAILS
	PLOT DATE: 04/06/2004
	DRAWN BY: JDO
	CHECKED BY: DPD
	SHEET 13 OF 17

L:\ES\31306\frm.dgn 04/06/2004 01:41:35 PM