



- LEGEND**
- EXISTING EDGE OF PAVEMENT.
  - TREE LINE
  - EXISTING BUILDING
  - AREA OF PAVEMENT REMOVAL AND RECONSTRUCTION
  - AREA OF NEW APRON & TAXILANE
  - CONTRACTOR STAGING AREA
  - LIMITS OF PROPOSED TIEDOWN APRON
  - x-x- EXISTING FENCE
  - UE- EXISTING UNDERGROUND ELECTRIC LINE
  - ⊙ ROTATING BEACON
  - ⊙ EXISTING TIEDOWNS
  - ⊙ EXISTING TAXIWAY LIGHT
  - ⊙ EXISTING REFLECTOR
  - ⊙ EXISTING POWER POLE
  - EXISTING GUY WIRE
  - ⊙ EXISTING CATCH BASIN
  - ⊙ EXISTING STORM DRAIN MANHOLE
  - PUE- 2-WAY X 4" DIA. U.G. ELECTRICAL DUCT
  - STORM DRAIN PIPE
  - ⊙ TAXIWAY RETROFLECTIVE MARKER

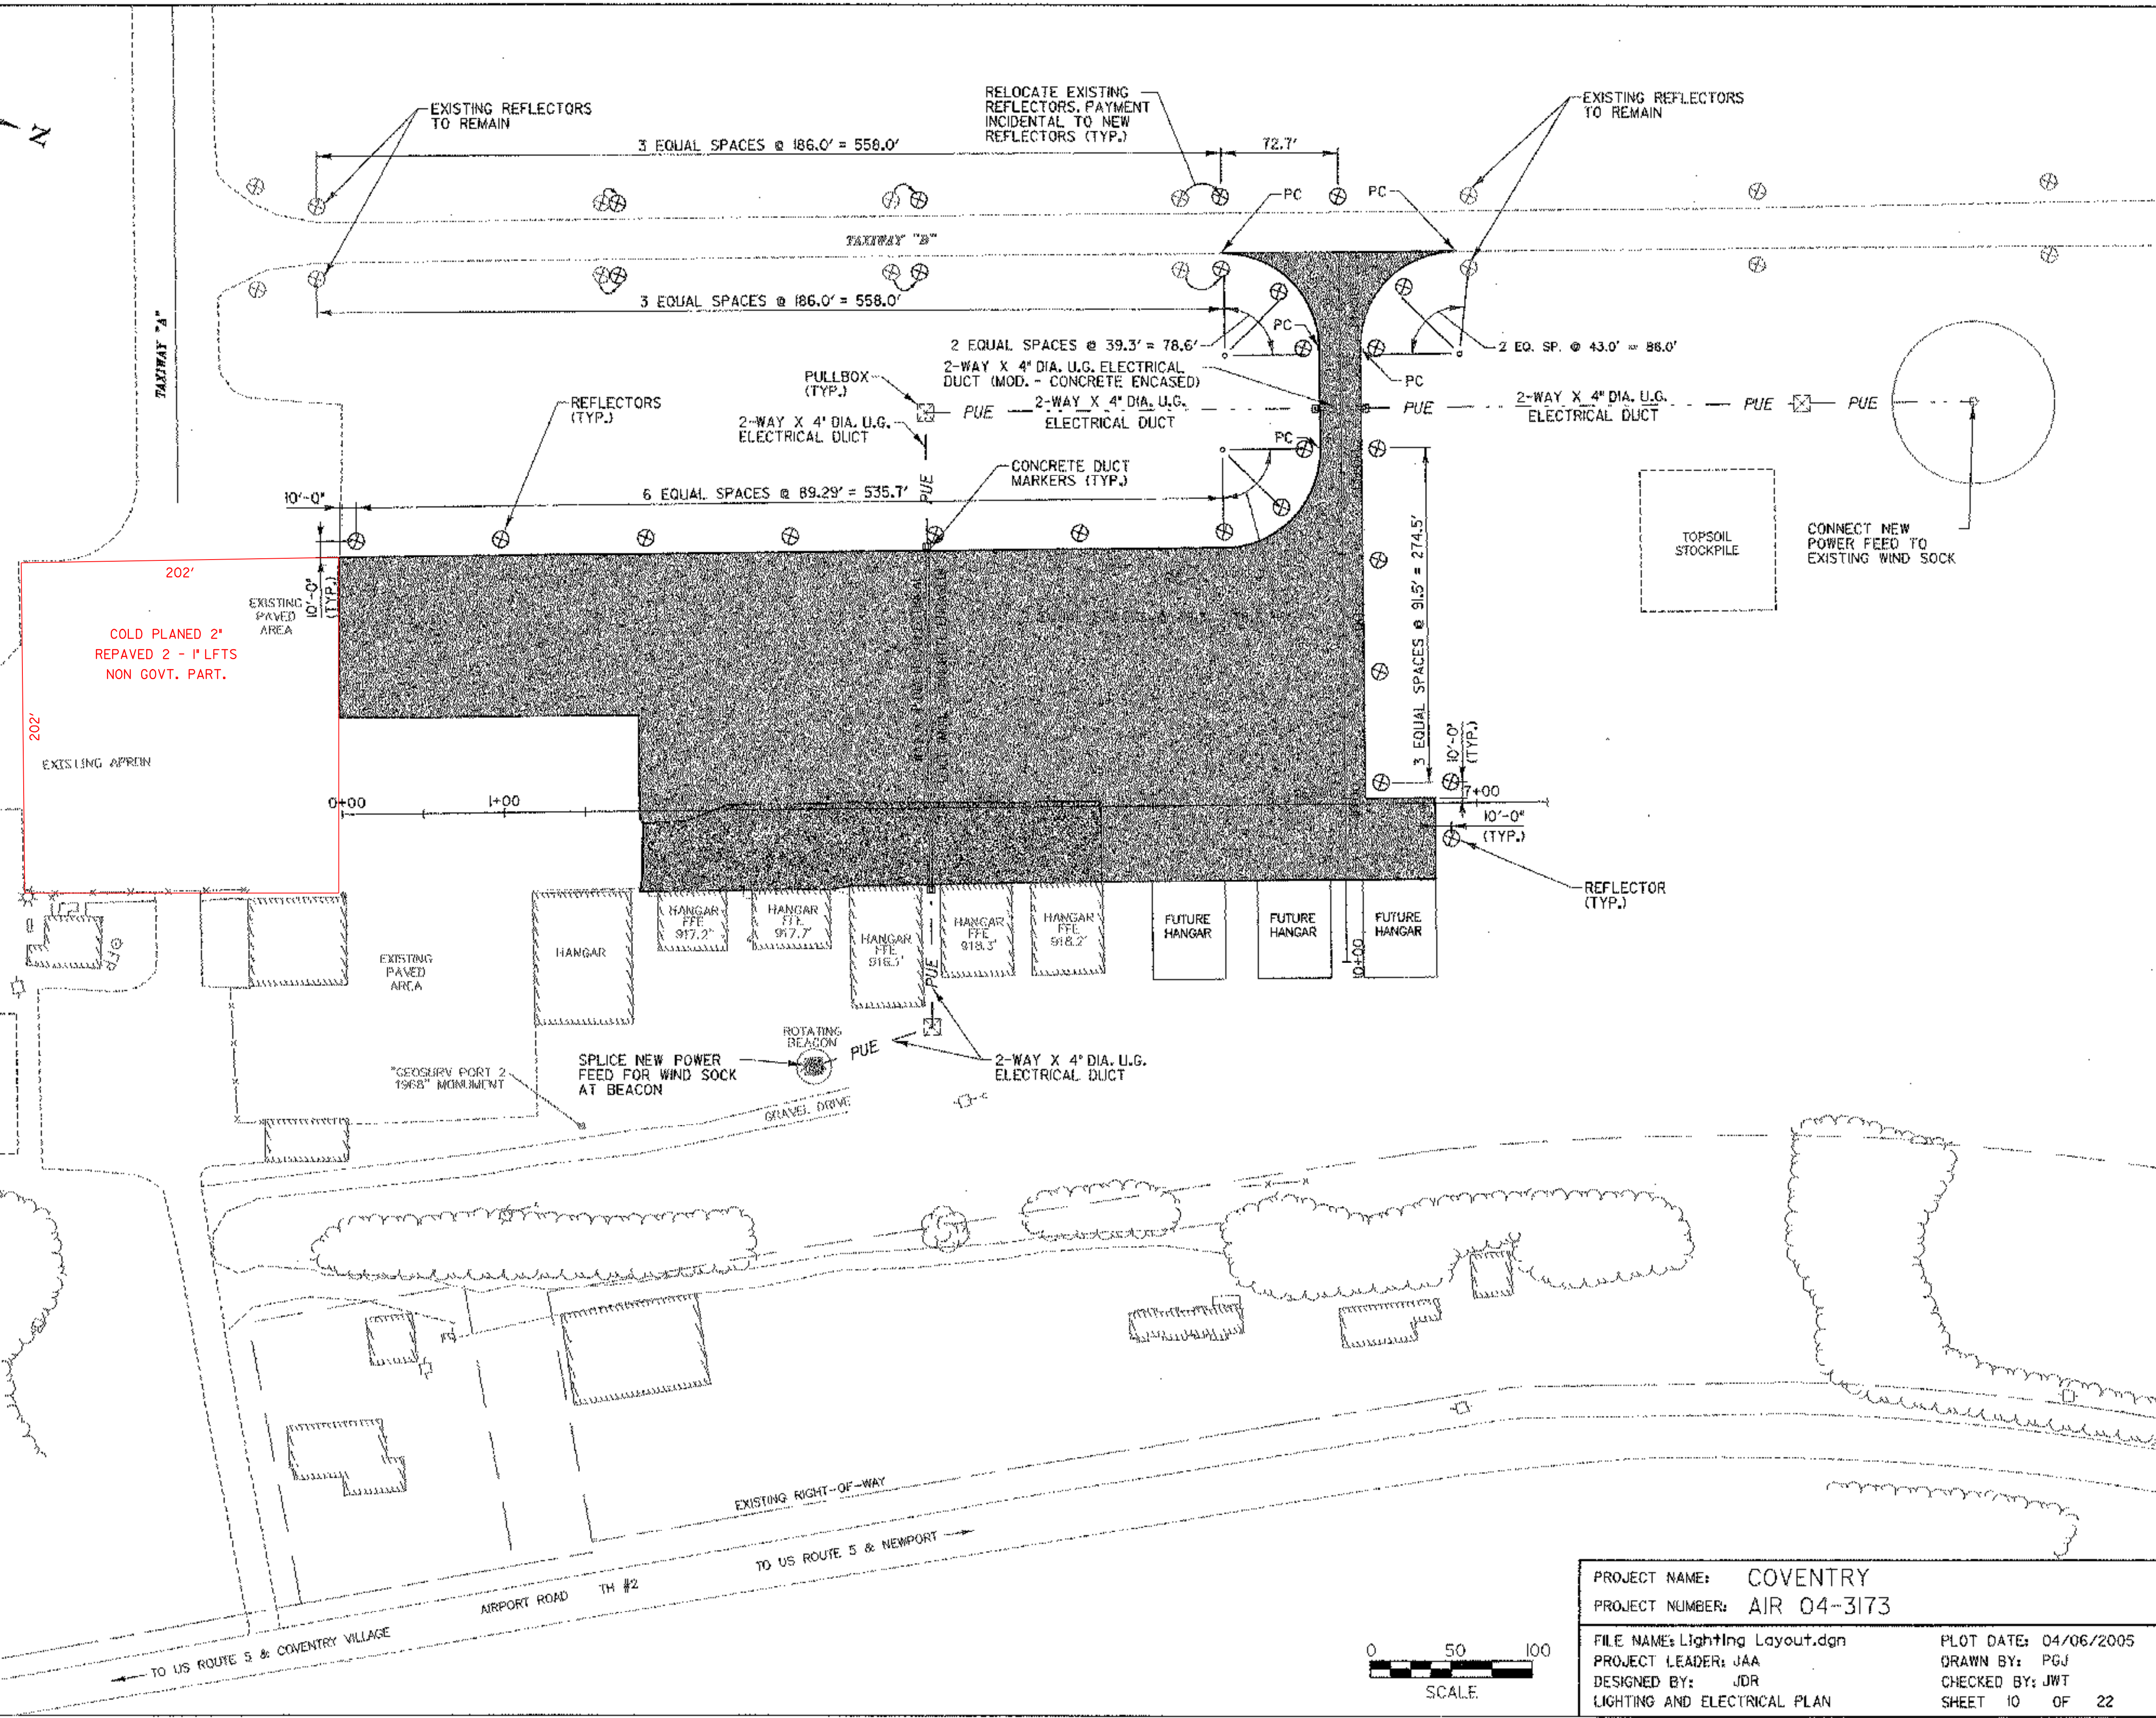

DATUM  
 VERTICAL NAVD 88  
 HORIZONTAL NAD 83

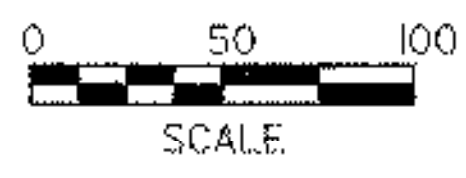

PROJECT NAME: COVENTRY  
 PROJECT NUMBER: AIR 04-3173  
 FILE NAME: Lighting Layout.dgn  
 PROJECT LEADER: JAA  
 DESIGNED BY: JDR  
 LIGHTING AND ELECTRICAL PLAN

PLOT DATE: 04/06/2005  
 DRAWN BY: PGJ  
 CHECKED BY: JWT  
 SHEET 10 OF 22