



**TRENCH DRAIN  
CATCH BASIN DETAIL**

NOT TO SCALE

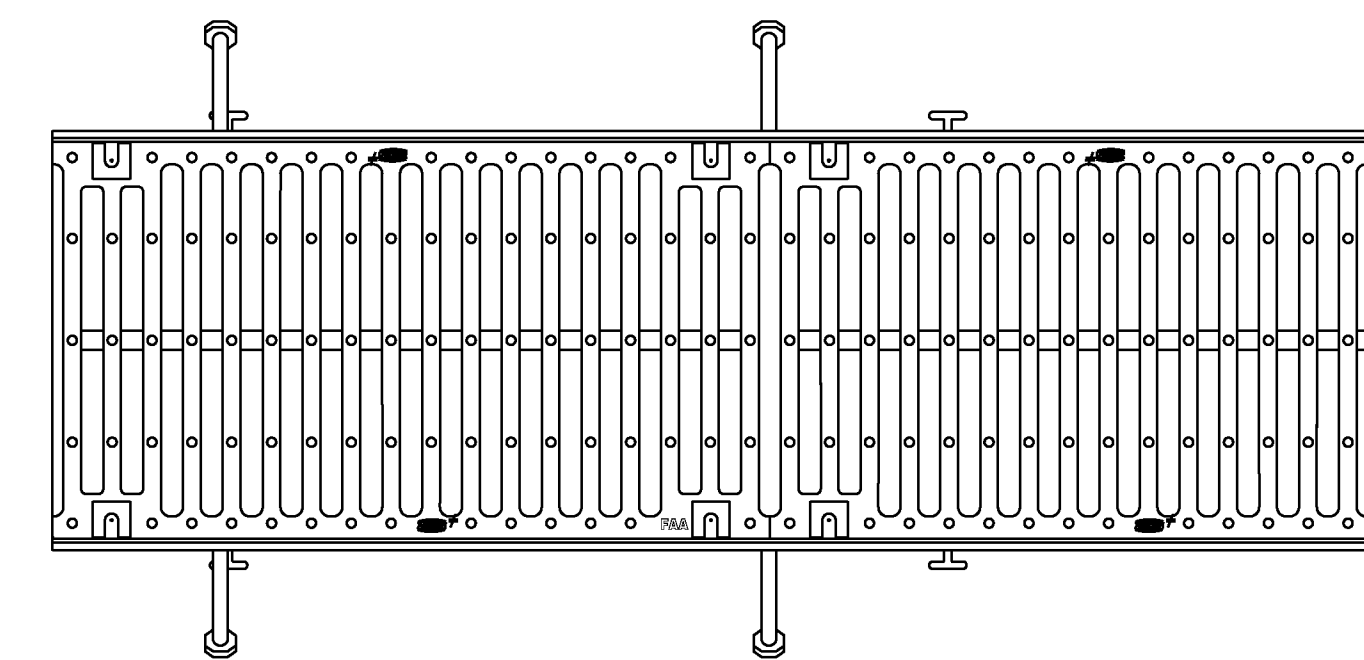

**TRENCH DRAIN  
GRATE DETAIL**

NOT TO SCALE

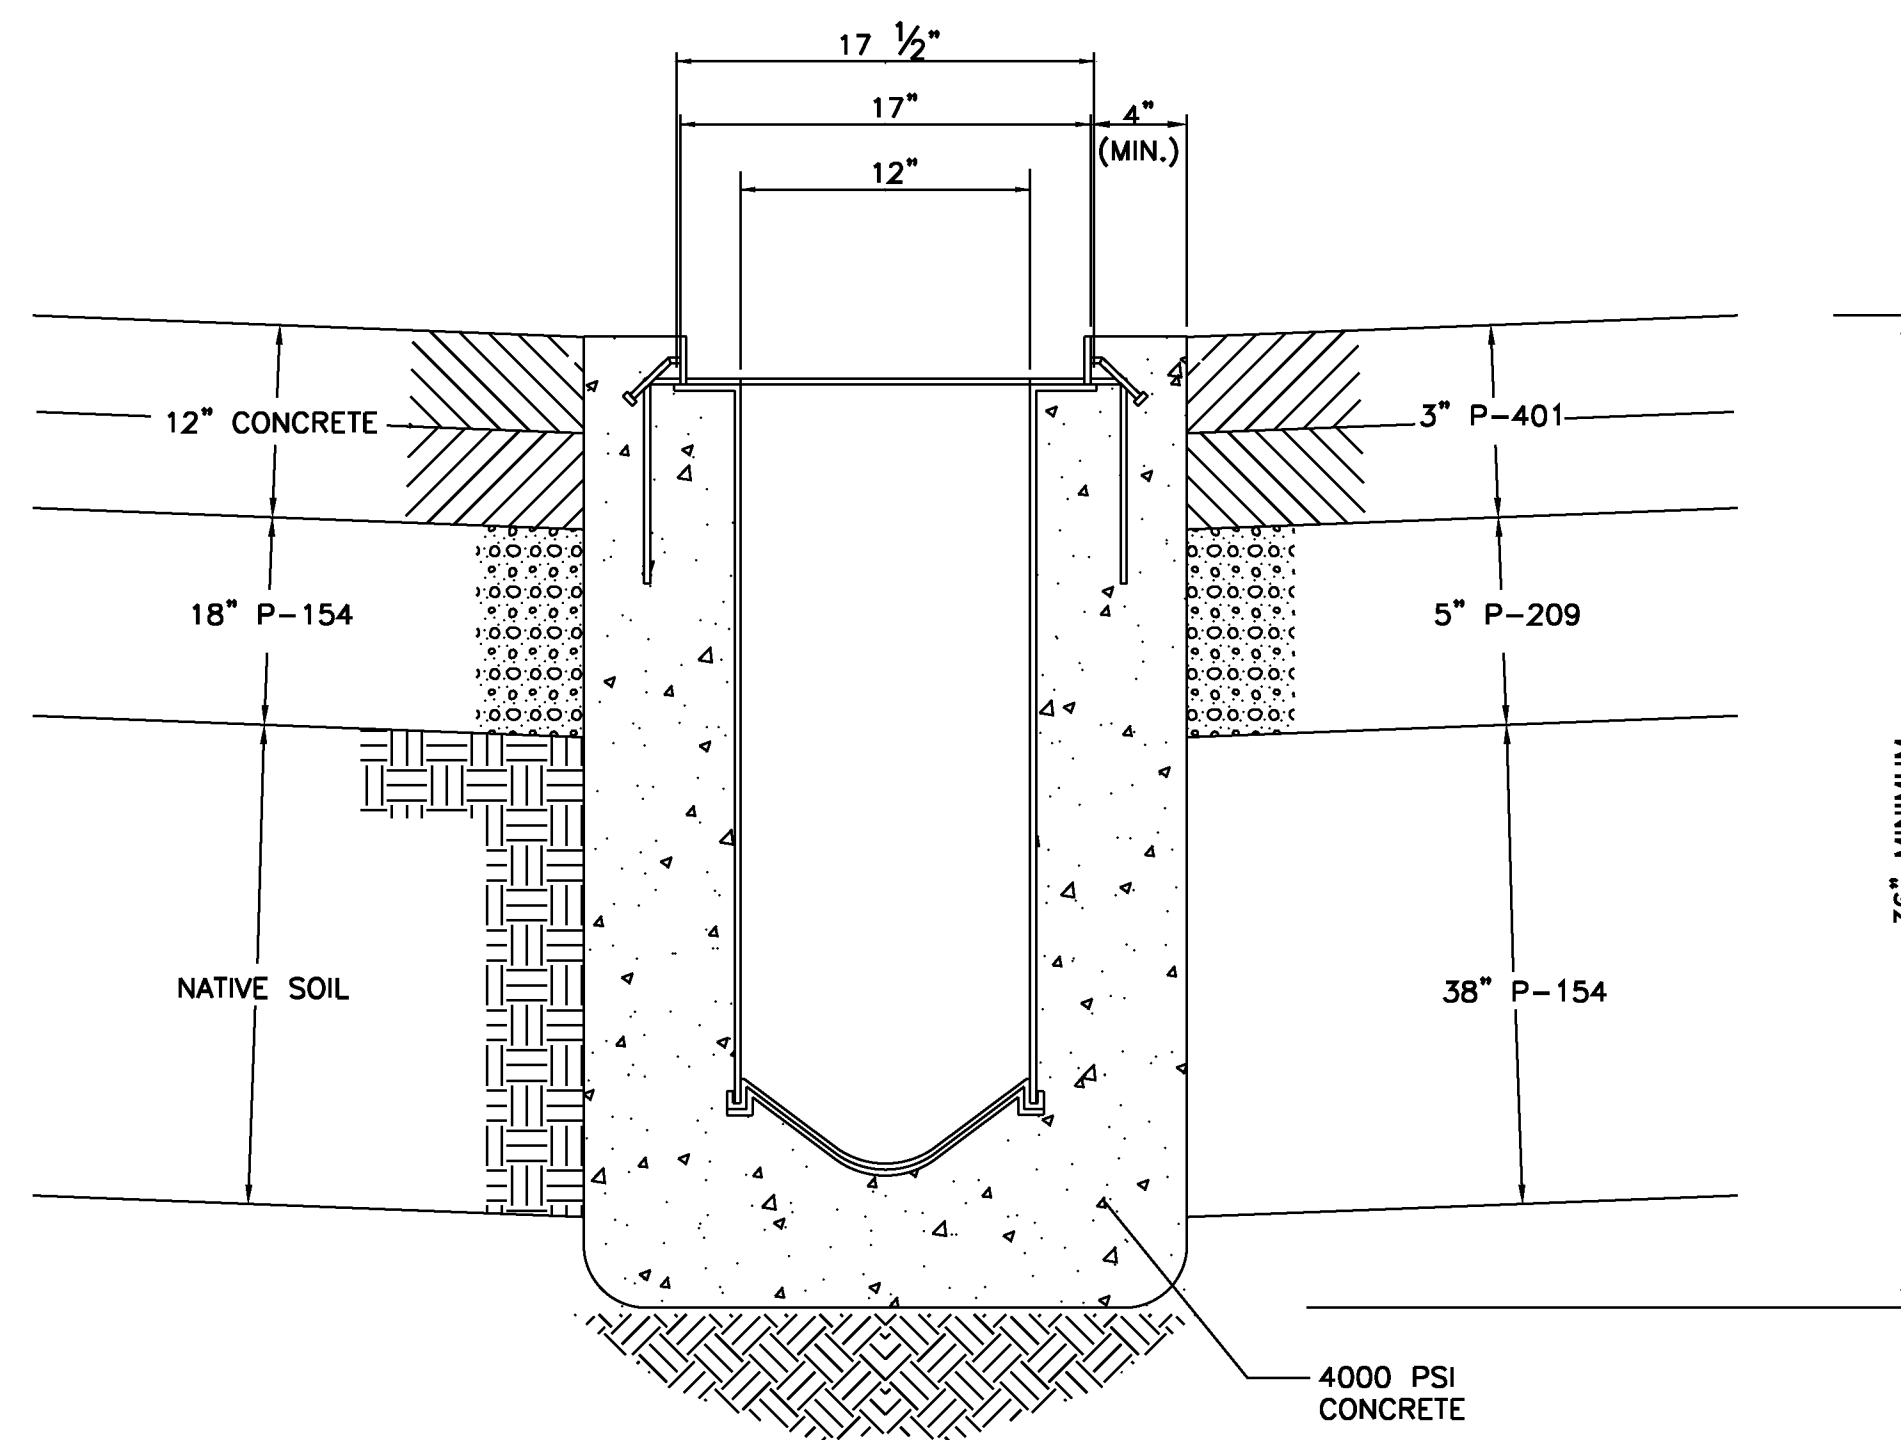

**TRENCH DRAIN  
DETAIL**

NOT TO SCALE

NOTES:

1. CONTRACTOR SHALL SUBMIT SHOP DRAWINGS AND MANUFACTURER'S CERTIFICATIONS FOR REVIEW PRIOR TO INSTALLATION.
2. TRENCH DRAIN GRATE ELEVATION, SEE GRADING PLAN.
3. TRENCH DRAIN INVERT ELEVATION, SEE GRADING PLAN.

**Hoyle, Tanner  
& Associates, Inc.**

150 Dow Street  
Manchester, NH 03101-1227  
Tel 603-669-5555  
Fax 603-669-4168  
Web Page: [www.hoyletanner.com](http://www.hoyletanner.com)  
Hoyle Tanner & Associates © 2008

PROJECT NAME: E. F. KNAPP STATE AIRPORT  
A.I.P. 3-50-0001-011-2009  
PROJECT NUMBER: BERLIN AIR 04-3216

FILE NAME: 302803\_sht\_drain.dwg PLOT DATE: 11/22/2011  
PROJECT LEADER: S. FORTNEY DRAWN BY: D. STANDISH  
DESIGNED BY: S. BOUCHARD CHECKED BY: J. DOWNAR  
TRENCH DRAIN DETAILS SHEET 93 OF 173