



STATE OF VERMONT AGENCY OF TRANSPORTATION

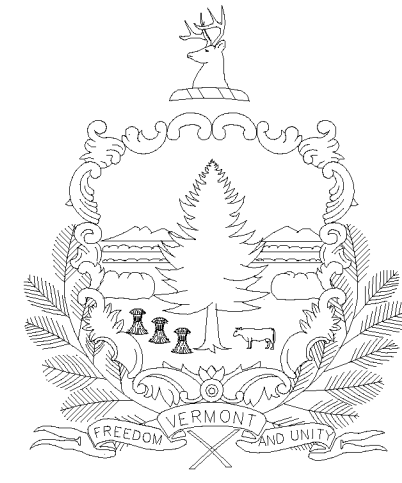


HARTNESS STATE AIRPORT HAZARD BEACON REPLACEMENT SPRINGFIELD, VERMONT

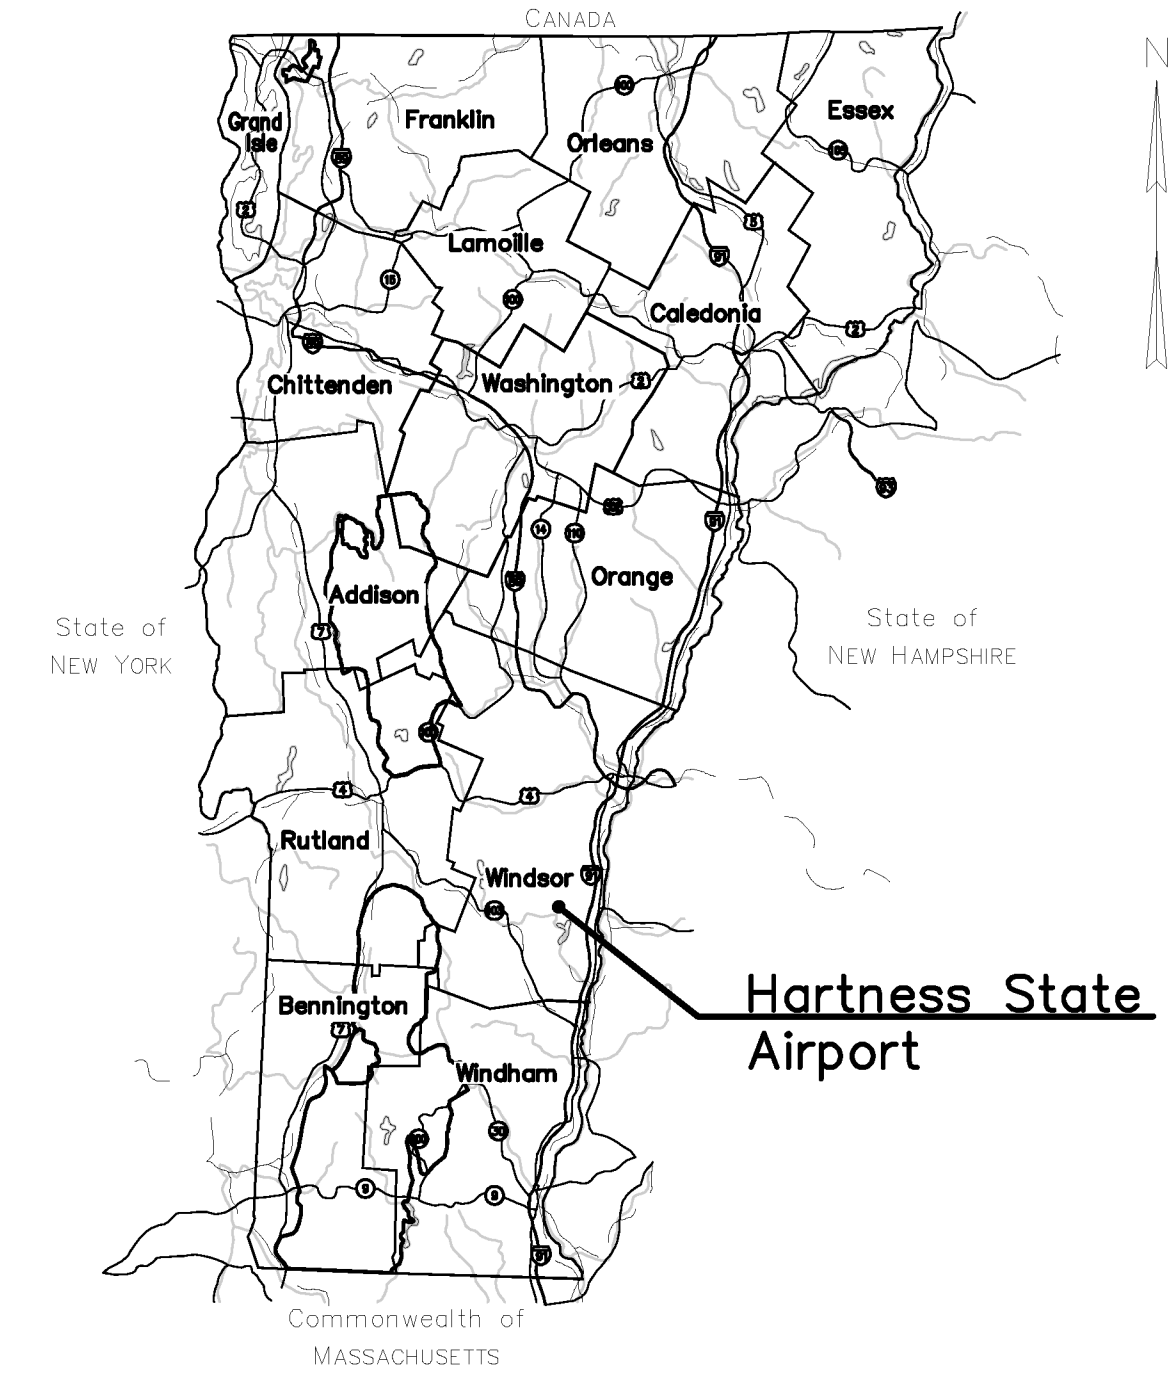

STATE OF VERMONT
NOT TO SCALE

INDEX OF SHEETS:


- C-001 TITLE SHEET
- C-002 GENERAL NOTES
- C-003 SUBSURFACE LOGS
- C-004 SUBSURFACE LOGS
- C-005 SUBSURFACE LOG PLANS
- C-101 BEACON 1 SITE PLAN
- C-102 BEACON 17 SITE PLAN
- C-103 BEACON 18 SITE PLAN
- C-104 BEACON 19 SITE PLAN
- E-001 ELECTRICAL LEGEND & NOTES
- E-401 ELECTRICAL DETAILS
- E-402 ELECTRICAL DETAILS
- S-101 STRUCTURAL DETAILS
- S-102 STRUCTURAL DETAILS

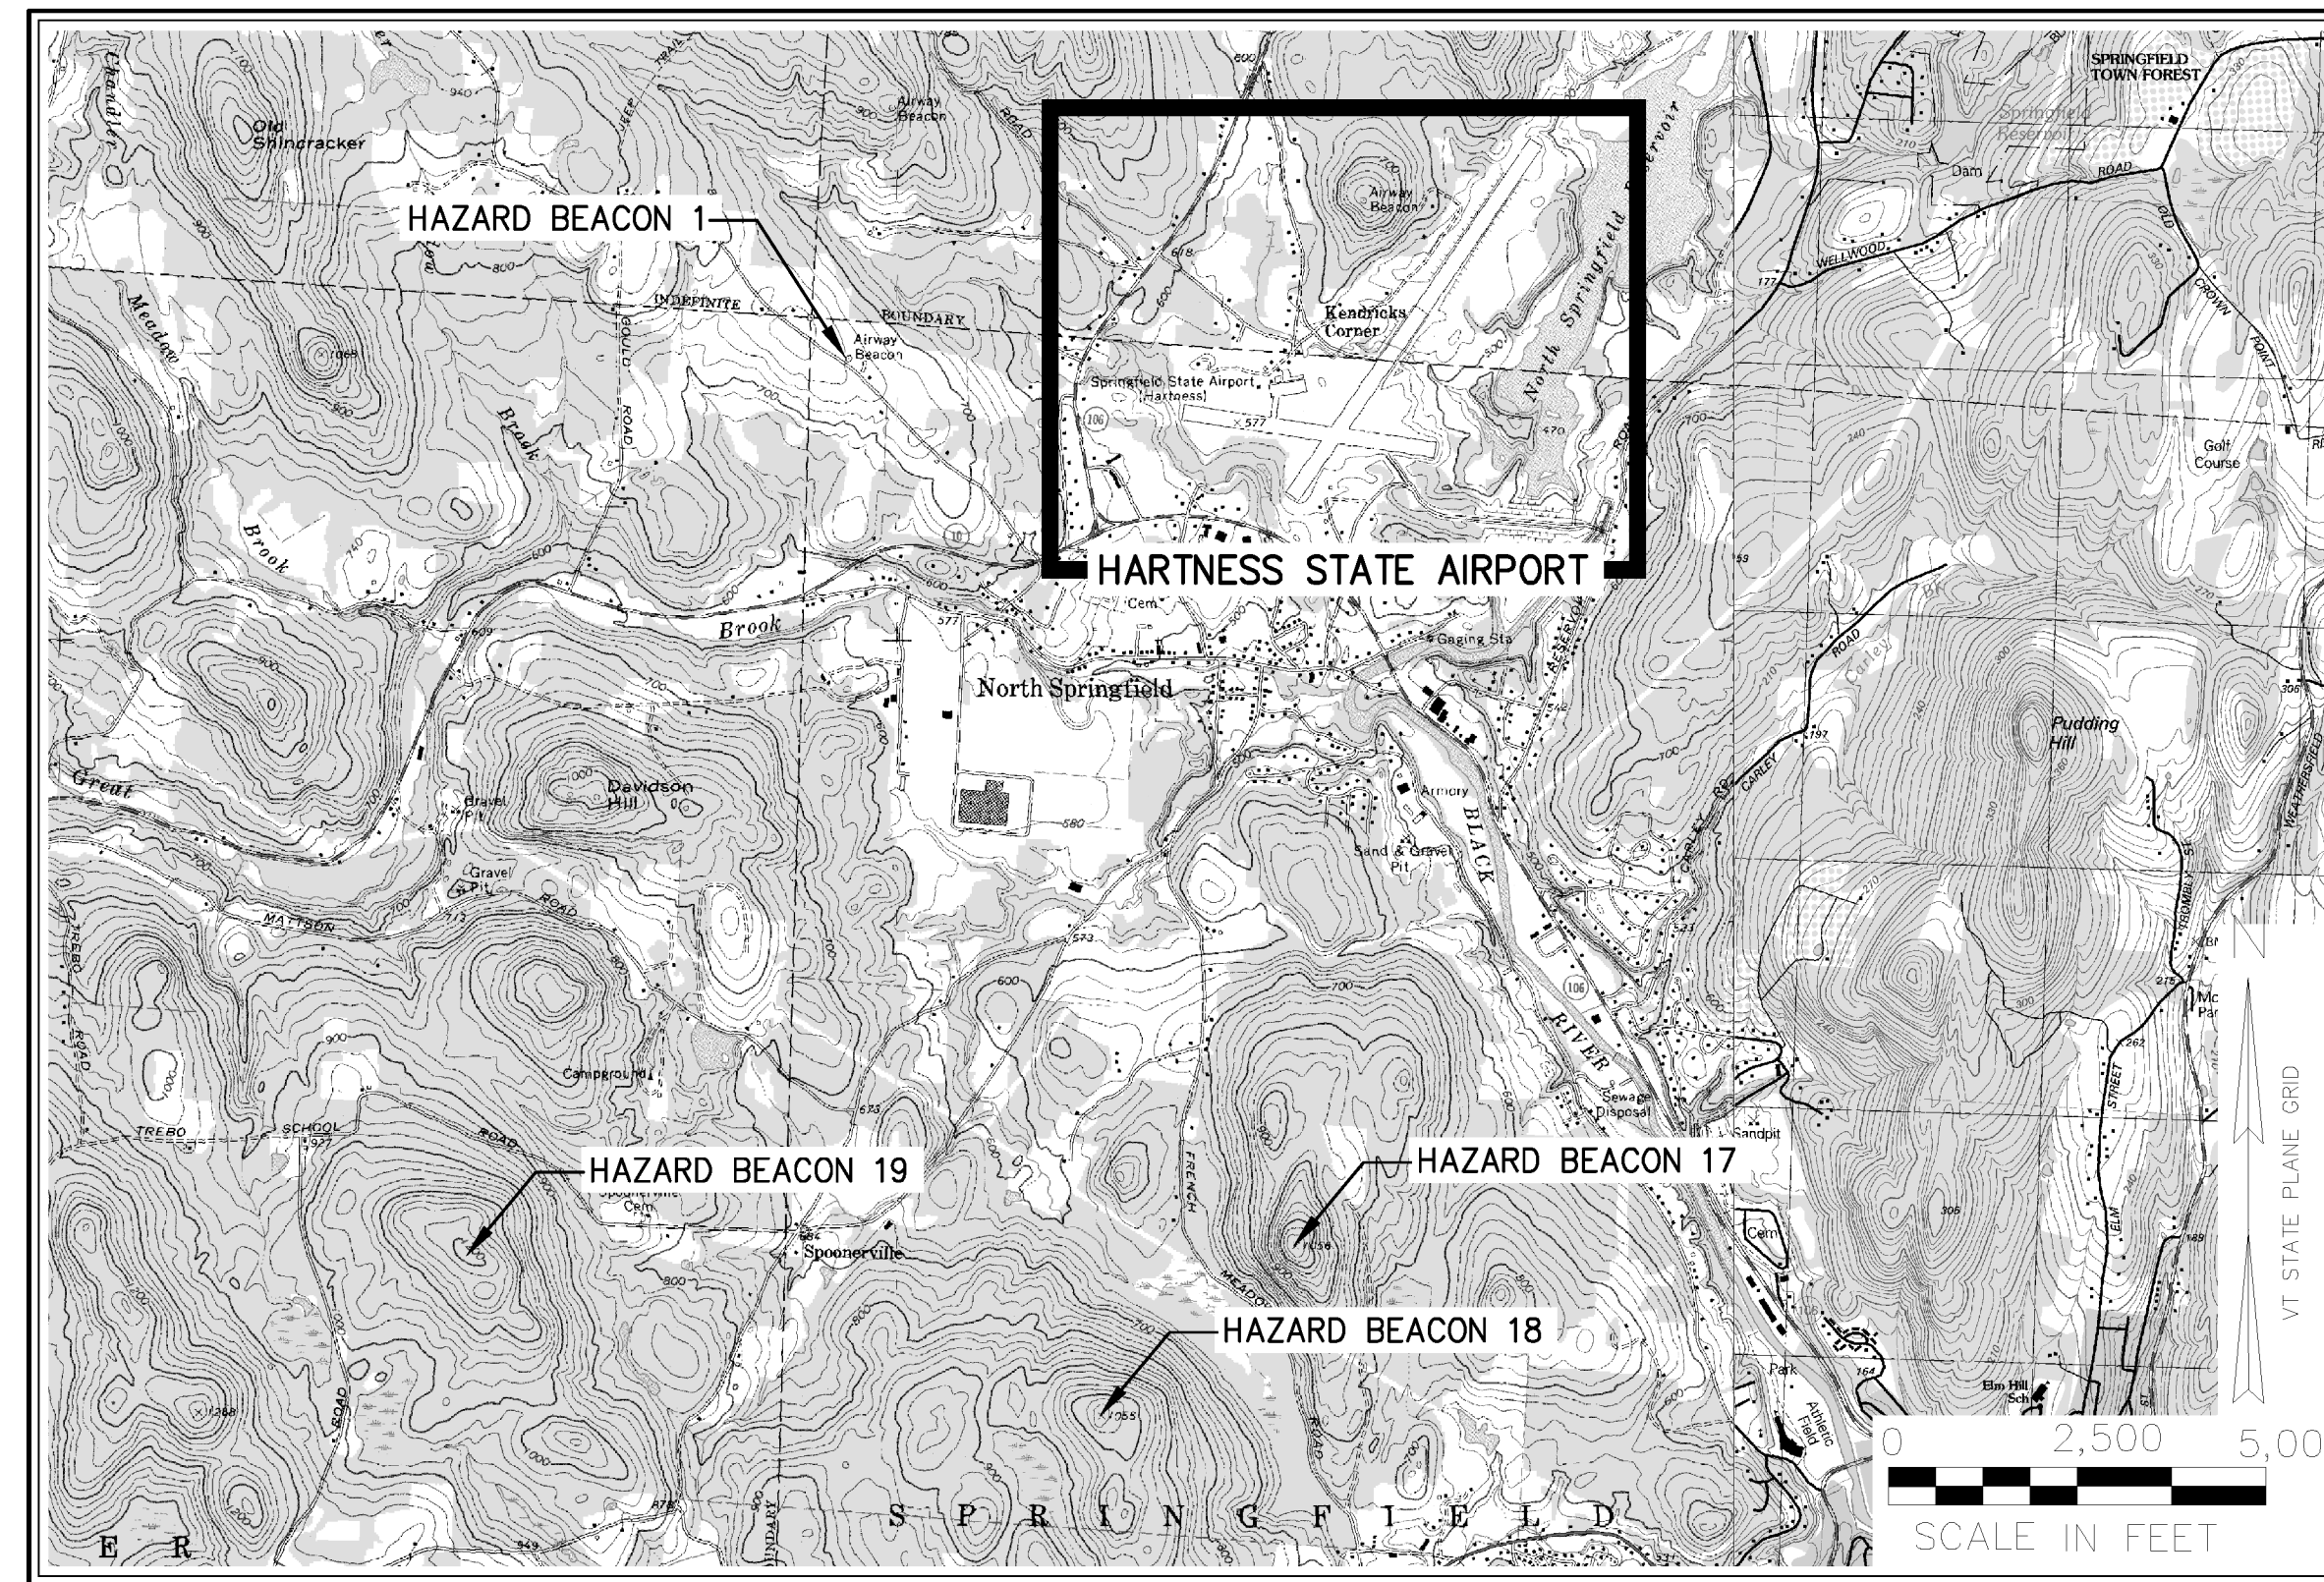

BEACON LOCATION MAP
SCALE: AS NOTED

App'd By	Date
HAW	07/07/13
Submitted / Revision	
RECORD DRAWINGS	

STATE OF VERMONT
AGENCY OF TRANSPORTATION

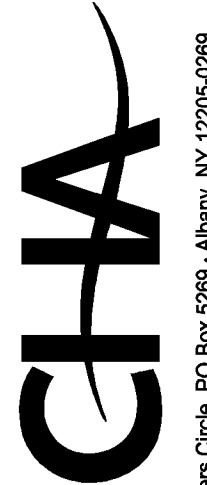
 III Winners Circle, PO Box 5089 - Albany, NY 12205-0289
 Main: (518) 453-4500 • www.chacompanies.com
 Designed: HAW | Drawn: HAW | Checked: TYL

HARTNESS STATE AIRPORT
 HAZARD BEACON REPLACEMENT
 TITLE SHEET
 Issue Date: 03/18/11 | Project No.: 21674 | Scale: As Shown

RECORD DRAWING 07/07/13

C-001

File: V:\PROJECTS\WV\21674\CADD\ACAD\...SHEET_FILES\C001-21674.DWG
 Saved: 1/4/2013 4:14:12 PM Printed: 1/4/2013 4:25:25 PM User: WyoL, Heather LastSavedBy: 2789