
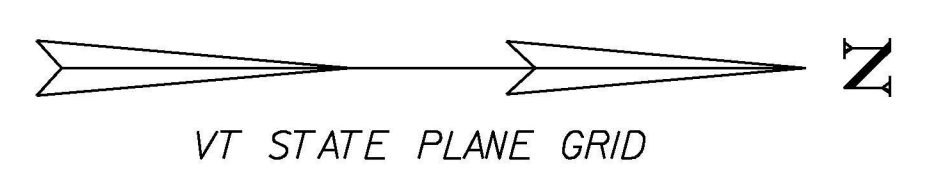


6/2/2013
P:\CADD\Consultants\z07h124drn.dgn

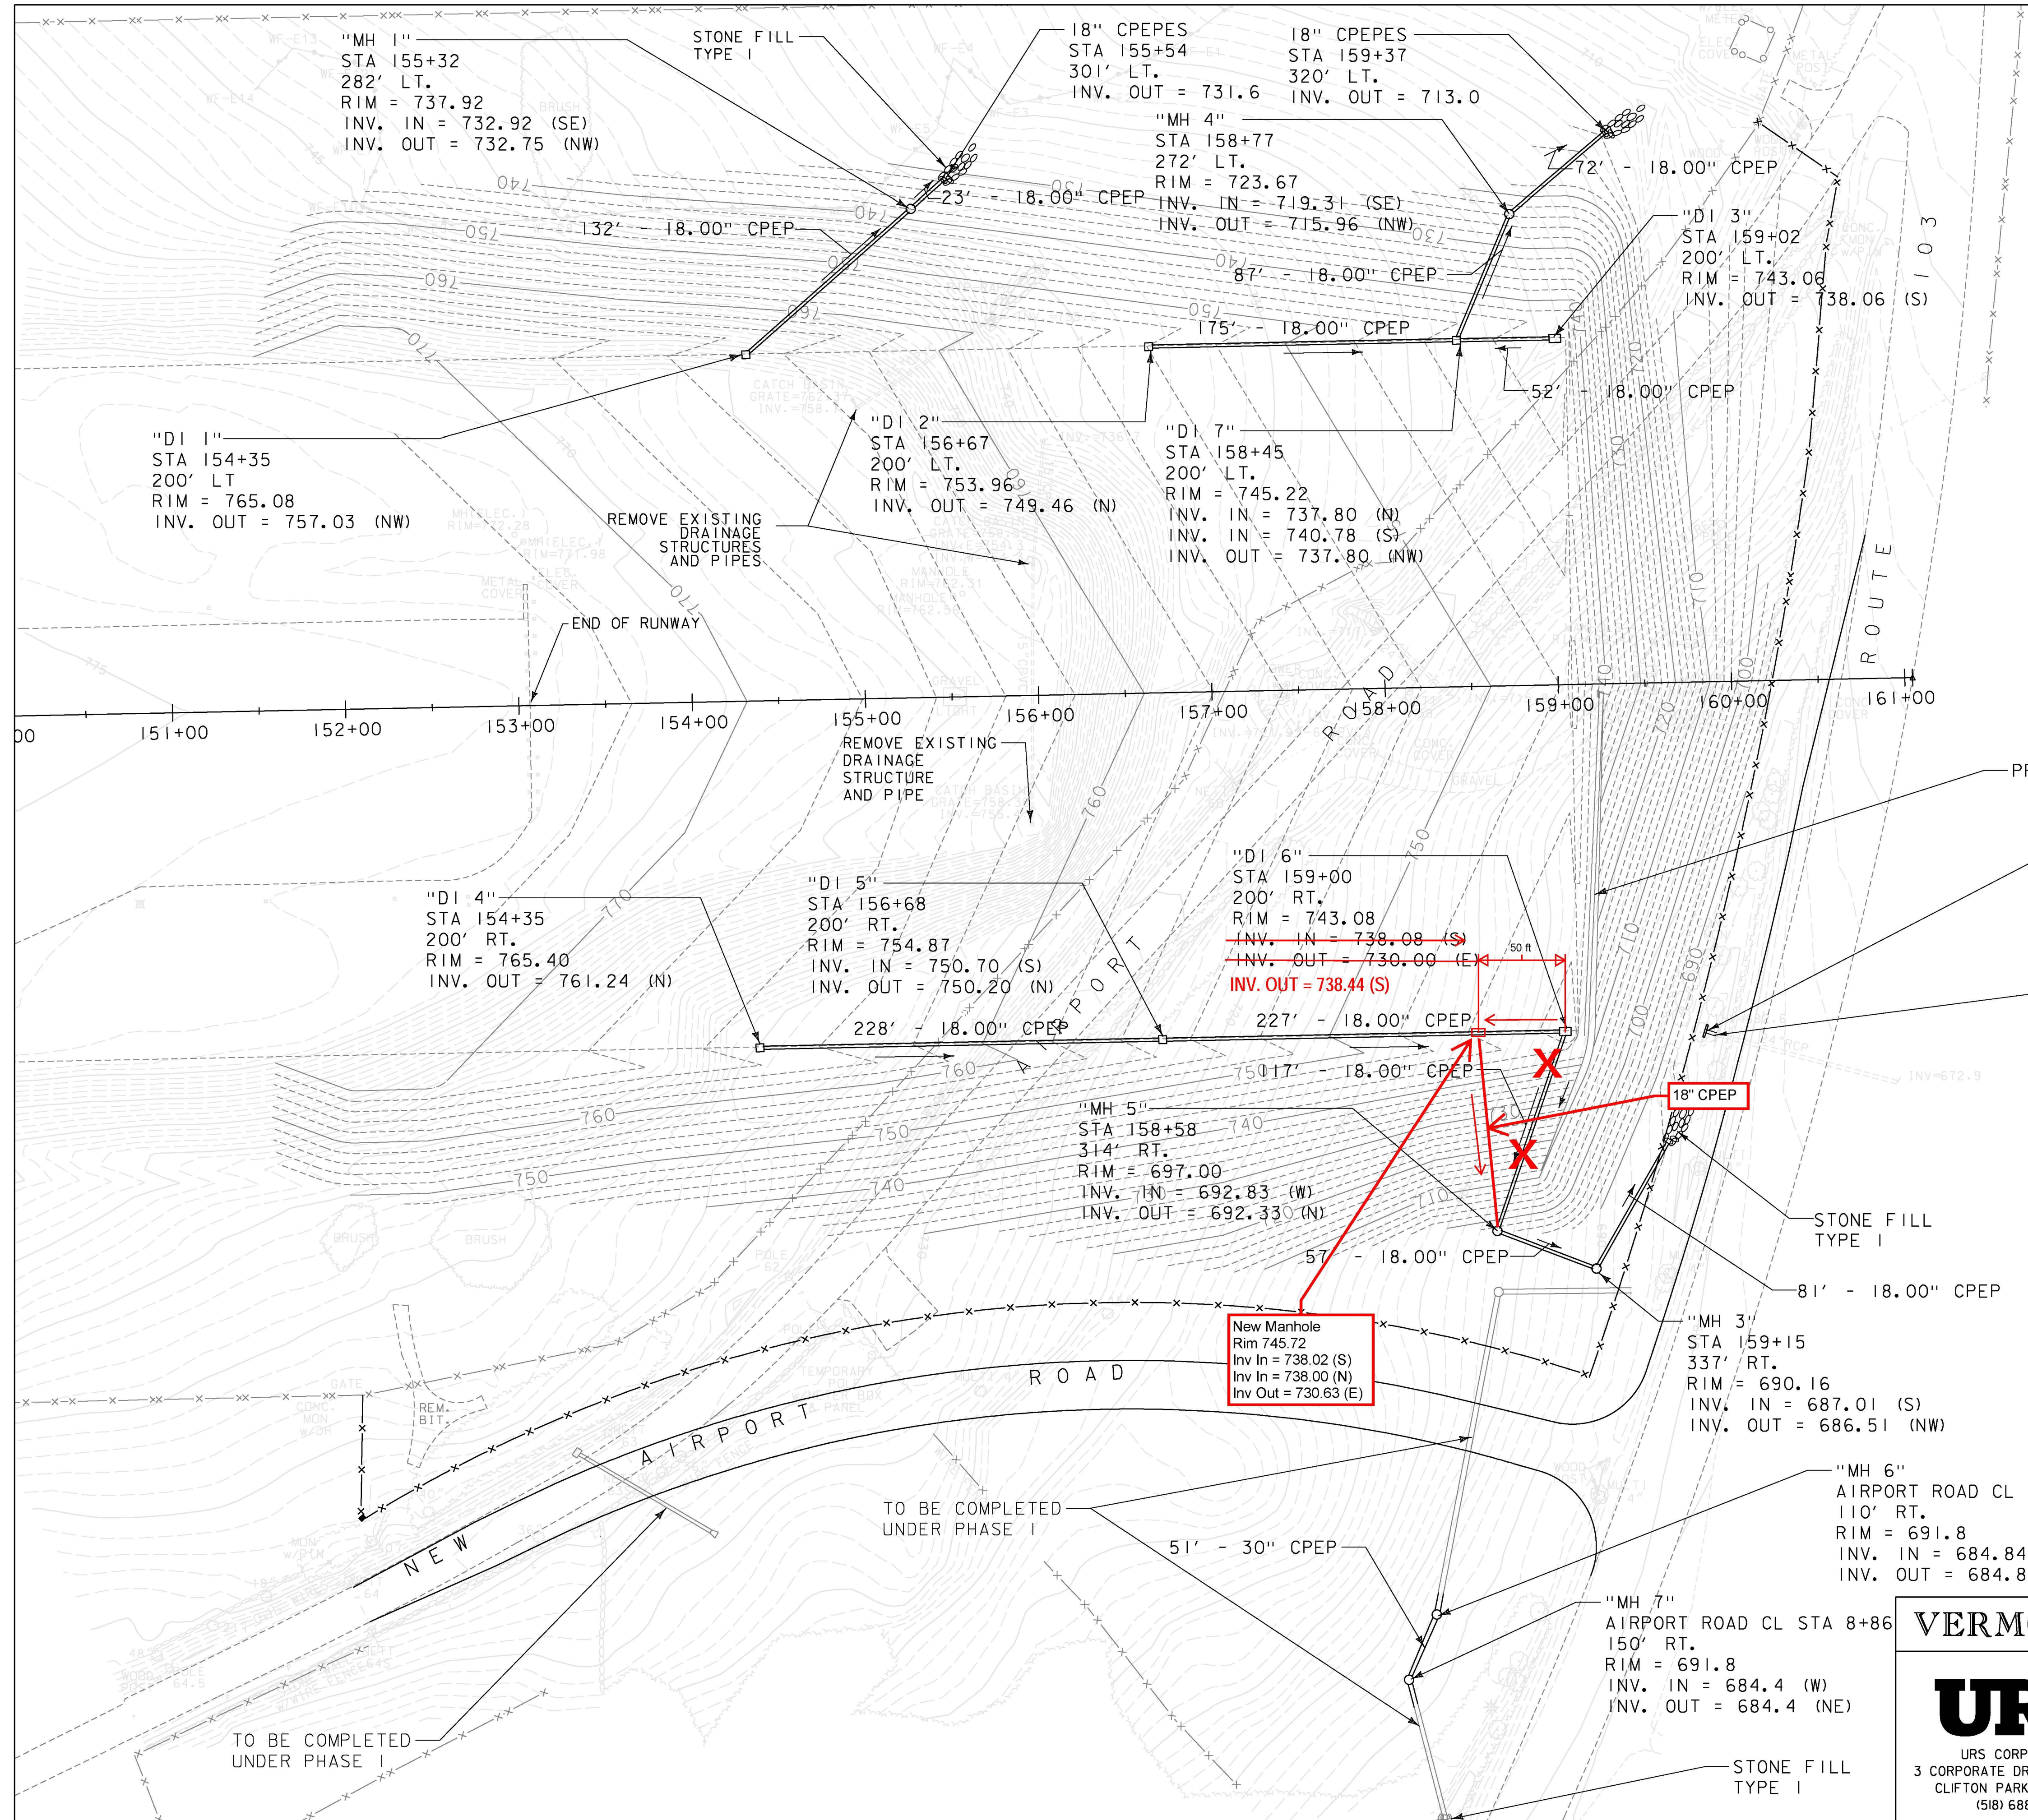


Record Drawings
 Manhole finished rims and locations are shown on Attachment A: Construction Survey Record Plan

LEGEND

	EXISTING CONTOUR W/ELEV.
	EXISTING INT. CONTOUR
	PROPOSED CONTOUR W/ELEV.
	PROPOSED INT. CONTOUR

NOTE:
 CONTRACTOR TO INSTALL 6" PVC UNDER DRAIN A MINIMUM OF 2' FROM TAIL OF PRECAST RETAINING WALL BLOCKS

PHASE I AWARDED UNDER SEPARATE CONTRACT

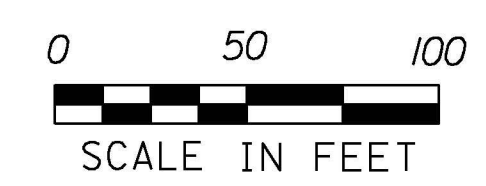

AIP 3-50-0015-34

VERMONT AGENCY OF TRANSPORTATION

 URS CORPORATION 3 CORPORATE DRIVE, SUITE 203 CLIFTON PARK, NY 12065 (518) 688-0015	PROJECT NAME: RUTLAND SOUTHERN VERMONT REGIONAL AIRPORT CLARENDON, VERMONT PROJECT NUMBER: AV14-8018-300	FILE NAME: z07h124drn.dgn PROJECT LEADER: F. WALSH DESIGNED BY: G. D'AMICO DRAINAGE PLAN	PLOT DATE: 6/2/2013 DRAWN BY: M. KEMP CHECKED BY: SHEET 15 OF 36
---	--	---	---