


NOTES:

- REFER TO SHEET P1-05 FOR STRUCTURE DATA.
- REFER TO SHEET PR1-01 FOR SITE & GRAVITY SEWER PROFILE.
- REFER TO SHEET SD-01 FOR PUMP STATION S116 DETAILS.
- REFER TO SHEET SD-01 FOR PUMP STATION S123 DETAILS.

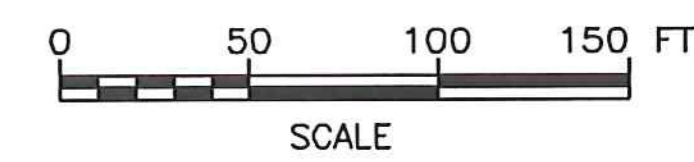

PERMIT PLANS

REV	DATE	DESCRIPTION	BY
5	5/3/15	COLD WEATHER MODIFICATIONS	BMB
4	4/29/15	PERMITTING MODIFICATIONS	SKI
3	1/30/15	WW SYSTEM MODIFICATIONS	BMB
2	8/5/14	ANR COMMENTS	TCB
1	4/18/14	ADD 400-SERIES TEST PITS	CH

IT IS A VIOLATION OF LAW FOR ANY PERSON, UNLESS THEY ARE ACTING UNDER THE DIRECT DIRECTION OF A LICENSED PROFESSIONAL ENGINEER, ARCHITECT, LANDSCAPE ARCHITECT, OR LAND SURVEYOR, TO ALTER AN ITEM IN ANY WAY. IF AN ITEM BEARING THE STAMP OF A LICENSED PROFESSIONAL IS ALTERED, THE ALTERING ENGINEER, ARCHITECT, LANDSCAPE ARCHITECT, OR LAND SURVEYOR SHALL STAMP THE DOCUMENT AND INCLUDE THE NOTATION "ALTERED BY" FOLLOWED BY THEIR SIGNATURE, THE DATE OF SUCH ALTERATION, AND A SPECIFIC DESCRIPTION OF THE ALTERATION.

NEWPORT STATE AIRPORT
COVENTRY, VERMONT
NEWPORT WASTEWATER

SITE 1 - PIPING LAYOUT PLAN 1



McFarland Johnson
53 REGIONAL DRIVE
CONCORD, NH 03301

SCALE: 1" = 50'
DESIGN: TCB
DRAWN: TCB
CHECKED: BLS
PROJECT: 17958.01
DATE: JUNE, 2014
P1-01
5 of 36