


KEY PLAN - NOT TO SCALE


LEGEND:

	EXISTING CONTOUR		STORMDRAIN PIPE
	PROPOSED CONTOUR		STORMDRAIN STRUCTURE
	PROPERTY LINE		FUTURE WATER LINE
	WETLAND		TEMPORARY WATER LINE
	TREE LINE		
	SANITARY FORCE MAIN		
	SANITARY MANHOLE		
	SANITARY GRAVITY SEWER LINE		
	SANITARY STRUCTURE IDENTIFICATION		

- NOTES:**
- REFER TO SHEET P1-05 FOR STRUCTURE DATA.
 - REFER TO SHEET PR1-01 AND PR1-02 FOR SITE 1 GRAVITY SEWER PROFILE INFORMATION.
 - REFER TO SHEET PR1-03 FOR SITE 1 FORCE MAIN SEWER PROFILE.
 - REFER TO SHEET SD-01 FOR PUMP STATION S105 DETAILS.
 - REFER TO SHEET SD-02 FOR PUMP STATION S128 DETAILS.

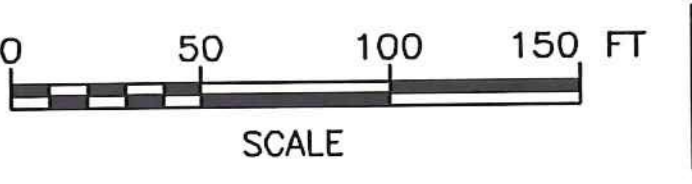

PERMIT PLANS

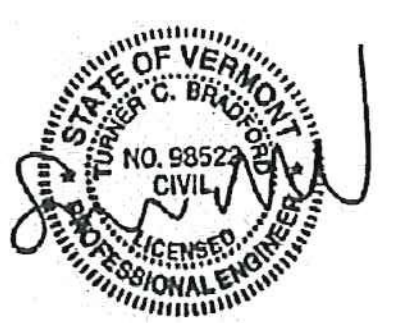

REV	DATE	DESCRIPTION	BY
5	5/3/15	COLD WEATHER MODIFICATIONS	BMB
4	4/29/15	PERMITTING MODIFICATIONS	SKI
3	1/30/15	WW SYSTEM MODIFICATIONS	BMB
2	8/5/14	ANR COMMENTS	TCB
1	4/18/14	ADD 400-SERIES TEST PITS	CH

McFarland Johnson
53 REGIONAL DRIVE
CONCORD, NH 03301

IT IS A VIOLATION OF LAW FOR ANY PERSON, UNLESS THEY ARE ACTING UNDER THE DIRECT DIRECTION OF A LICENSED PROFESSIONAL ENGINEER, ARCHITECT, LANDSCAPE ARCHITECT, OR LAND SURVEYOR, TO ALTER AN ITEM IN ANY WAY. IF AN ITEM BEARING THE STAMP OF A LICENSED PROFESSIONAL IS ALTERED, THE ALTERING ENGINEER, ARCHITECT, LANDSCAPE ARCHITECT, OR LAND SURVEYOR SHALL STAMP THE DOCUMENT AND INCLUDE THE NOTATION "ALTERED BY" FOLLOWED BY THEIR SIGNATURE, THE DATE OF SUCH ALTERATION, AND A SPECIFIC DESCRIPTION OF THE ALTERATION.

NEWPORT STATE AIRPORT COVENTRY, VERMONT NEWPORT WASTEWATER		
SITE 1 - PIPING LAYOUT PLAN 2		
SCALE: 1" = 50'	DESIGN: TCB	P1-02
DRAWN: TCB	PROJECT: 17958.01	6 OF 36
CHECKED: BLS	DATE: JUNE, 2014	