



NOT CONSTRUCTED AS PART OF THIS CONTRACT.

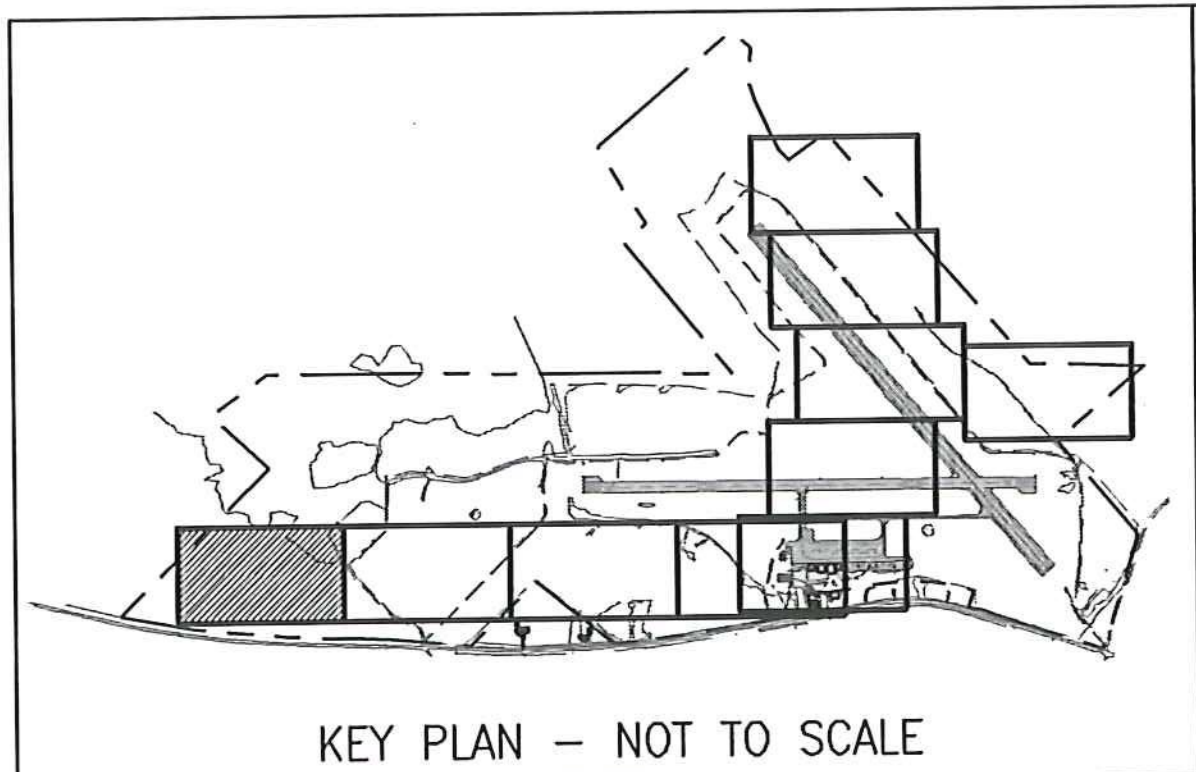

LEGEND:


	EXISTING CONTOUR
	PROPOSED CONTOUR
	PROPERTY LINE
	WETLAND
	TREE LINE
	SANITARY FORCE MAIN
	SANITARY MANHOLE
	SANITARY GRAVITY SEWER LINE

- NOTES:**
1. REFER TO SHEET P1-05 FOR STRUCTURE DATA.
 2. REFER TO SHEET PR1-04 AND PR1-05 FOR SITE 1 FORCE MAIN SEWER PROFILE.
 3. REFER TO SHEET MD1-01 FOR MOUND A DETAILS.
 4. REFER TO SHEET MD1-02 FOR MOUND B DETAILS.
 5. REFER TO SHEET SD-02 FOR PUMP STATION S135 DETAILS.

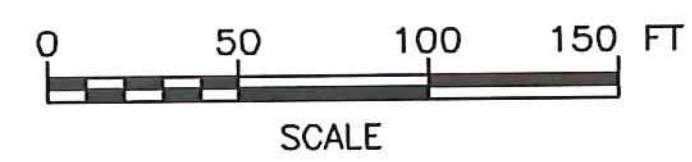

PERMIT PLANS

IT IS A VIOLATION OF LAW FOR ANY PERSON, UNLESS THEY ARE ACTING UNDER THE DIRECT DIRECTION OF A LICENSED PROFESSIONAL ENGINEER, ARCHITECT, LANDSCAPE ARCHITECT, OR LAND SURVEYOR, TO ALTER AN ITEM IN ANY WAY. IF AN ITEM BEARING THE STAMP OF A LICENSED PROFESSIONAL IS ALTERED, THE ALTERING ENGINEER, ARCHITECT, LANDSCAPE ARCHITECT, OR LAND SURVEYOR SHALL STAMP THE DOCUMENT AND INCLUDE THE NOTATION "ALTERED BY" FOLLOWED BY THEIR SIGNATURE, THE DATE OF SUCH ALTERATION, AND A SPECIFIC DESCRIPTION OF THE ALTERATION.

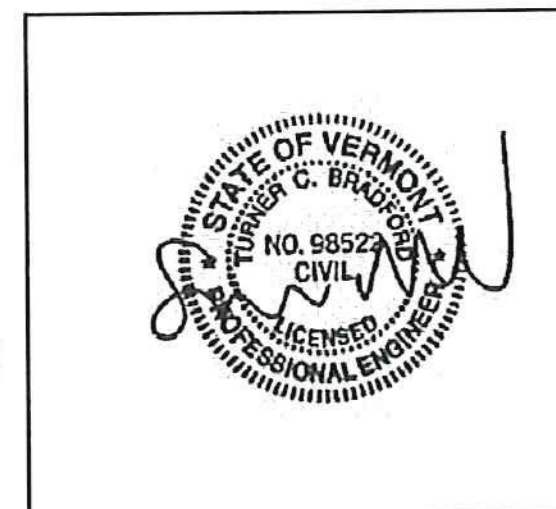

REV	DATE	DESCRIPTION	BY
5	5/3/15	COLD WEATHER MODIFICATIONS	BMB
4	4/29/15	PERMITTING MODIFICATIONS	SKI
3	1/30/15	WW SYSTEM MODIFICATIONS	BMB
2	8/5/14	ANR COMMENTS	TCB
1	4/18/14	ADD 400-SERIES TEST PITS	CH

NEWPORT STATE AIRPORT
COVENTRY, VERMONT
NEWPORT WASTEWATER
SITE 1 - PIPING LAYOUT PLAN 4



McFarland Johnson
53 REGIONAL DRIVE
CONCORD, NH 03301

SCALE: 1" = 50'	DESIGN: TCB	P1-04 8 OF 36
DRAWN: TCB	PROJECT: 17958.01	
CHECKED: BLS	DATE: JUNE, 2014	