


**LEGEND:**

--- 950 ---	EXISTING CONTOUR
— 950 —	PROPOSED CONTOUR
---	PROPERTY LINE
	WETLAND
	TREE LINE
— FM —	SANITARY FORCE MAIN
●	SANITARY MANHOLE
○ ST115 ○ S101	SANITARY STRUCTURE IDENTIFICATION

- NOTES:**
- REFER TO SHEET P2-05 FOR STRUCTURE DATA.
  - REFER TO SHEET PR2-01 AND PR2-02 FOR SITE 2 FORCE MAIN SEWER PROFILE.
  - CARRYING PIPE INSIDE SLEEVES SHALL USE CASCADE WATERWORKS MFG. CASING SPACERS MODEL CCS OR EQUAL. ENDS OF SLEEVES SHALL USE CASCADE END SEALS MODEL CCES OR EQUAL.

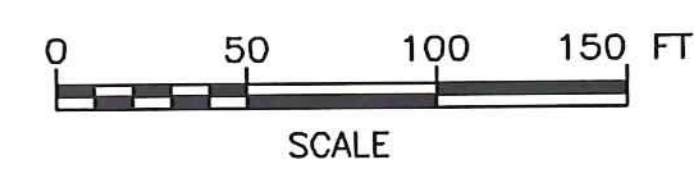


SCHEDULE B - WASTEWATER SYSTEM - BID SET  
VTRANS PROJECT #AV1157046-301  
JUNE 2016

IT IS A VIOLATION OF LAW FOR ANY PERSON, UNLESS THEY ARE ACTING UNDER THE DIRECT DIRECTION OF A LICENSED PROFESSIONAL ENGINEER, ARCHITECT, LANDSCAPE ARCHITECT, OR LAND SURVEYOR, TO ALTER AN ITEM IN ANY WAY. IF AN ITEM BEARING THE STAMP OF A LICENSED PROFESSIONAL IS ALTERED, THE ALTERING ENGINEER, ARCHITECT, LANDSCAPE ARCHITECT, OR LAND SURVEYOR SHALL STAMP THE DOCUMENT AND INCLUDE THE NOTATION "ALTERED BY" FOLLOWED BY THEIR SIGNATURE, THE DATE OF SUCH ALTERATION, AND A SPECIFIC DESCRIPTION OF THE ALTERATION.

REV	DATE	DESCRIPTION	BY
5	5/3/15	COLD WEATHER MODIFICATIONS	BMB
4	4/29/15	PERMITTING MODIFICATIONS	SKI
3	1/30/15	WW SYSTEM MODIFICATIONS	BMB
2	8/5/14	ANR COMMENTS	TCB
1	4/18/14	ADD 400-SERIES TEST PITS	CH

NEWPORT STATE AIRPORT  
COVENTRY, VERMONT  
NEWPORT WASTEWATER

SITE 2 - PIPING LAYOUT PLAN 3

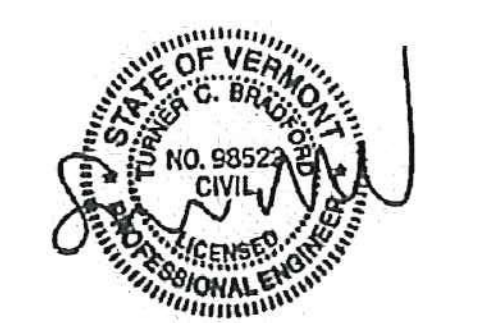

**McFarland Johnson**  
53 REGIONAL DRIVE  
CONCORD, NH 03301

SCALE: 1" = 50'	DESIGN: TCB	P2-03 22 of 36
DRAWN: TCB	PROJECT: 17958.01	
CHECKED: BLS	DATE: JUNE, 2014	