


KEY PLAN - NOT TO SCALE

LEGEND:


	950	EXISTING CONTOUR
	950	PROPOSED CONTOUR
		PROPERTY LINE
		WETLAND
		TREE LINE
	FM	SANITARY FORCE MAIN
		SANITARY MANHOLE
	ST115 S101	SANITARY STRUCTURE IDENTIFICATION

- NOTES:**
1. REFER TO SHEET P2-05 FOR STRUCTURE DATA.
 2. REFER TO SHEET PR2-02 AND PR2-03 FOR SITE 2 FORCE MAIN SEWER PROFILE.
 3. REFER TO SHEET MD2-02 FOR MOUND E DETAILS.

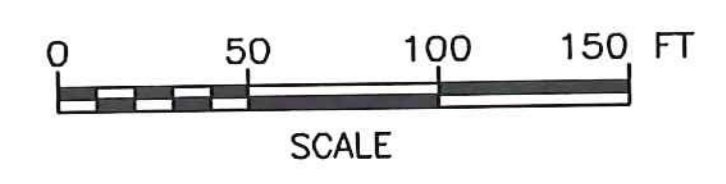

SCHEDULE B - WASTEWATER SYSTEM - BID SET
 VTRANS PROJECT #AV1157046-301
 JUNE 2016

IT IS A VIOLATION OF LAW FOR ANY PERSON, UNLESS THEY ARE ACTING UNDER THE DIRECT DIRECTION OF A LICENSED PROFESSIONAL ENGINEER, ARCHITECT, LANDSCAPE ARCHITECT, OR LAND SURVEYOR, TO ALTER AN ITEM IN ANY WAY. IF AN ITEM BEARING THE STAMP OF A LICENSED PROFESSIONAL IS ALTERED, THE ALTERING ENGINEER, ARCHITECT, LANDSCAPE ARCHITECT, OR LAND SURVEYOR SHALL STAMP THE DOCUMENT AND INCLUDE THE NOTATION "ALTERED BY" FOLLOWED BY THEIR SIGNATURE, THE DATE OF SUCH ALTERATION, AND A SPECIFIC DESCRIPTION OF THE ALTERATION.

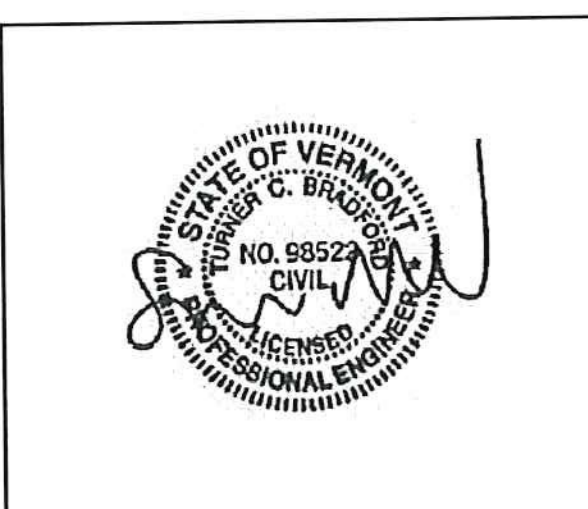

REV	DATE	DESCRIPTION	BY
5	5/3/15	COLD WEATHER MODIFICATIONS	BMB
4	4/29/15	PERMITTING MODIFICATIONS	SKI
3	1/30/15	WW SYSTEM MODIFICATIONS	BMB
2	8/5/14	ANR COMMENTS	TCB
1	4/18/14	ADD 400-SERIES TEST PITS	CH

McFarland Johnson
 53 REGIONAL DRIVE
 CONCORD, NH 03301

NEWPORT STATE AIRPORT
 COVENTRY, VERMONT
 NEWPORT WASTEWATER
 BY SITE 2 - PIPING LAYOUT PLAN 4

SCALE: 1" = 50'	DESIGN: TCB	P2-04 23 OF 36
DRAWN: TCB	PROJECT: 17958.01	
CHECKED: BLS	DATE: JUNE, 2014	