


NO.	BY	DATE	DESCRIPTION

PROJECT NO.
7804

Envirodyne Engineers, Inc.
41 East 42nd St. Suite 1015
New York, NY 10017



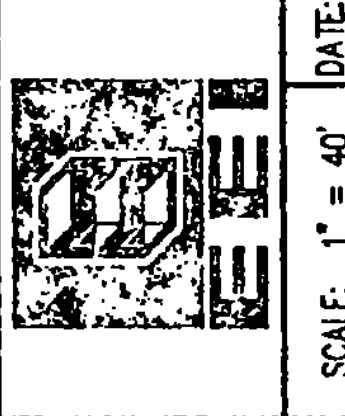


SCALE: 1" = 40'
DATE: AUG. 23, 1993
DESIGNED BY: F.S.
DRAWN BY: D.W.
CHECKED BY: L.G.

RUTLAND STATE AIRPORT
CLARENDON, VERMONT

TAXIWAY E
SITE PLAN

DRAWING NO.
P1
SHEET 7 OF 7

 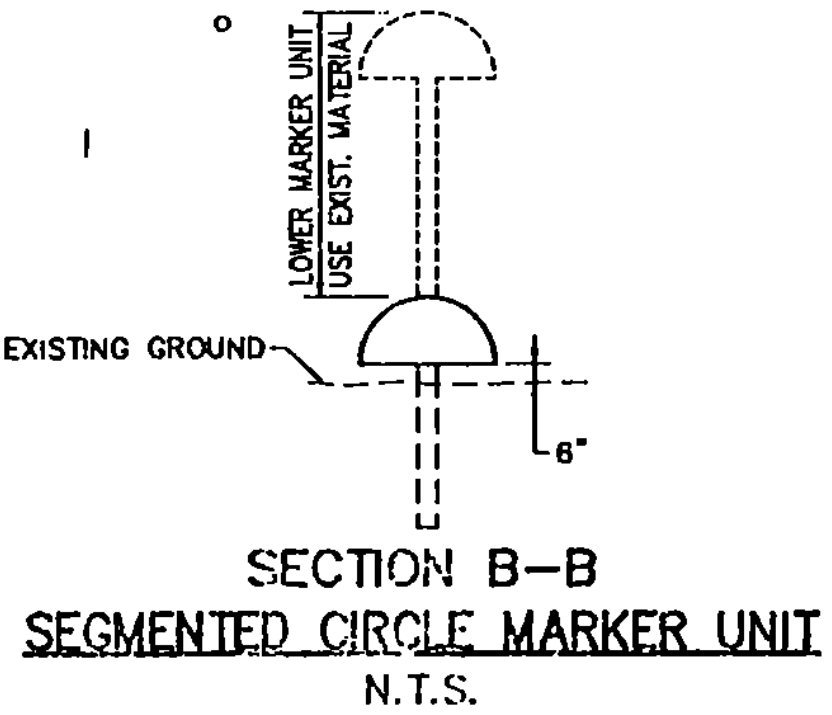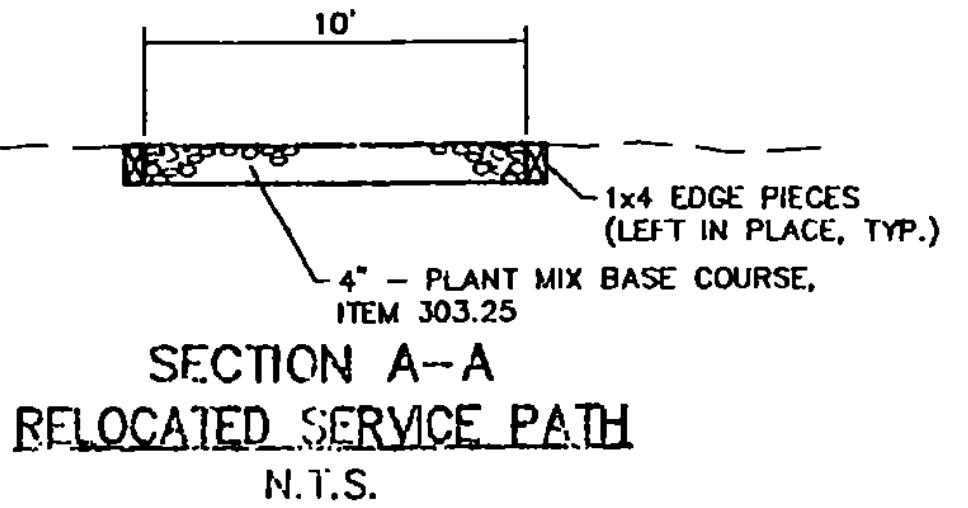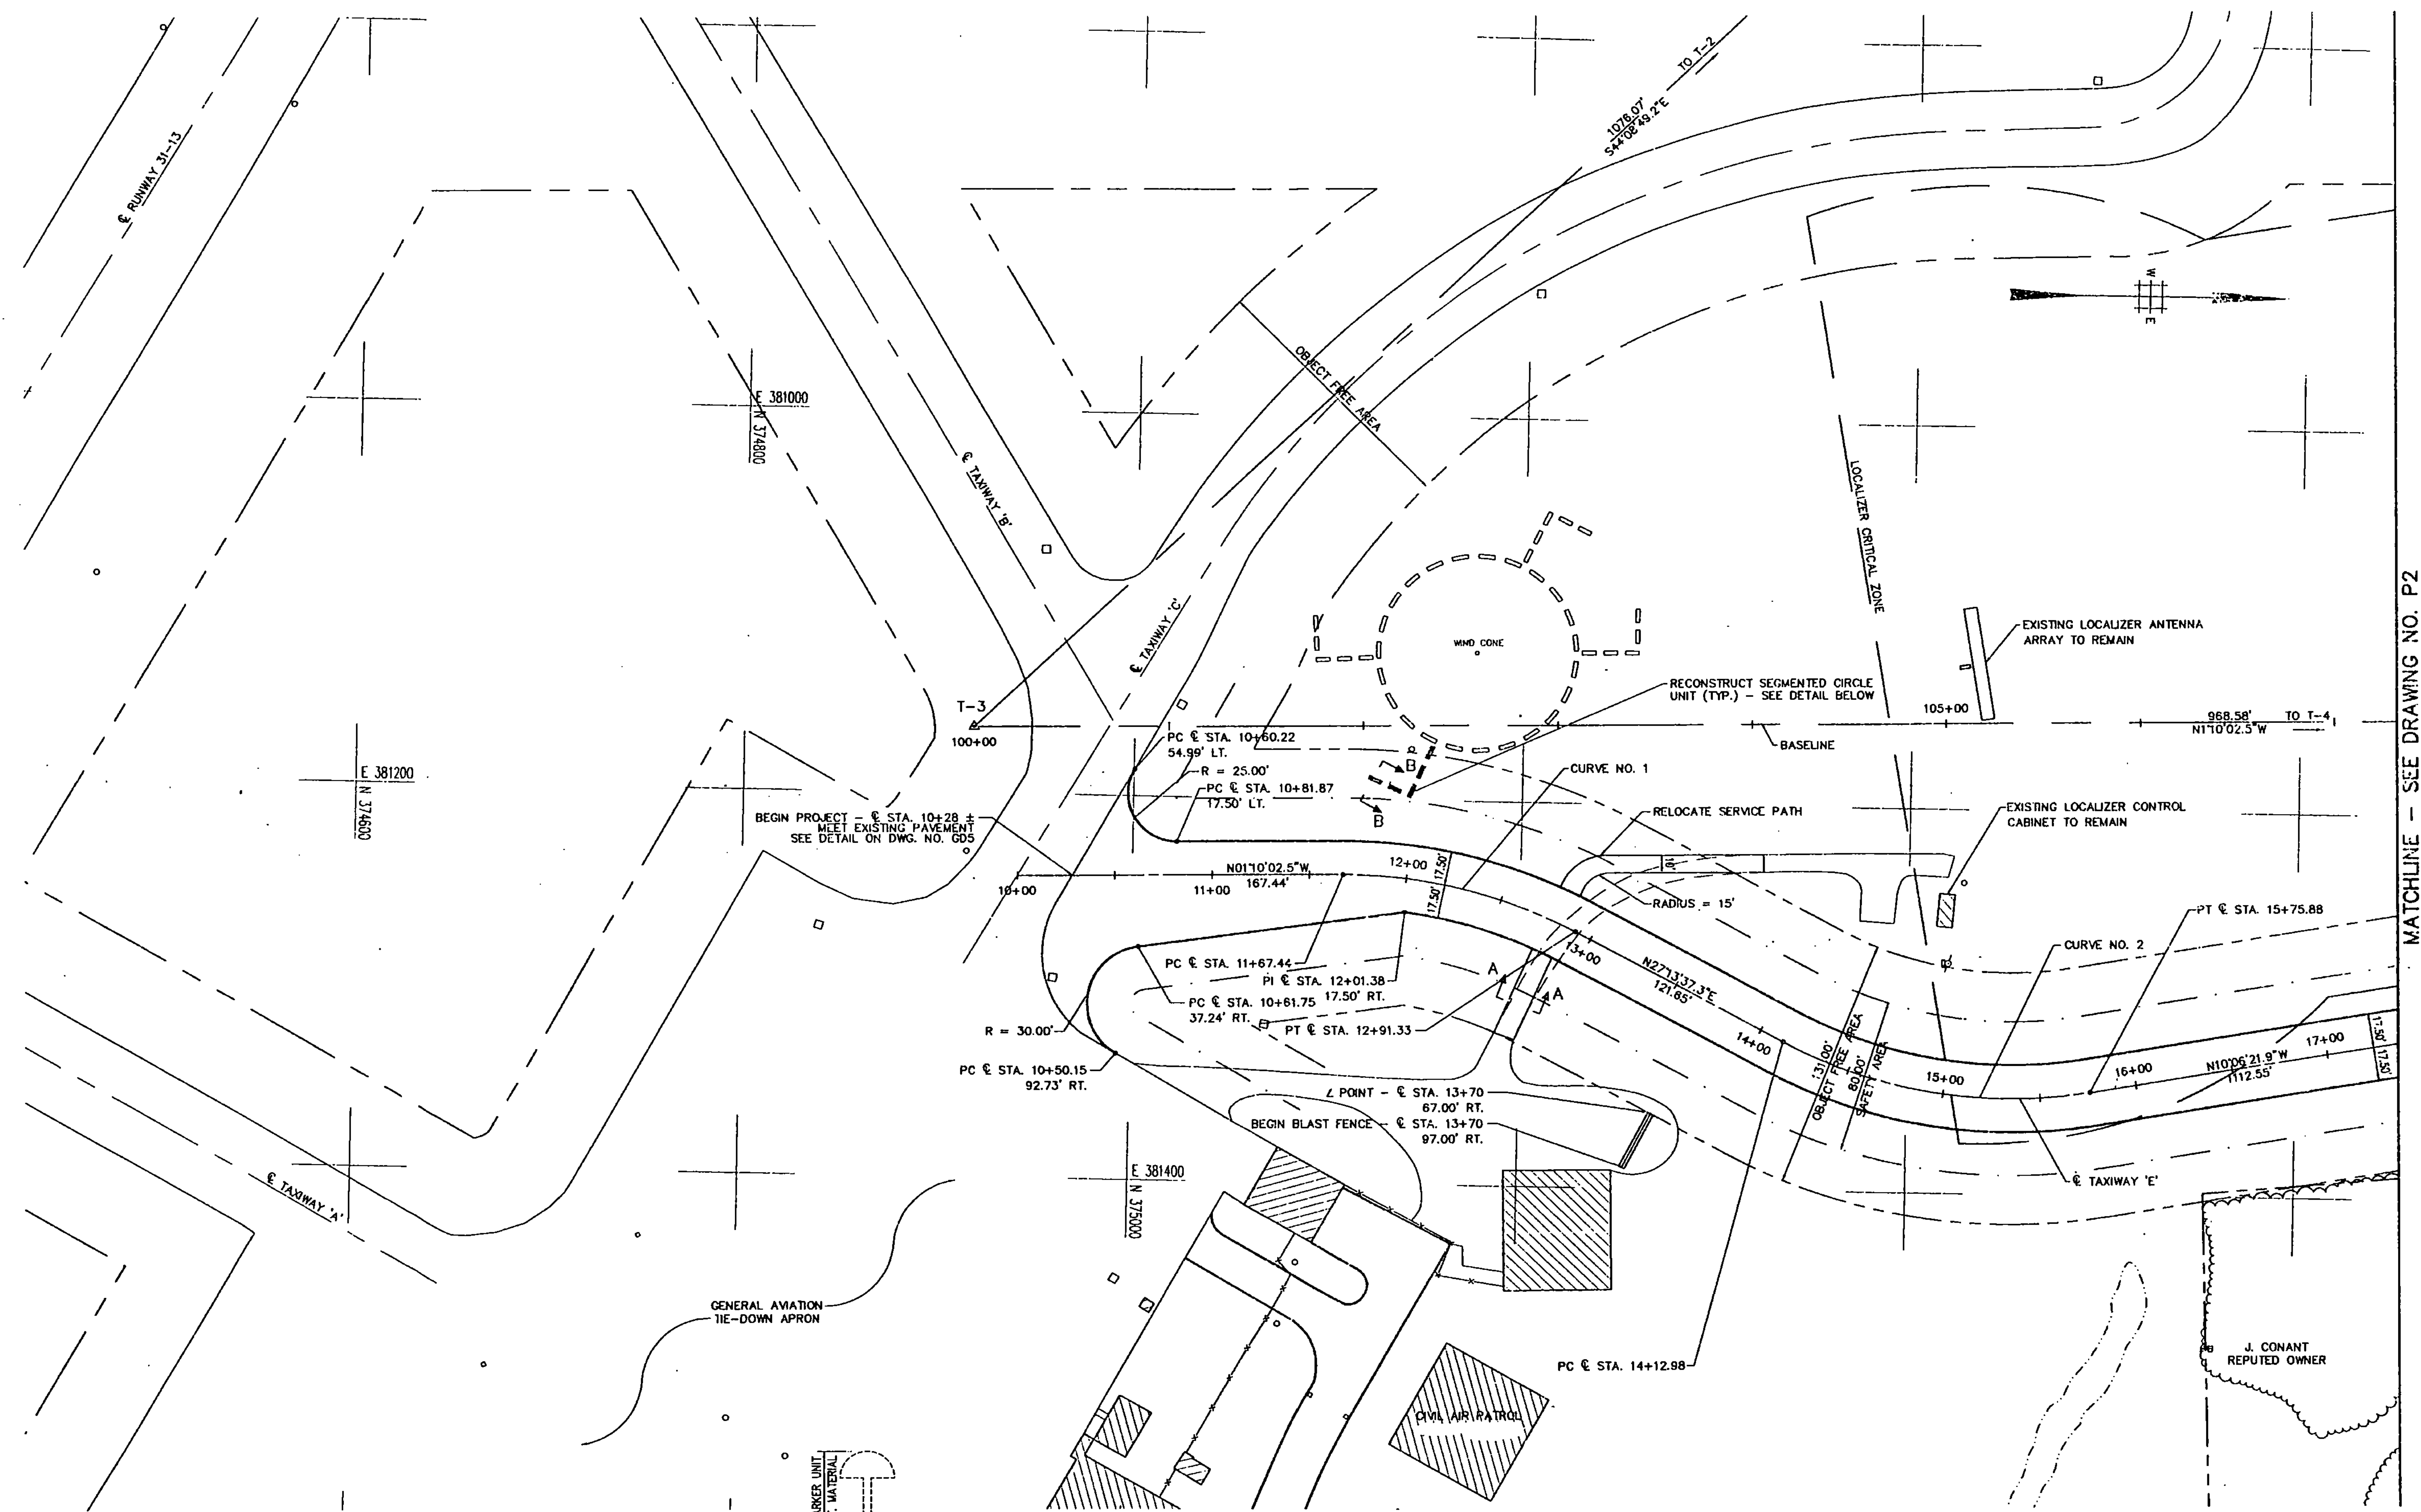


CENTERLINE COORDINATE TABLE

STATION	POINT	NORTH	EAST	STATION	OFFSET
10+00.00	POB	374941.048	381242.581	100+22.01	77.57' RT.
11+07.44	PC1	375108.450	381239.179	101+89.45	77.57' RT.
12+01.33	PT1	375227.922	381266.827	103+08.33	107.65' RT.
14+12.98	PC2	375336.093	381322.484	104+15.35	165.50' RT.
15+75.68	PT2	375494.340	381346.305	105+73.08	192.54' RT.

CENTERLINE CURVE DATA

CURVE	RADIUS	LENGTH	TANGENT	DELTA
1	250.00'	123.89'	63.25'	28°23'39.6"
2	250.00'	162.80'	84.45'	37°19'59.2"



MATCHLINE - SEE DRAWING NO. P2