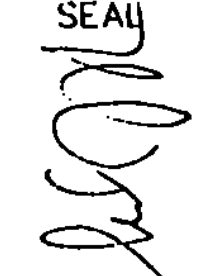


SEAU  


DATE	REVISION	DESCRIPTION
APR 87		
MAY 87		
JUN 87		
JUL 87		
AUG 87		
SEP 87		
OCT 87		
NOV 87		
DEC 87		

PROJECT NO.  
7804

Envirodyne Engineers, Inc.  
 41 East 42nd St. Suite 1015  
 New York, NY 10017


SCALE: 1" = 40'  
 DATE: AUG. 23, 1993  
 DESIGNED BY: F.S.  
 DRAWN BY: D.W.  
 CHECKED BY: L.G.

RUTLAND STATE AIRPORT  
 CLARENDON, VERMONT

TAXIWAY E  
 SITE PLAN

DRAWING NO.  
**P4**

SHEET 10 OF 77

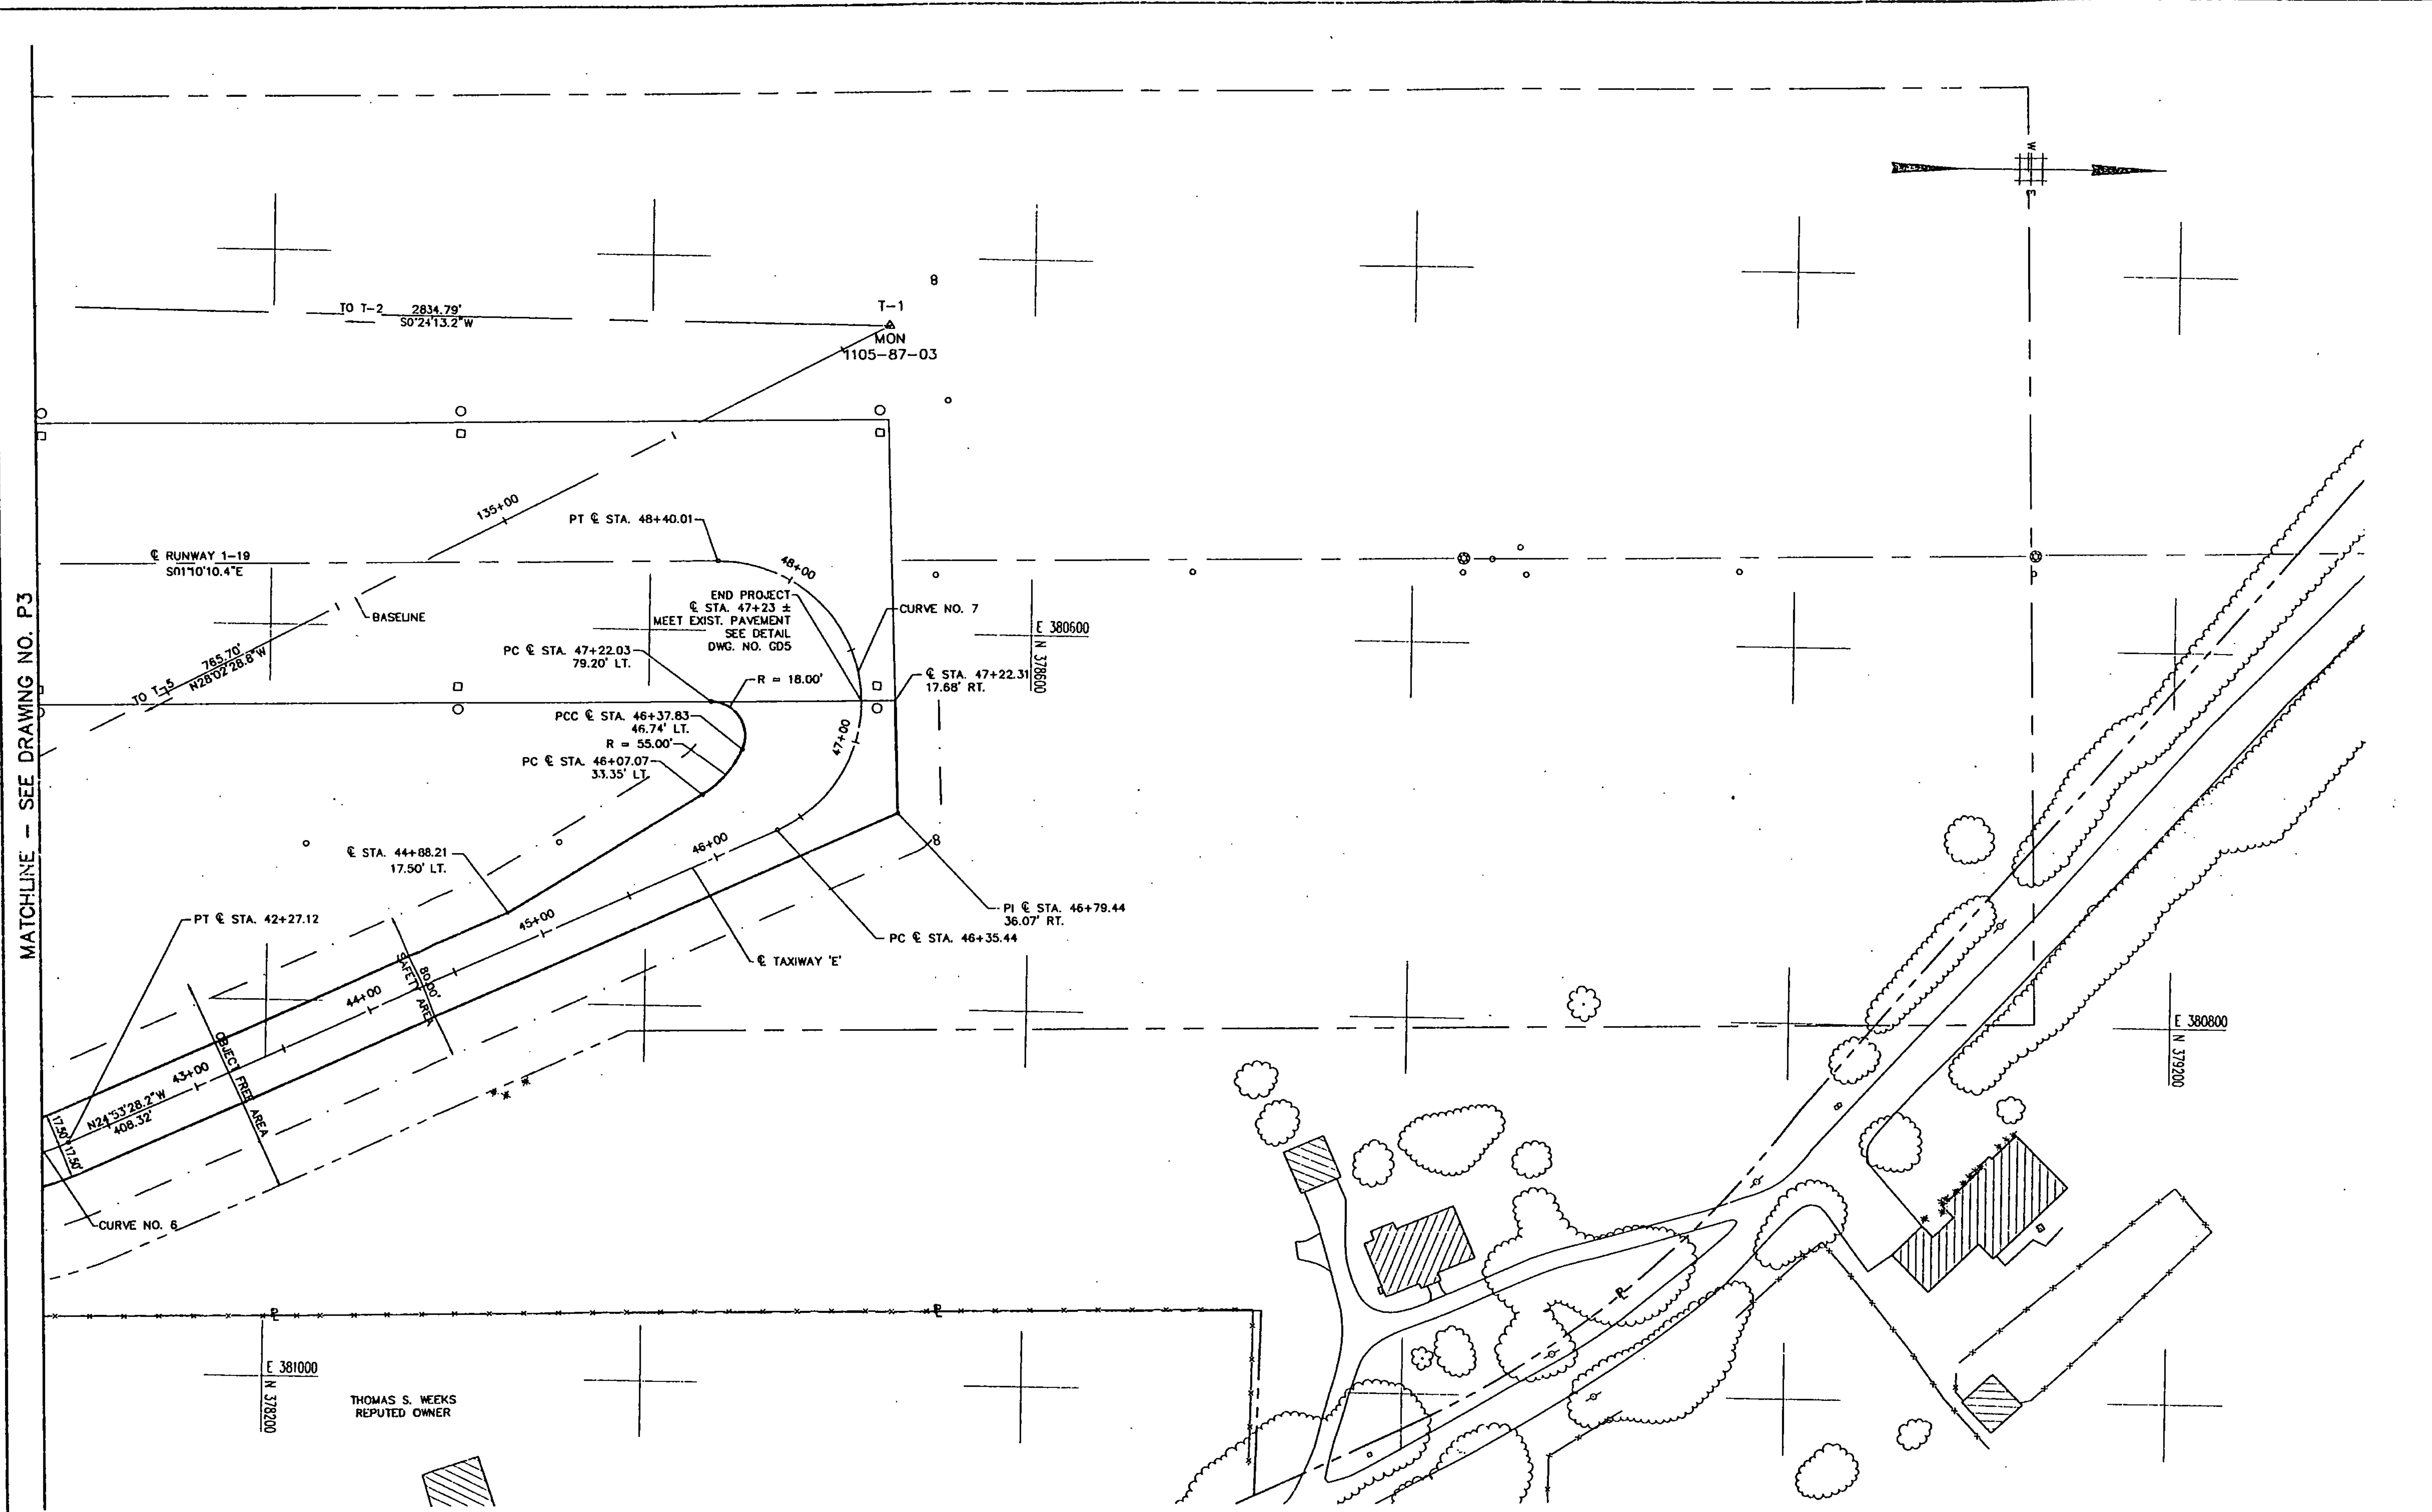


CENTERLINE CURVE DATA

CURVE	RADIUS	LENGTH	TANGENT	DELTA
6	150.00'	38.71'	19.46'	14°47'06.2"
7	75.00'	204.57'	357.11'	156°16'42.2"

CENTERLINE COORDINATE TABLE

CURVE	@ STATION	POINT	NORTH	EAST	@ STATION	OFFSET
8	42+27.12	PT6	378098.057	380877.690	134+44.00	189.48' RT.
		PC7	378468.448	380705.830	135+51.70	211.92' RT.
7	48+40.01	PT7	378435.350	380562.812	135+49.72	70.13' RT.

 

MATCHLINE - SEE DRAWING NO. P3

C:\Users\jessica\OneDrive\Documents\109\_Aug 23 16 24:16 1993