



MATCHLINE - SEE DRAWING NO. GD1

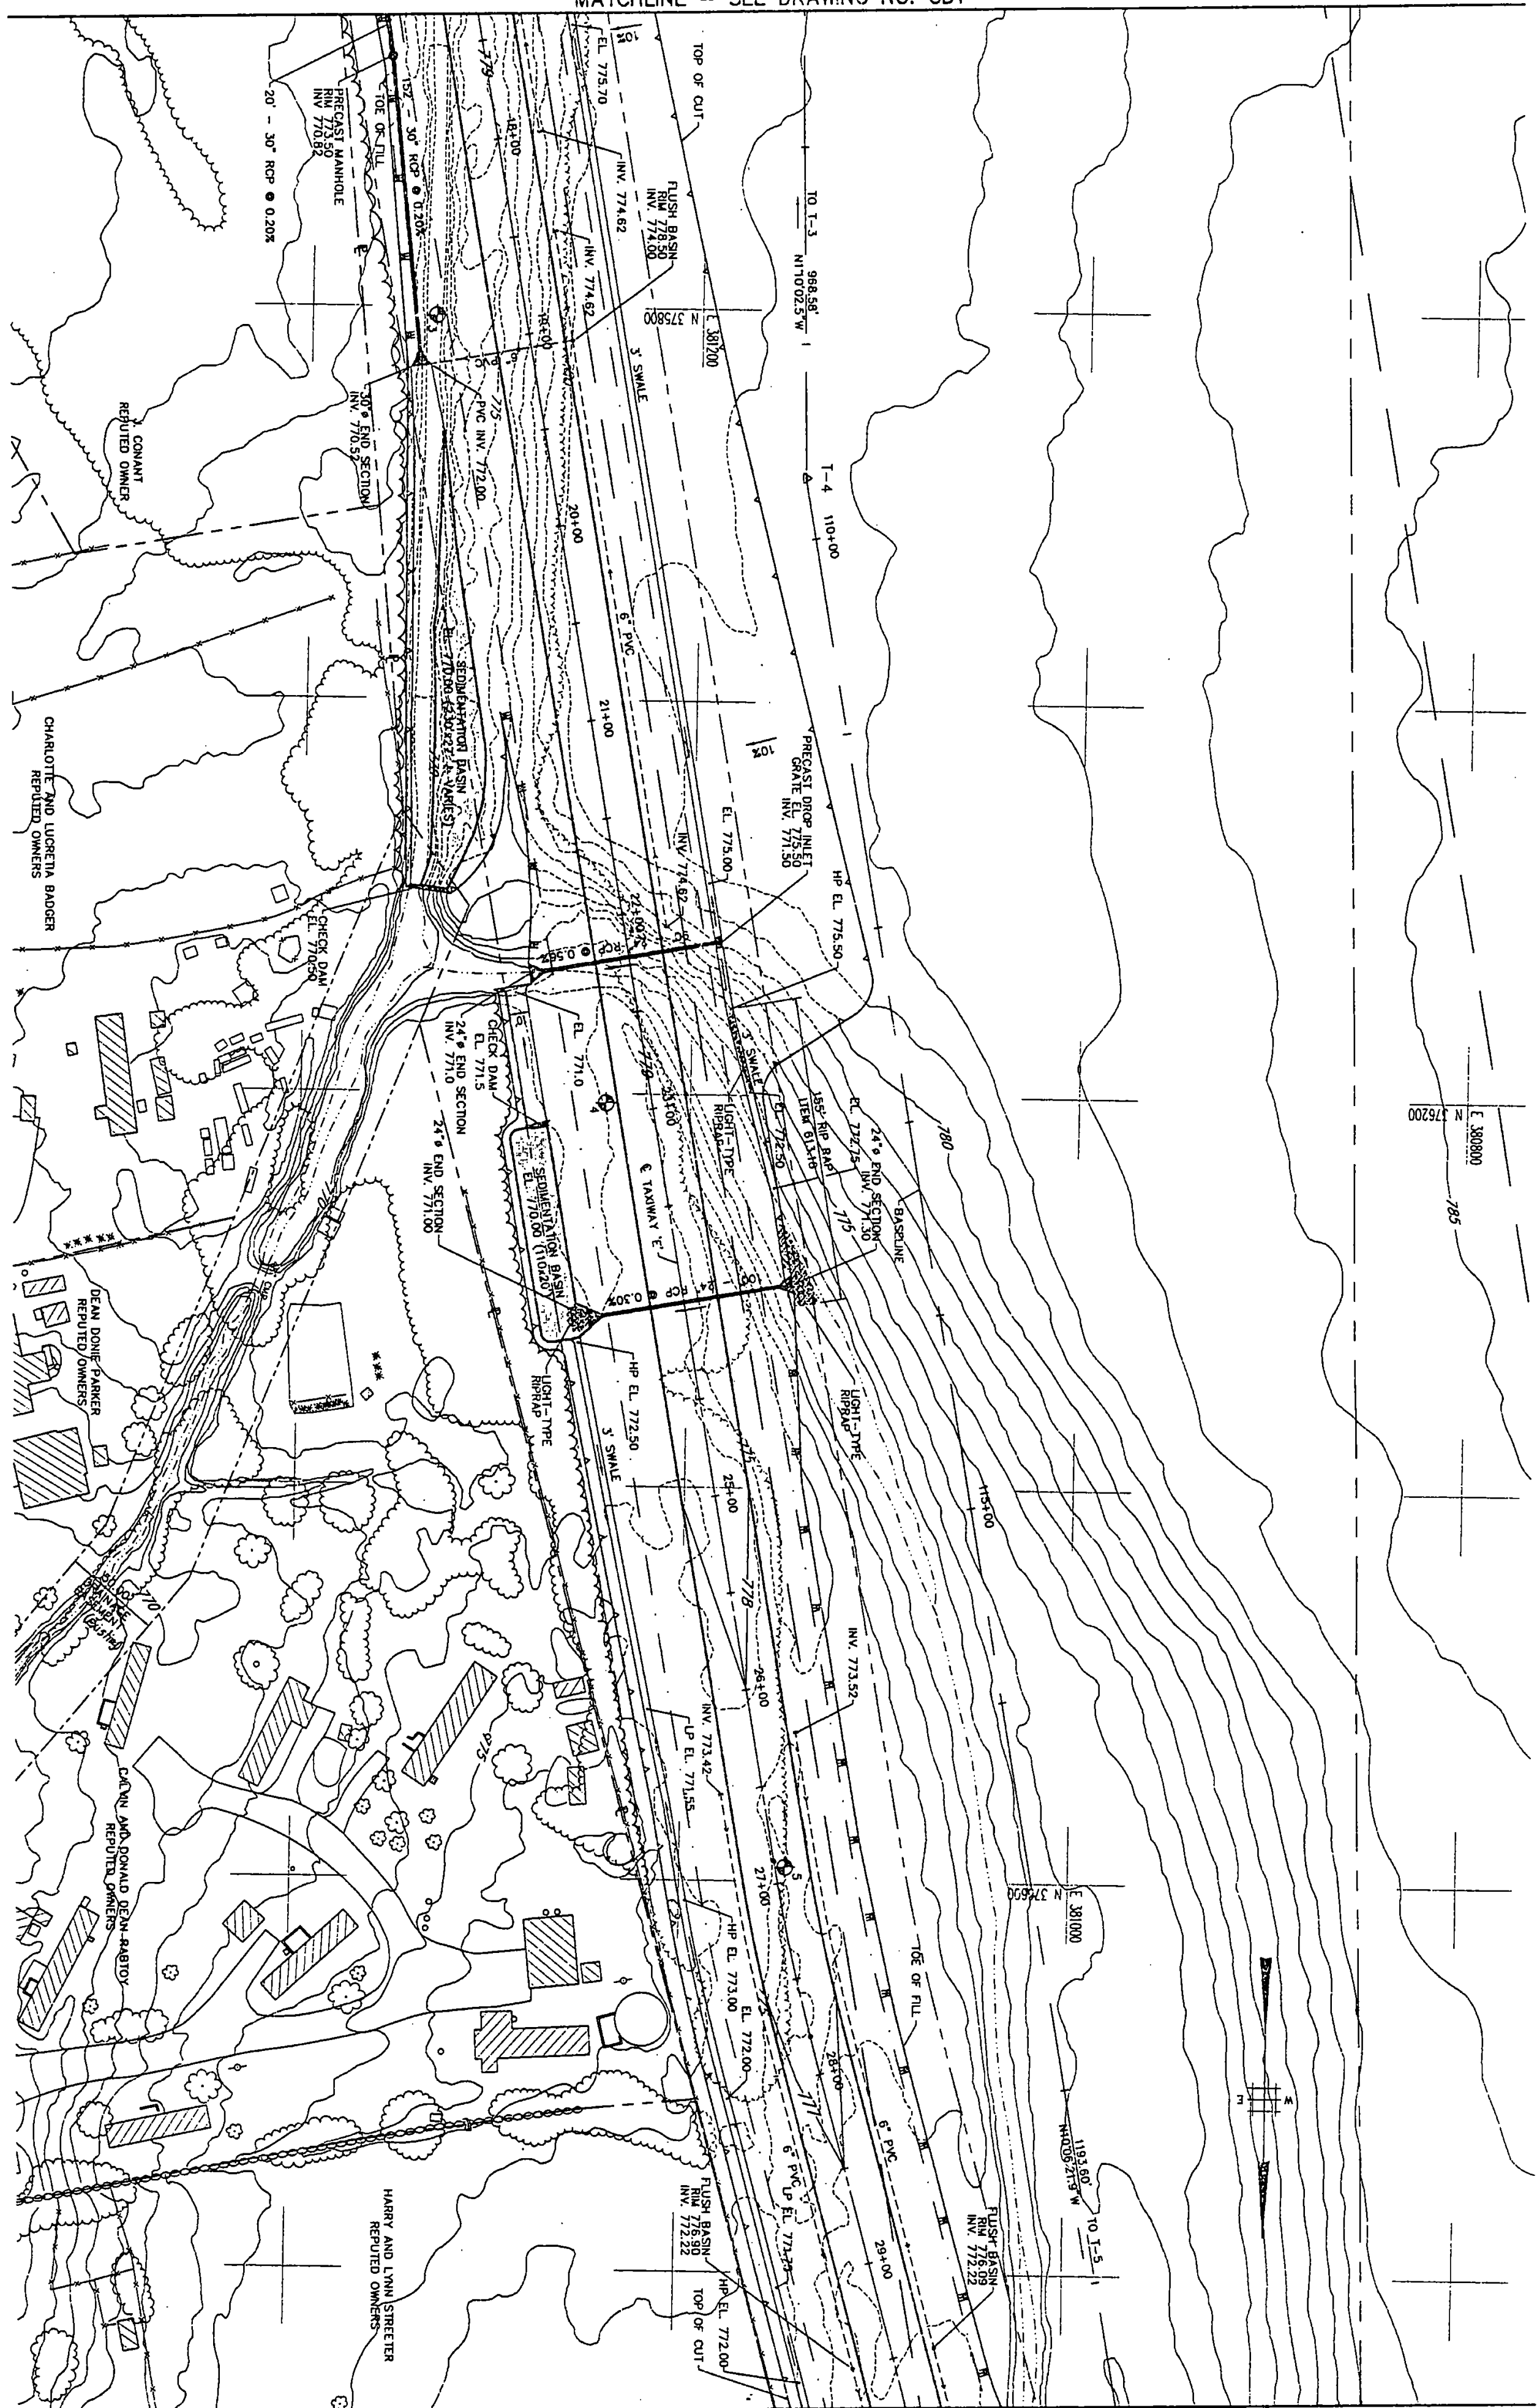

MATCHLINE - SEE DRAWING NO. GD3

- NOTES:
1. ALL PVC UNDERDRAINS ARE PERFORATED EXCEPT FOR TRANSVERSE CARRIED PIPES
 2. FOR TABLE OF UNDERDRAINS, SEE DWG. NO. DD1.
 3. FOR DRAINAGE STRUCTURE DETAILS, SEE DWG. NO. DD1.



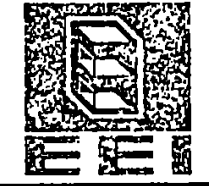GD2 DRAWING NO. SHEET 12 OF 17	RUTLAND STATE AIRPORT CLARENDON, VERMONT TAXIWAY E GRADING AND DRAINAGE PLAN	 Envirodyne Engineers, Inc. 41 East 42nd St. Suite 1015 New York, NY 10017	PROJECT NO. 7804	DATE: AUG. 23, 1993 DESIGNED BY: F.S. DRAWN BY: D.W. CHECKED BY: L.G.	REVISION DESCRIPTION DATE	DATE BY DATE
	SCALE: 1" = 40'			SEE 4		