
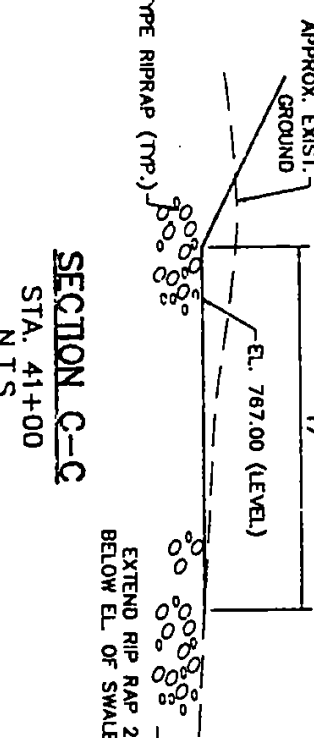
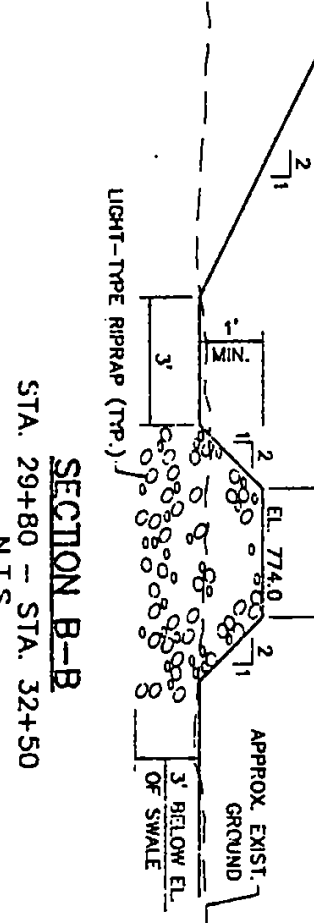
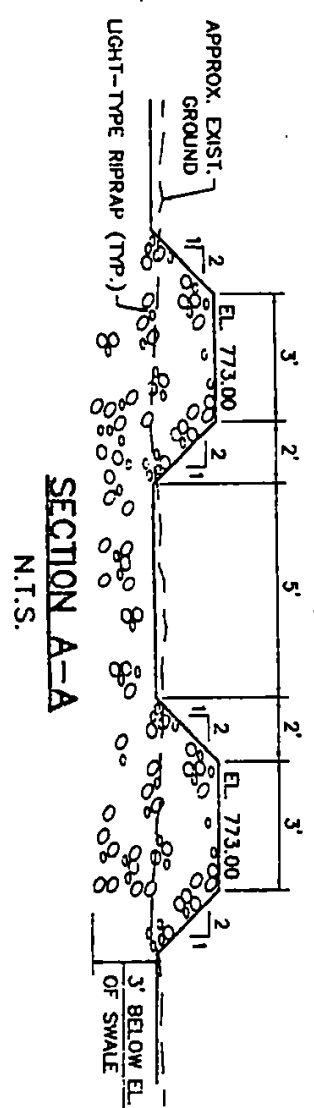


MATCHLINE - SEE DRAWING NO. GD2

MATCHLINE - SEE DRAWING NO. GD4

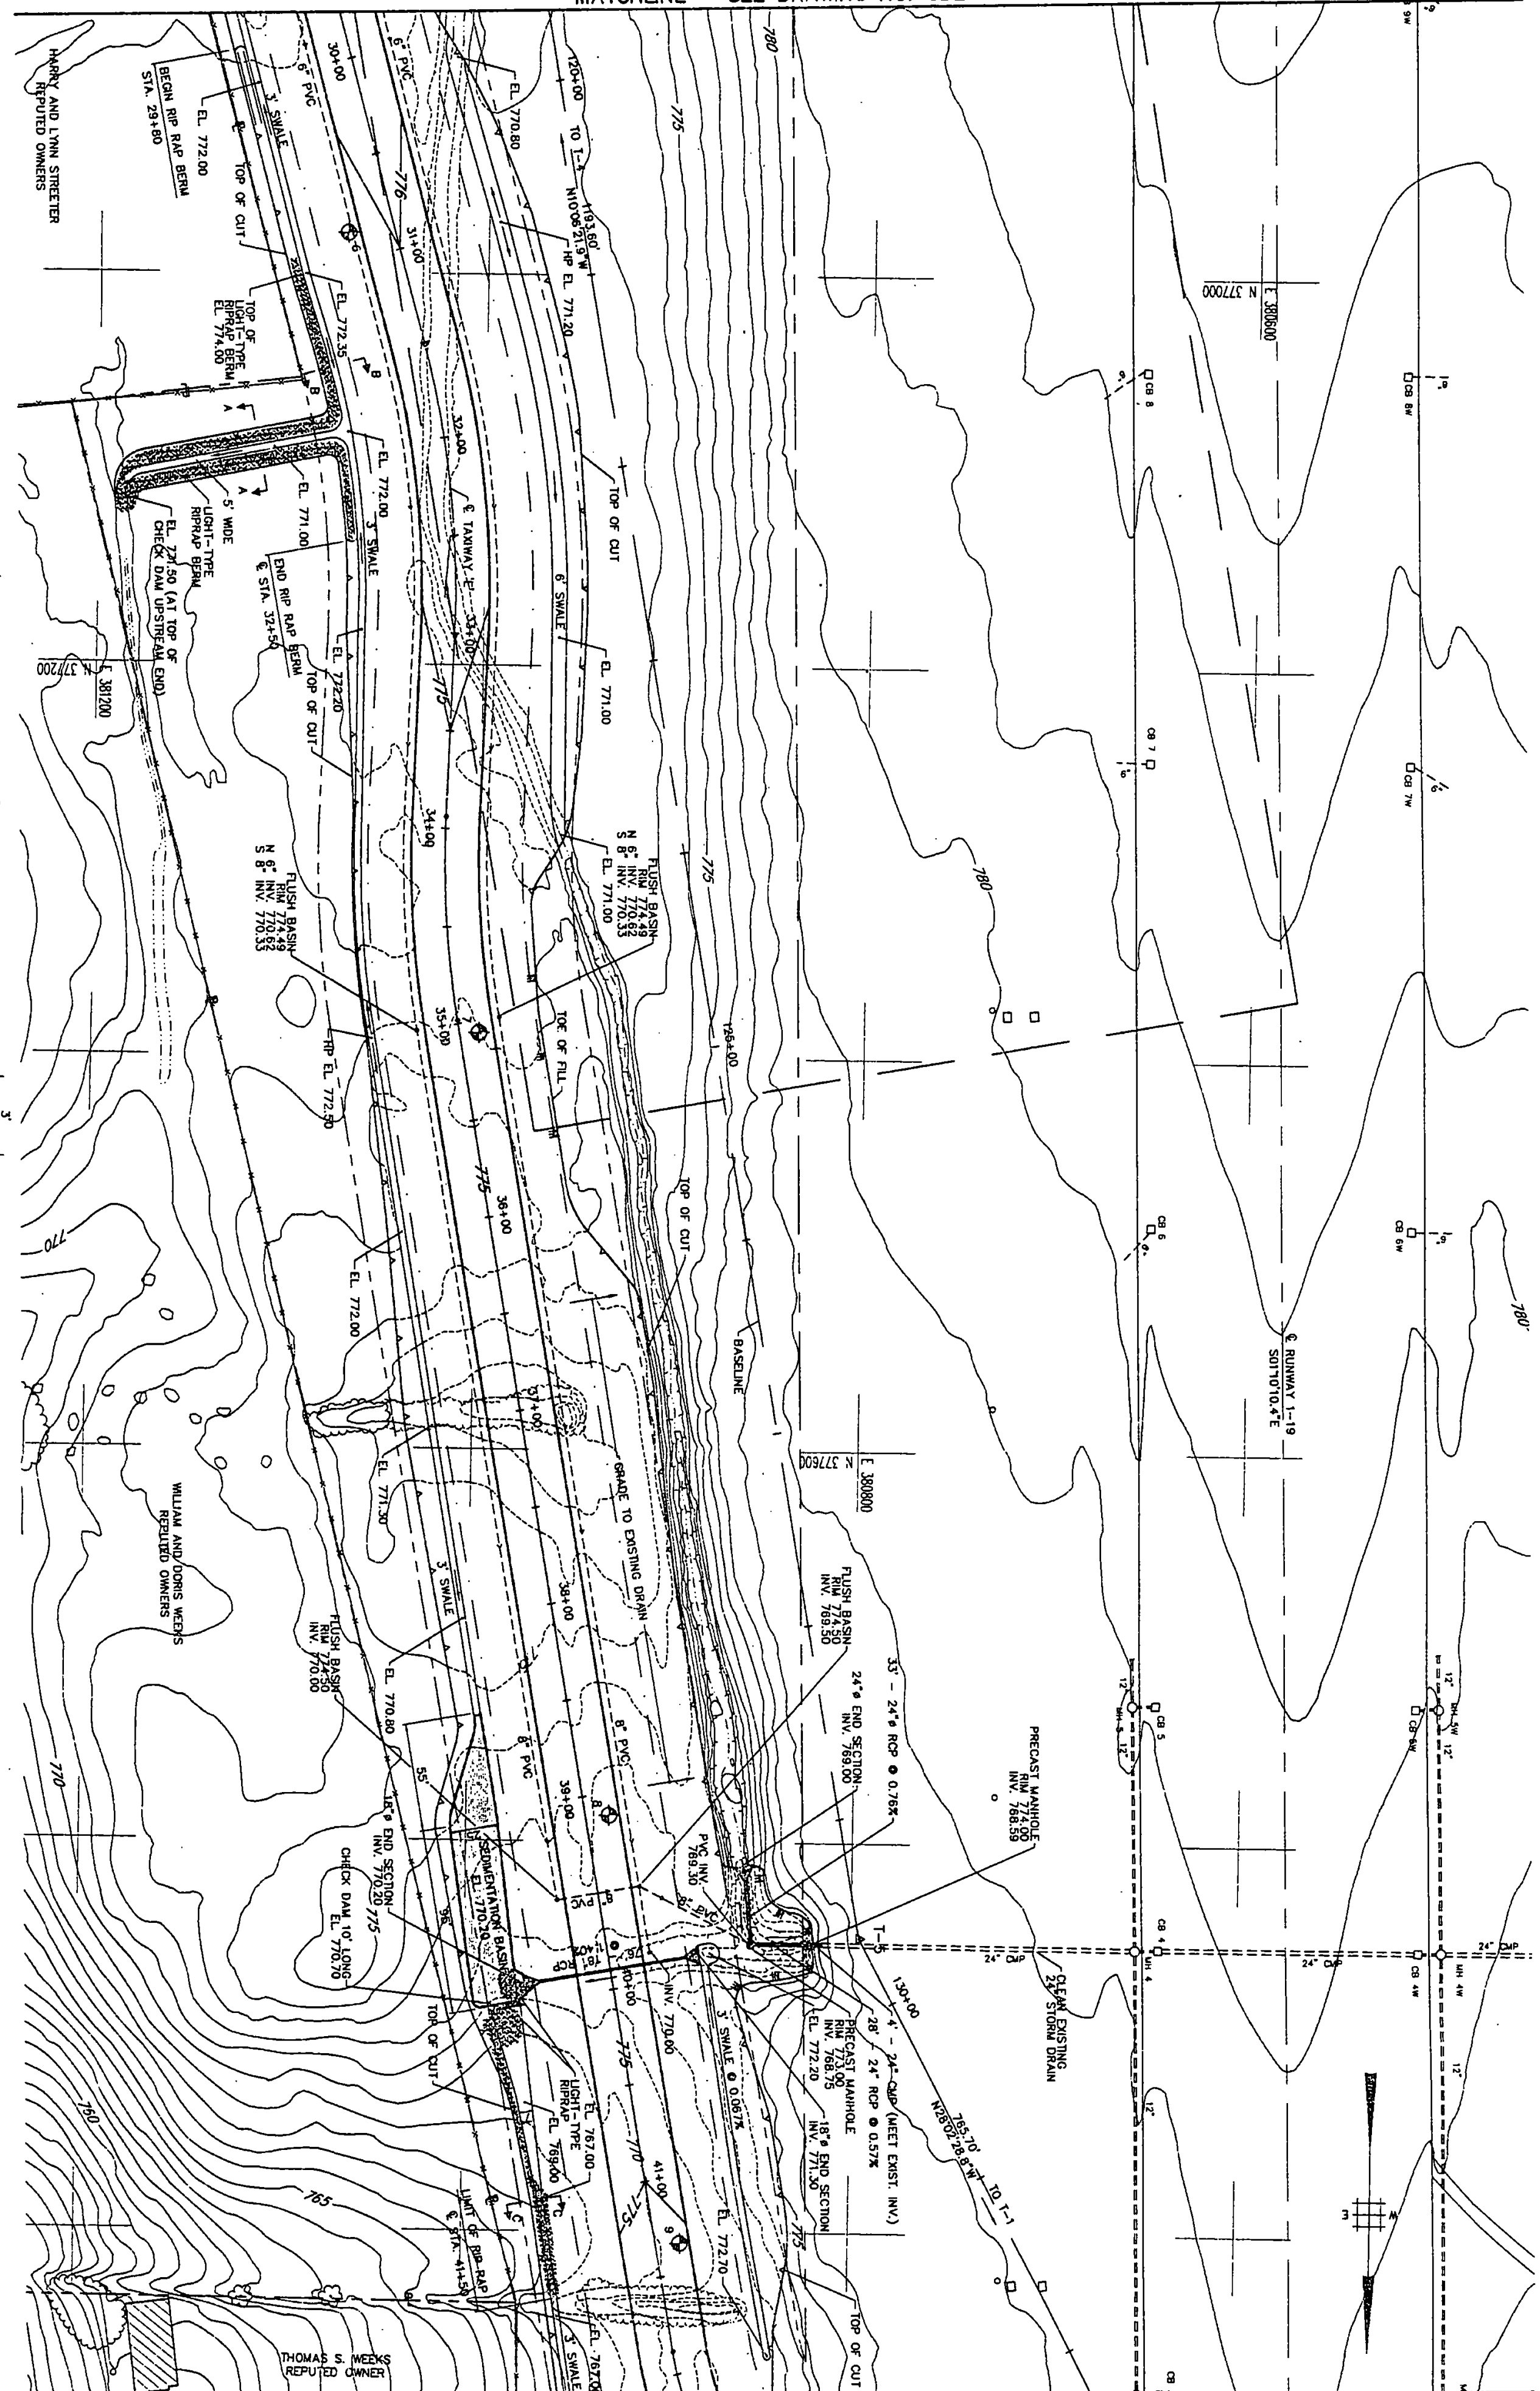

- NOTES
1. ALL P.V.C. UNDERDRAINS ARE PERFORMED EXCEPT FOR TRANSVERSE CORNER PIPES.
  2. FOR TABLE OF UNDERDRAINS, SEE DWG. NO. 001.
  3. FOR DRAINAGE STRUCTURE DETAILS, SEE DWG. NO. 001.

	RUTLAND STATE AIRPORT CLARENDON, VERMONT  TAXIWAY E  <b>GRADING AND DRAINAGE PLAN</b>	Envirodyne Engineers, Inc. 41 East 42nd St. Suite 1015 New York, NY 10017	PROJECT NO. 7804	SCALE: 1" = 40' DATE: AUG. 23, 1993	DESIGNED BY: F.S. DRAWN BY: D.W. CHECKED BY: L.G.	REVISION DESCRIPTION DRAWN BY CHECKED BY DATE	SEAL 
	DRAWING NO. SHEET 13 OF 17						