

REV.	DATE	DESCRIPTION


Job No. 140112.00
File No. 140112.00

RUTLAND STATE AIRPORT
CLARENDON, VERMONT

ELECTRICAL PLANS
VASI MOUNTING DETAILS

Greiner, Inc.
3 MARCUS BOULEVARD
ALBANY, NEW YORK

Designed by: C. U'neko	2/87
Drawn by: M. Saccala	3/87
Checked by: C. U'neko	5/87
Approved by: M. Chabrol	6/87
Social:	HOR - AS NOTED VERT. - NONE
Date:	6/8/87
Sheet 34 Of 66	
Sheet No.	34

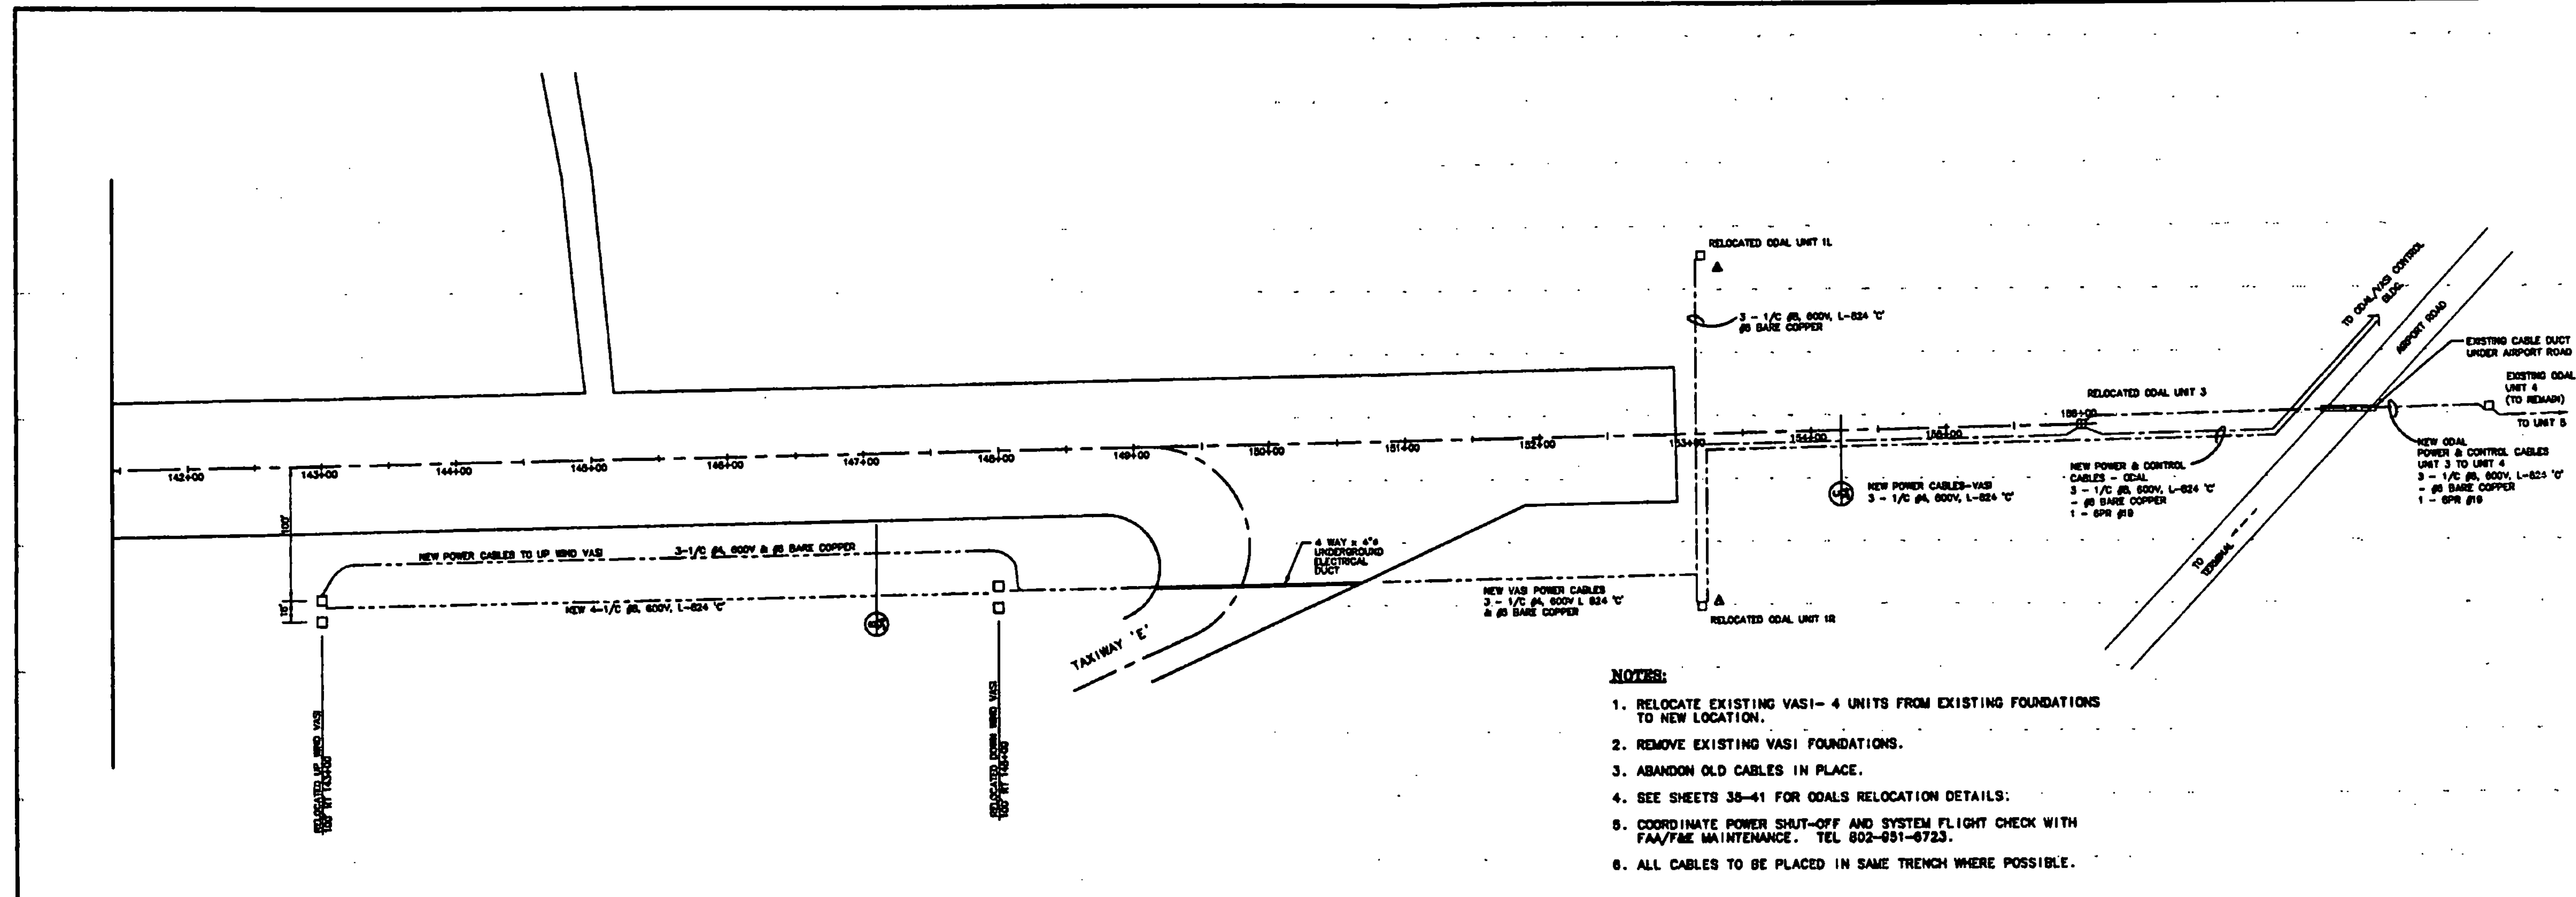

- NOTES:**
1. RELOCATE EXISTING VASI- 4 UNITS FROM EXISTING FOUNDATIONS TO NEW LOCATION.
 2. REMOVE EXISTING VASI FOUNDATIONS.
 3. ABANDON OLD CABLES IN PLACE.
 4. SEE SHEETS 35-41 FOR ODALS RELOCATION DETAILS.
 5. COORDINATE POWER SHUT-OFF AND SYSTEM FLIGHT CHECK WITH FAA/F&E MAINTENANCE. TEL 802-931-6723.
 6. ALL CABLES TO BE PLACED IN SAME TRENCH WHERE POSSIBLE.

ODAL & VASI - CABLES
SCALE: 1"=60'

