



1-4
94 Co White

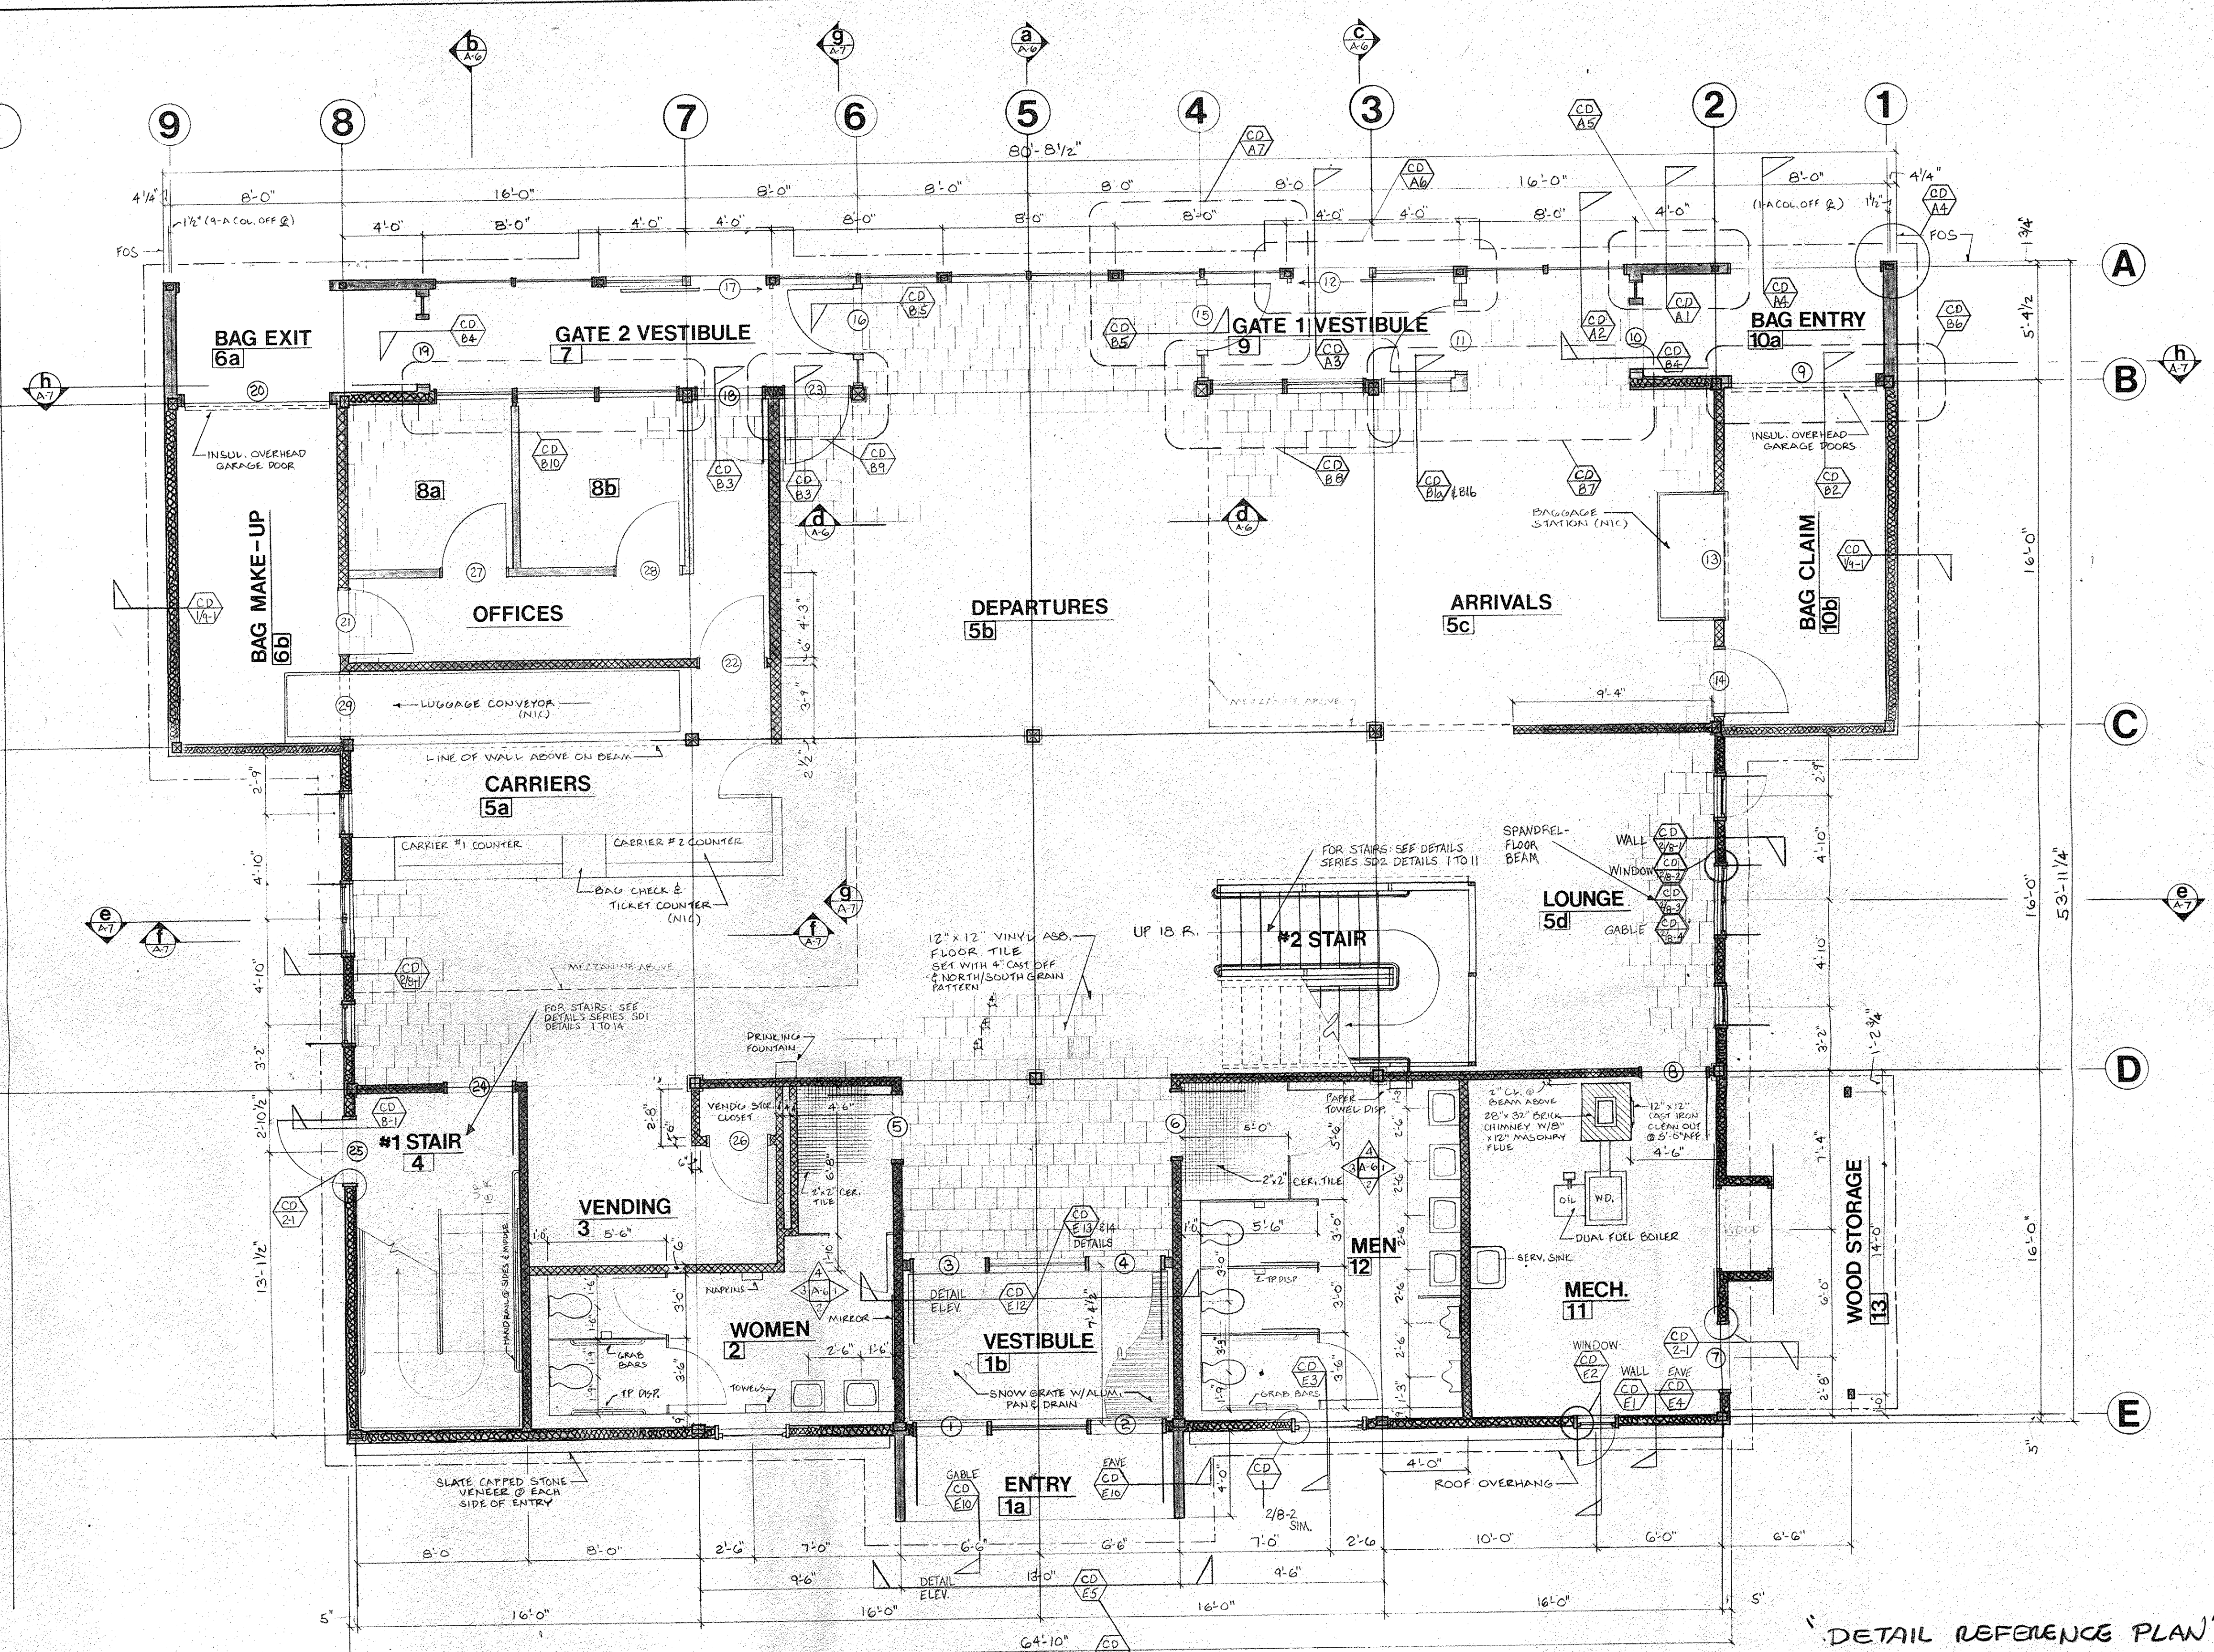

"DETAIL REFERENCE PLAN"

STATE OF VERMONT			
DIVISION OF STATE BUILDINGS			
AGENCY OF ADMINISTRATION			
MONTPELIER, VERMONT			
RUTLAND TERMINAL BUILDING AIR 23-2024			
FIRST FLOOR PLAN			
RUTLAND STATE AIRPORT			
CLARENDON, VERMONT			
DATE: 6/8/84	SCALE: 1/2" = 1'-0"	REVISIONS:	DWG. NO. A-2Ref.
DRAWN BY: JTB	APPROVED BY: RJA FOR DGB		5 OF 19

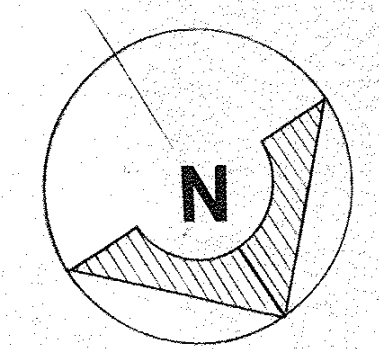

8/10/84