




**HEAT TRACE SITE PLAN**  
SCALE: 1"=20'-0"

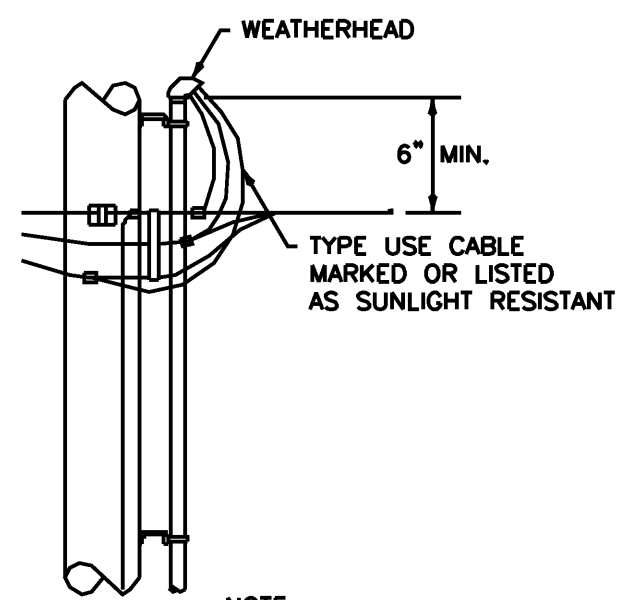

NOTE:  
SERVICE TO HEAT TRACE IS 100 AMPERES NOMINAL AT 240 / 120 VOLTS 1Ø

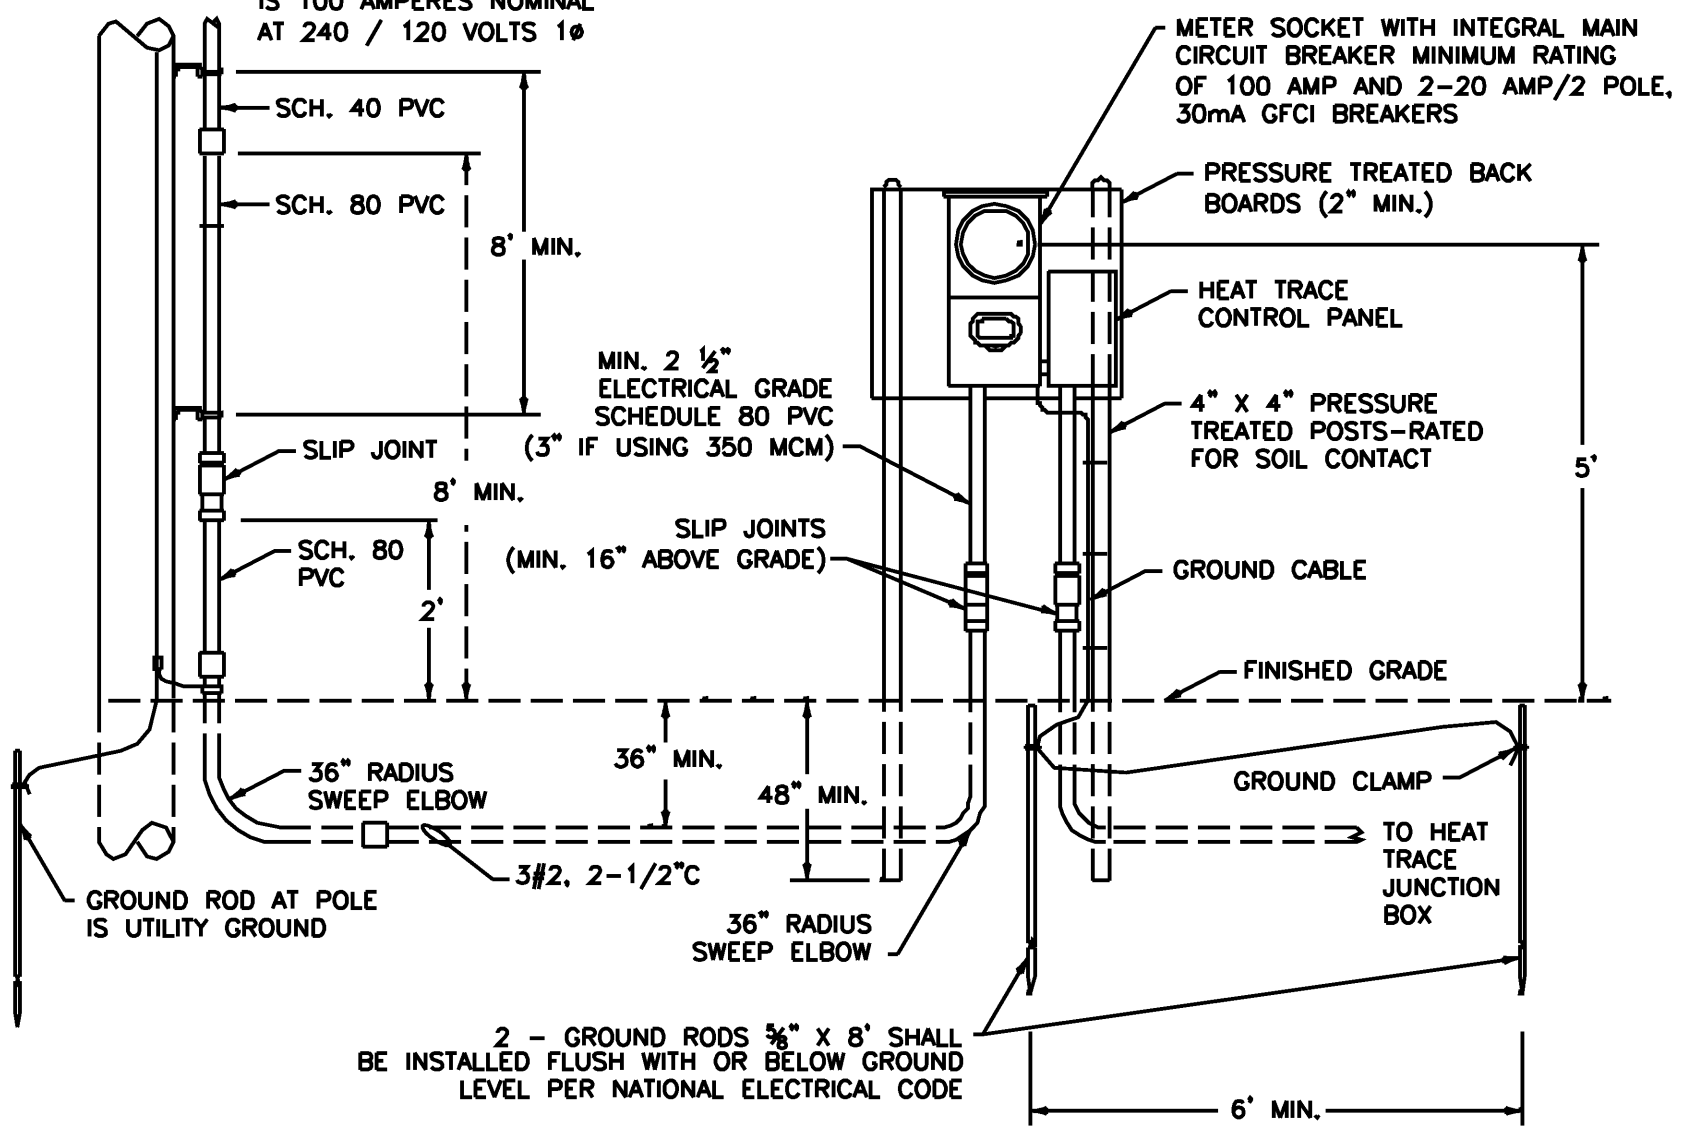

**CULVERT HEAT TRACE SERVICE ELEVATION**  
NOT TO SCALE

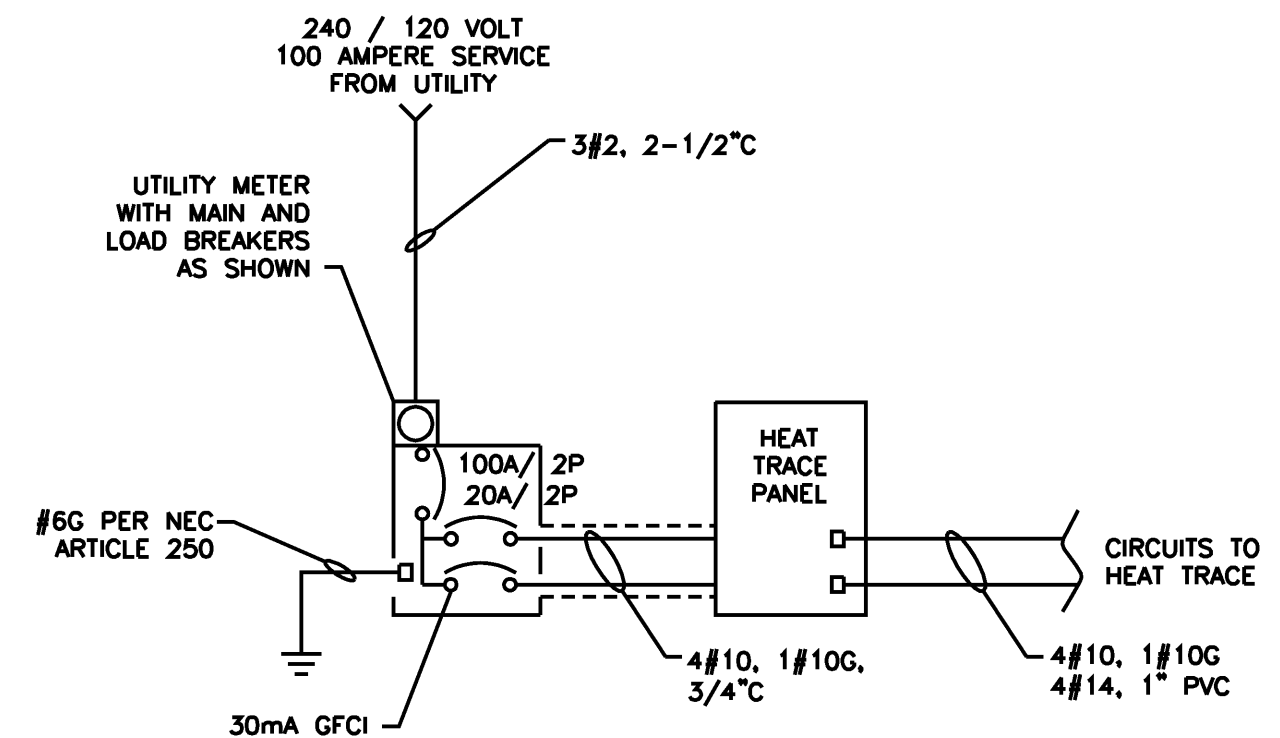

**CULVERT HEAT TRACE ONE-LINE DIAGRAM**  
NOT TO SCALE



PROJECT NAME:	HARTFORD REST AREAS
PROJECT NUMBER:	IM BLDG(10)
FILE NAME:	...u04c026p1t-Elec_Details III.dgn
PROJECT LEADER:	JTM
DESIGNED BY:	WHH
ELECTRICAL DETAILS III	
DATE:	5/19/2008
DRAWN BY:	JSK
CHECKED BY:	JTM
SHEET	56 OF 70