


- NOTES**
- 1) SEE DRAINAGE PLANS FOR LOCATION OF PROPOSED DRAINAGE FACILITIES.
  - 2) SEE CONSTRUCTION PLANS FOR ADDITIONAL PROPOSED FACILITIES.

**NEW WATER MAIN**  
 W2 2+660.000 LT ~ 2+830.000 LT  
 NEW 300 mm PIPE

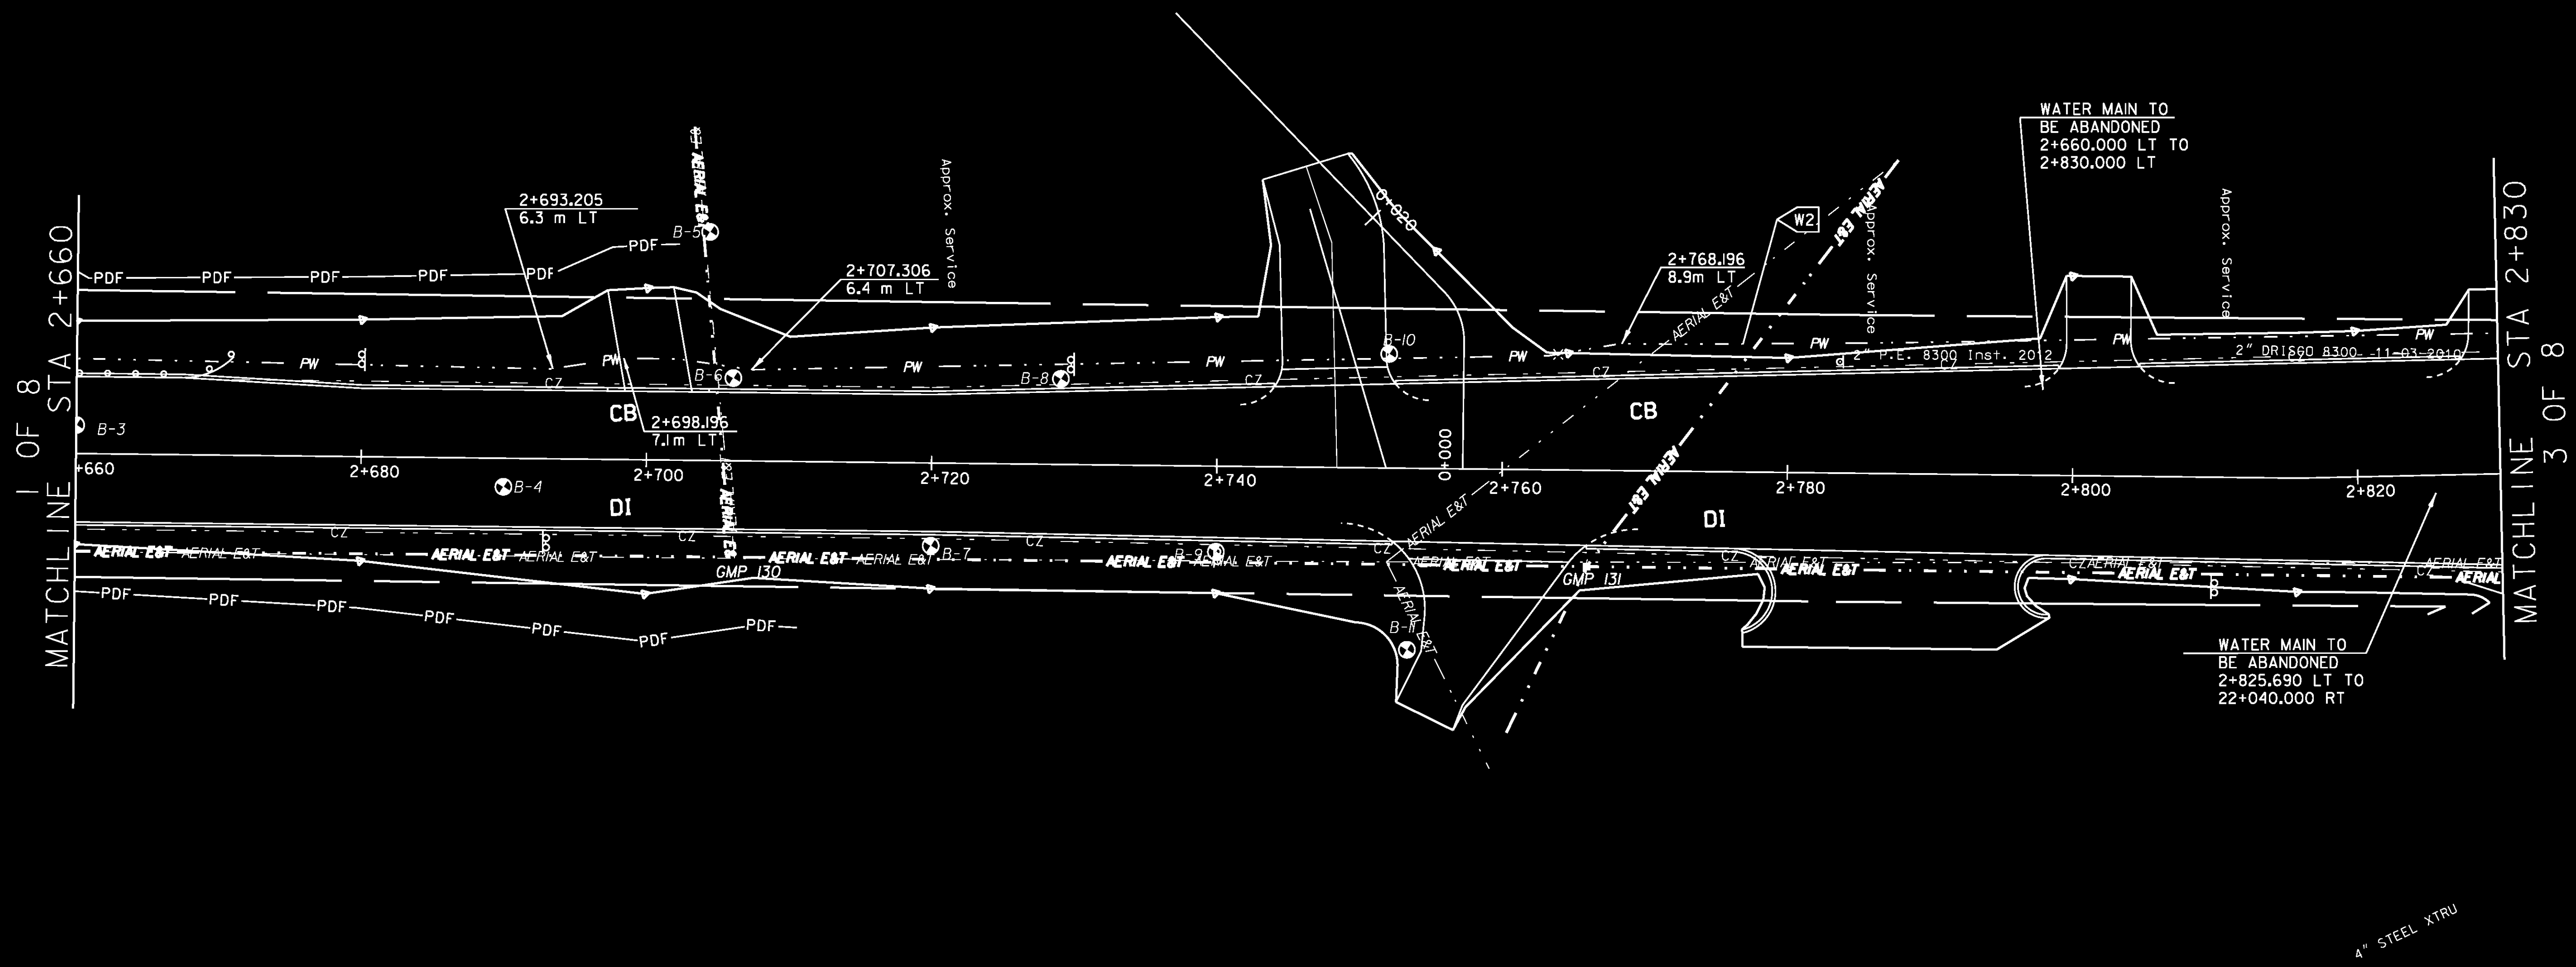

PROJECT NAME:	COLCHESTER	PLOT DATE:	21-FEB-2013
PROJECT NUMBER:	STP 5600(9)S	DRAWN BY:	T. KELLEY
FILE NAME:	r97d206UTL2.dgn	CHECKED BY:	D. BURHANS
PROJECT LEADER:	J. SCHULTZ	UTILITY PLAN SHEET	2 OF 8
DESIGNED BY:	D. BRYANT	SHEET	42 OF 74