




THINNING AND TRIMMING
 STA. 1+00.0, 47.0' LT. - 20.0' RT. TO
 STA. 4+10.0, 77.0' LT. - 10.0' RT.

REMOVE SIGNS
 AS SHOWN - 3

4" DURABLE WHITE LINES
 STA. 1+03, LT. & RT. - STA. 3+84, LT. & RT.

DURABLE LETTERS AND SYMBOLS
 STA. 2+01.8, 19.6' LT. - " & "
 STA. 2+16.0, 19.6' LT. - " & "

SNOW FENCE (MOD.-PDF)
 STA. 1+00.00, RT. - STA. 4+11.00, LT.

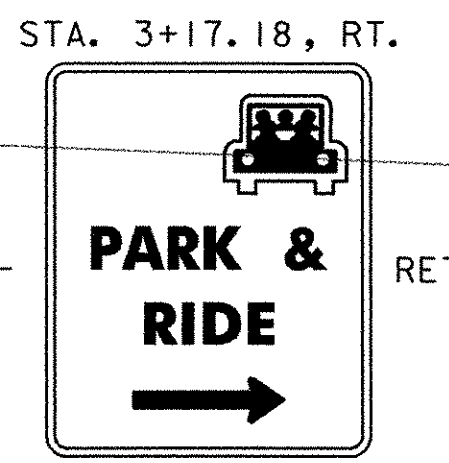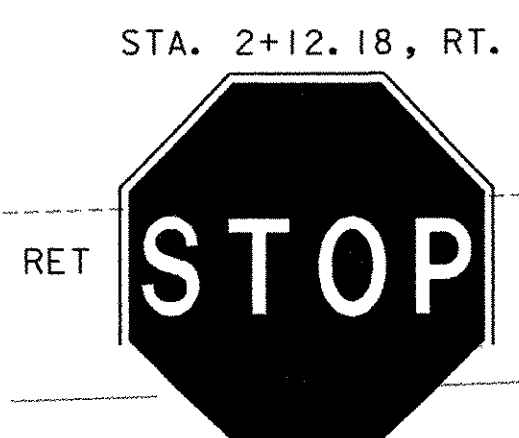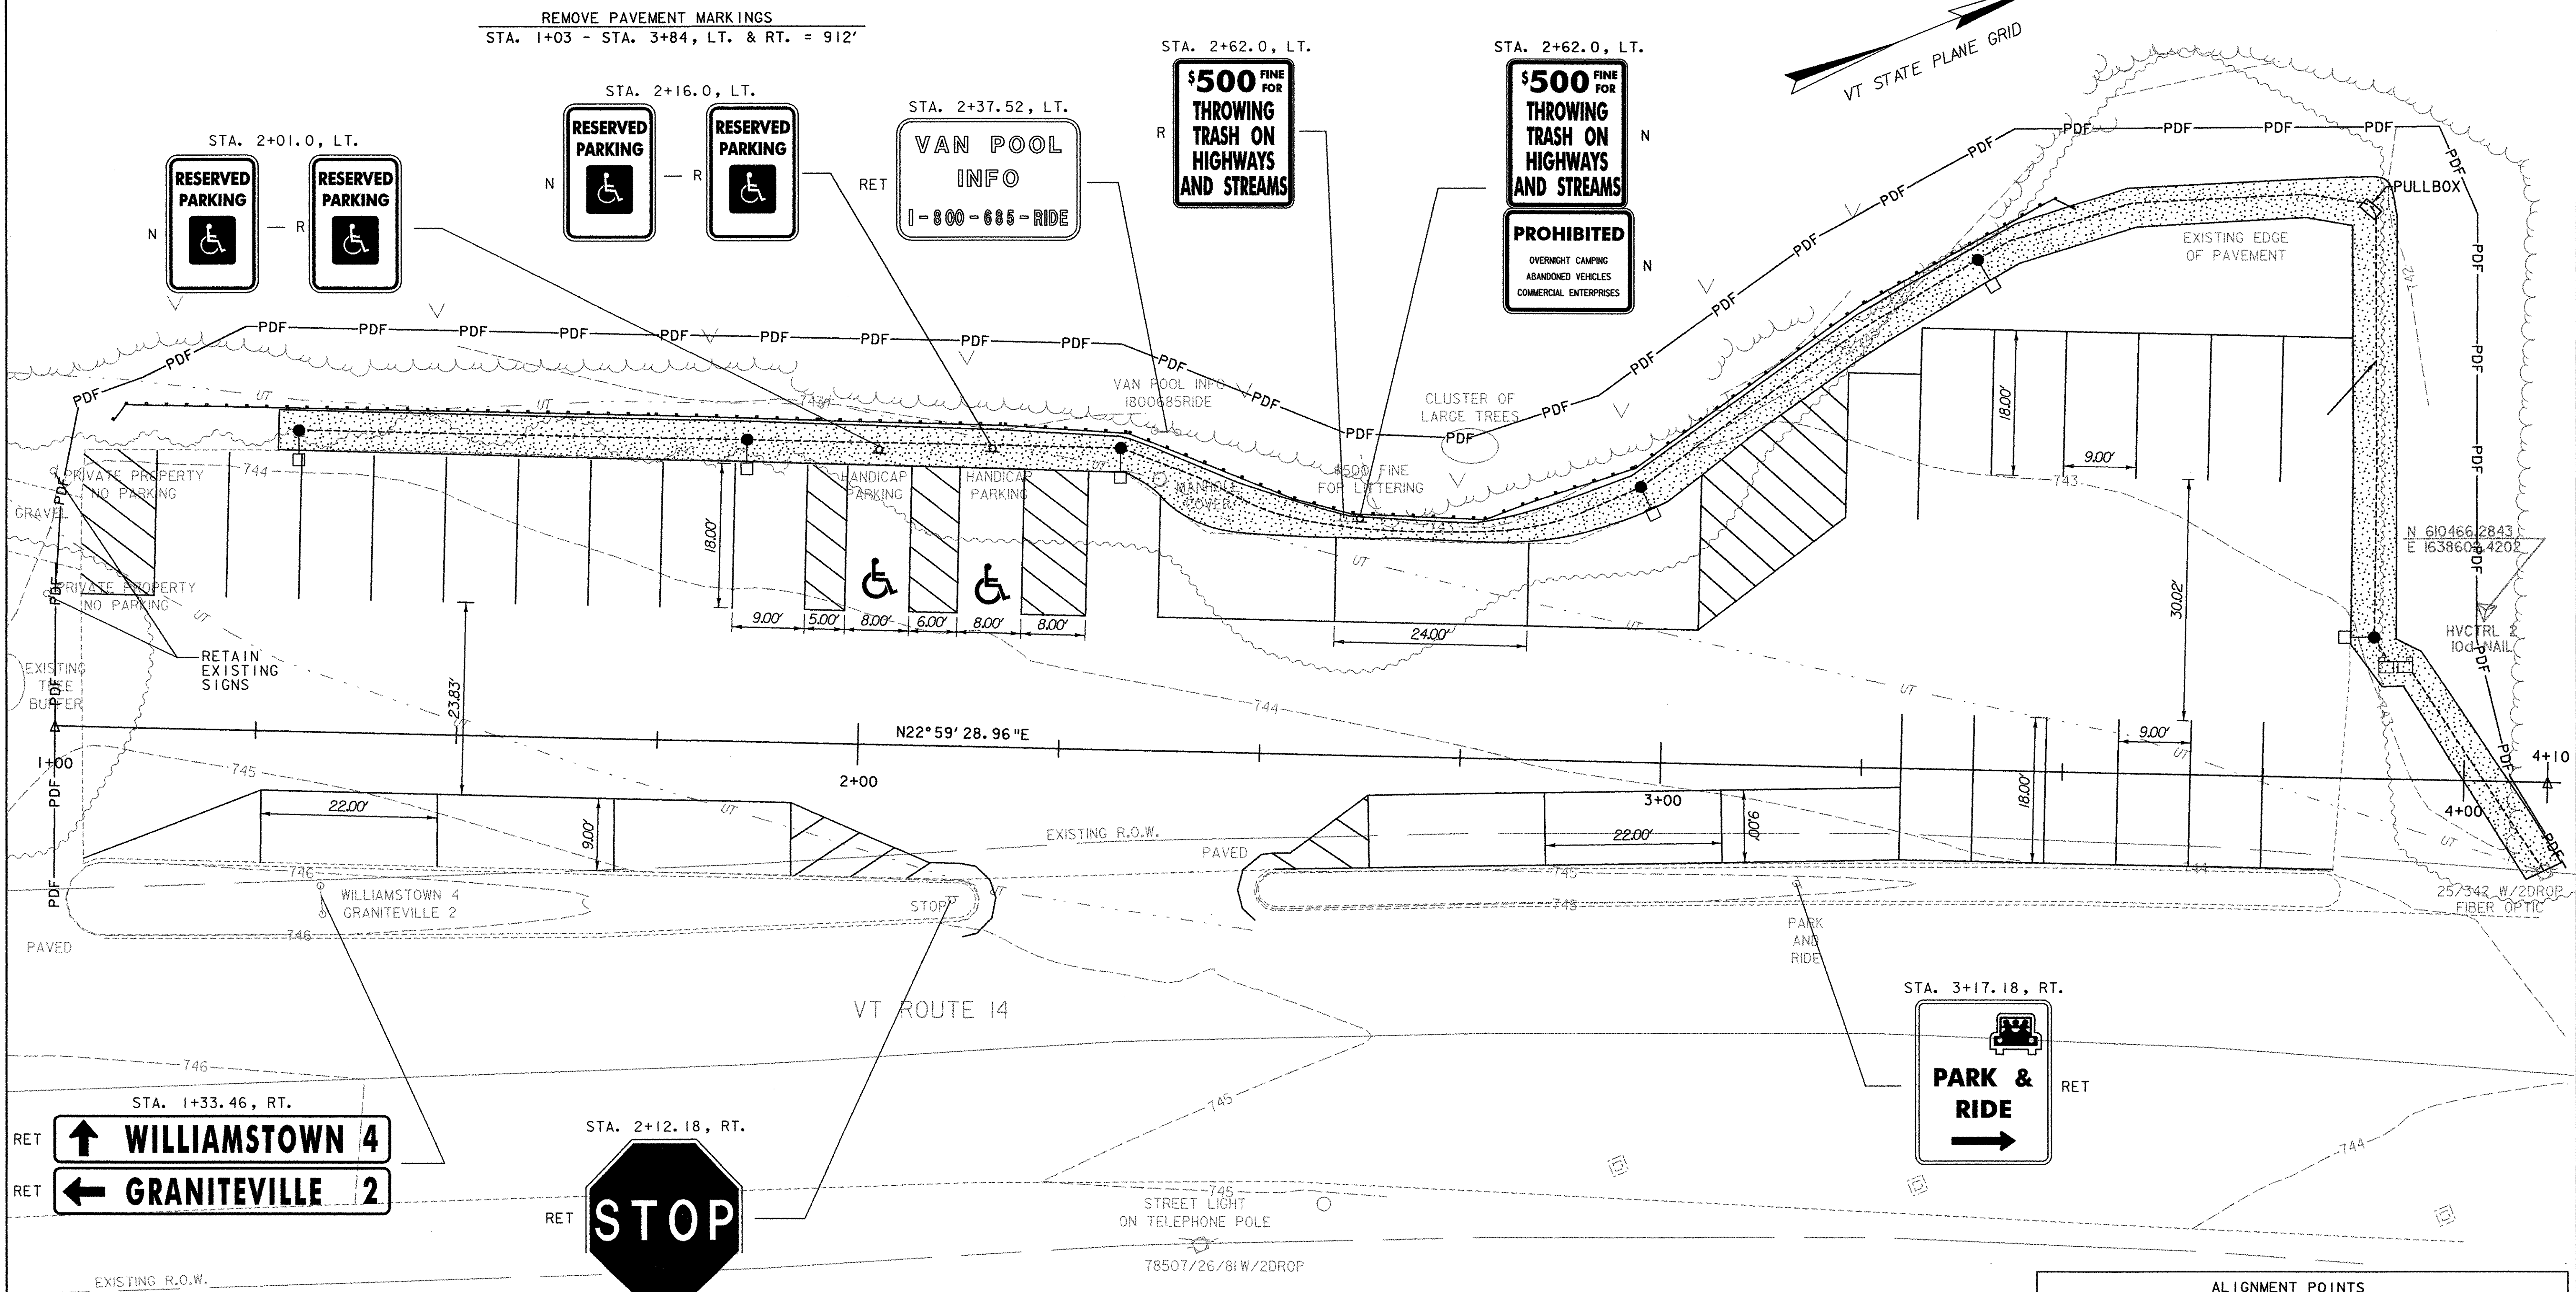


N 610140.6089
 E 1638578.3425
LEGEND

	TOPSOIL, SEED & HAY MULCH, TYP. WIDTH 4'-6"		STEEP SLOPE
	GEOTEXTILE FOR SILT FENCE		NEW LIGHT POLE AND LUMINAIRE
	LIMITS OF CONSTRUCTION		UNDERGROUND TELEPHONE
	APPROX. FOLIAGE OVERHANG		EXISTING CONTOURS
	APPROX. EDGE OF FOLIAGE		
	APPROX. R.O.W. LINE		

SIGN LEGEND
 N - NEW
 R - REMOVE
 S - SALVAGE
 RET - RETAIN

NOTES:

- HAND DIG AROUND EXISTING UTILITIES AS REQUIRED. THIS WORK WILL NOT BE PAID FOR DIRECTLY, BUT WILL BE CONSIDERED INCIDENTAL TO ALL CONTRACT ITEMS. REPAIRS FOR DAMAGE TO EXISTING UTILITIES WILL BE MADE AT THE EXPENSE OF THE CONTRACTOR.
- FOR SEED FORMULA AND NOTES, SEE GENERAL DETAILS.
- FOR LIGHTING NOTES, SEE LIGHTING LAYOUT AND DETAILS.

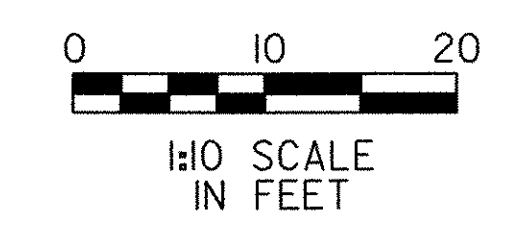

ALIGNMENT POINTS				
POINT	NORTHING	EASTING	STATION	ELEVATION
HVCTRL 1	610466.2843	1638602.4202	4+02.2 LT 21.1'	742.9169
HVCTRL 2	610154.9877	1638584.7655	1+03.0 RT 83.7'	752.4222
1+00	610179.8317	1638503.7819	1+00	N/A
4+00	610456.9444	1638620.6292	4+00	N/A

PROJECT NAME: BARRE TOWN PARK-AND-RIDE
 PROJECT NUMBER: CMG PARK (24) S
 FILE NAME: ...Trans\PlotFiles\04 plan.ptf PLOT DATE: 4/14/2006
 PROJECT LEADER: GAS DRAWN BY: SRZ
 DESIGNED BY: SRZ CHECKED BY: GAS
LAYOUT PLAN SHEET 4 OF 14

