
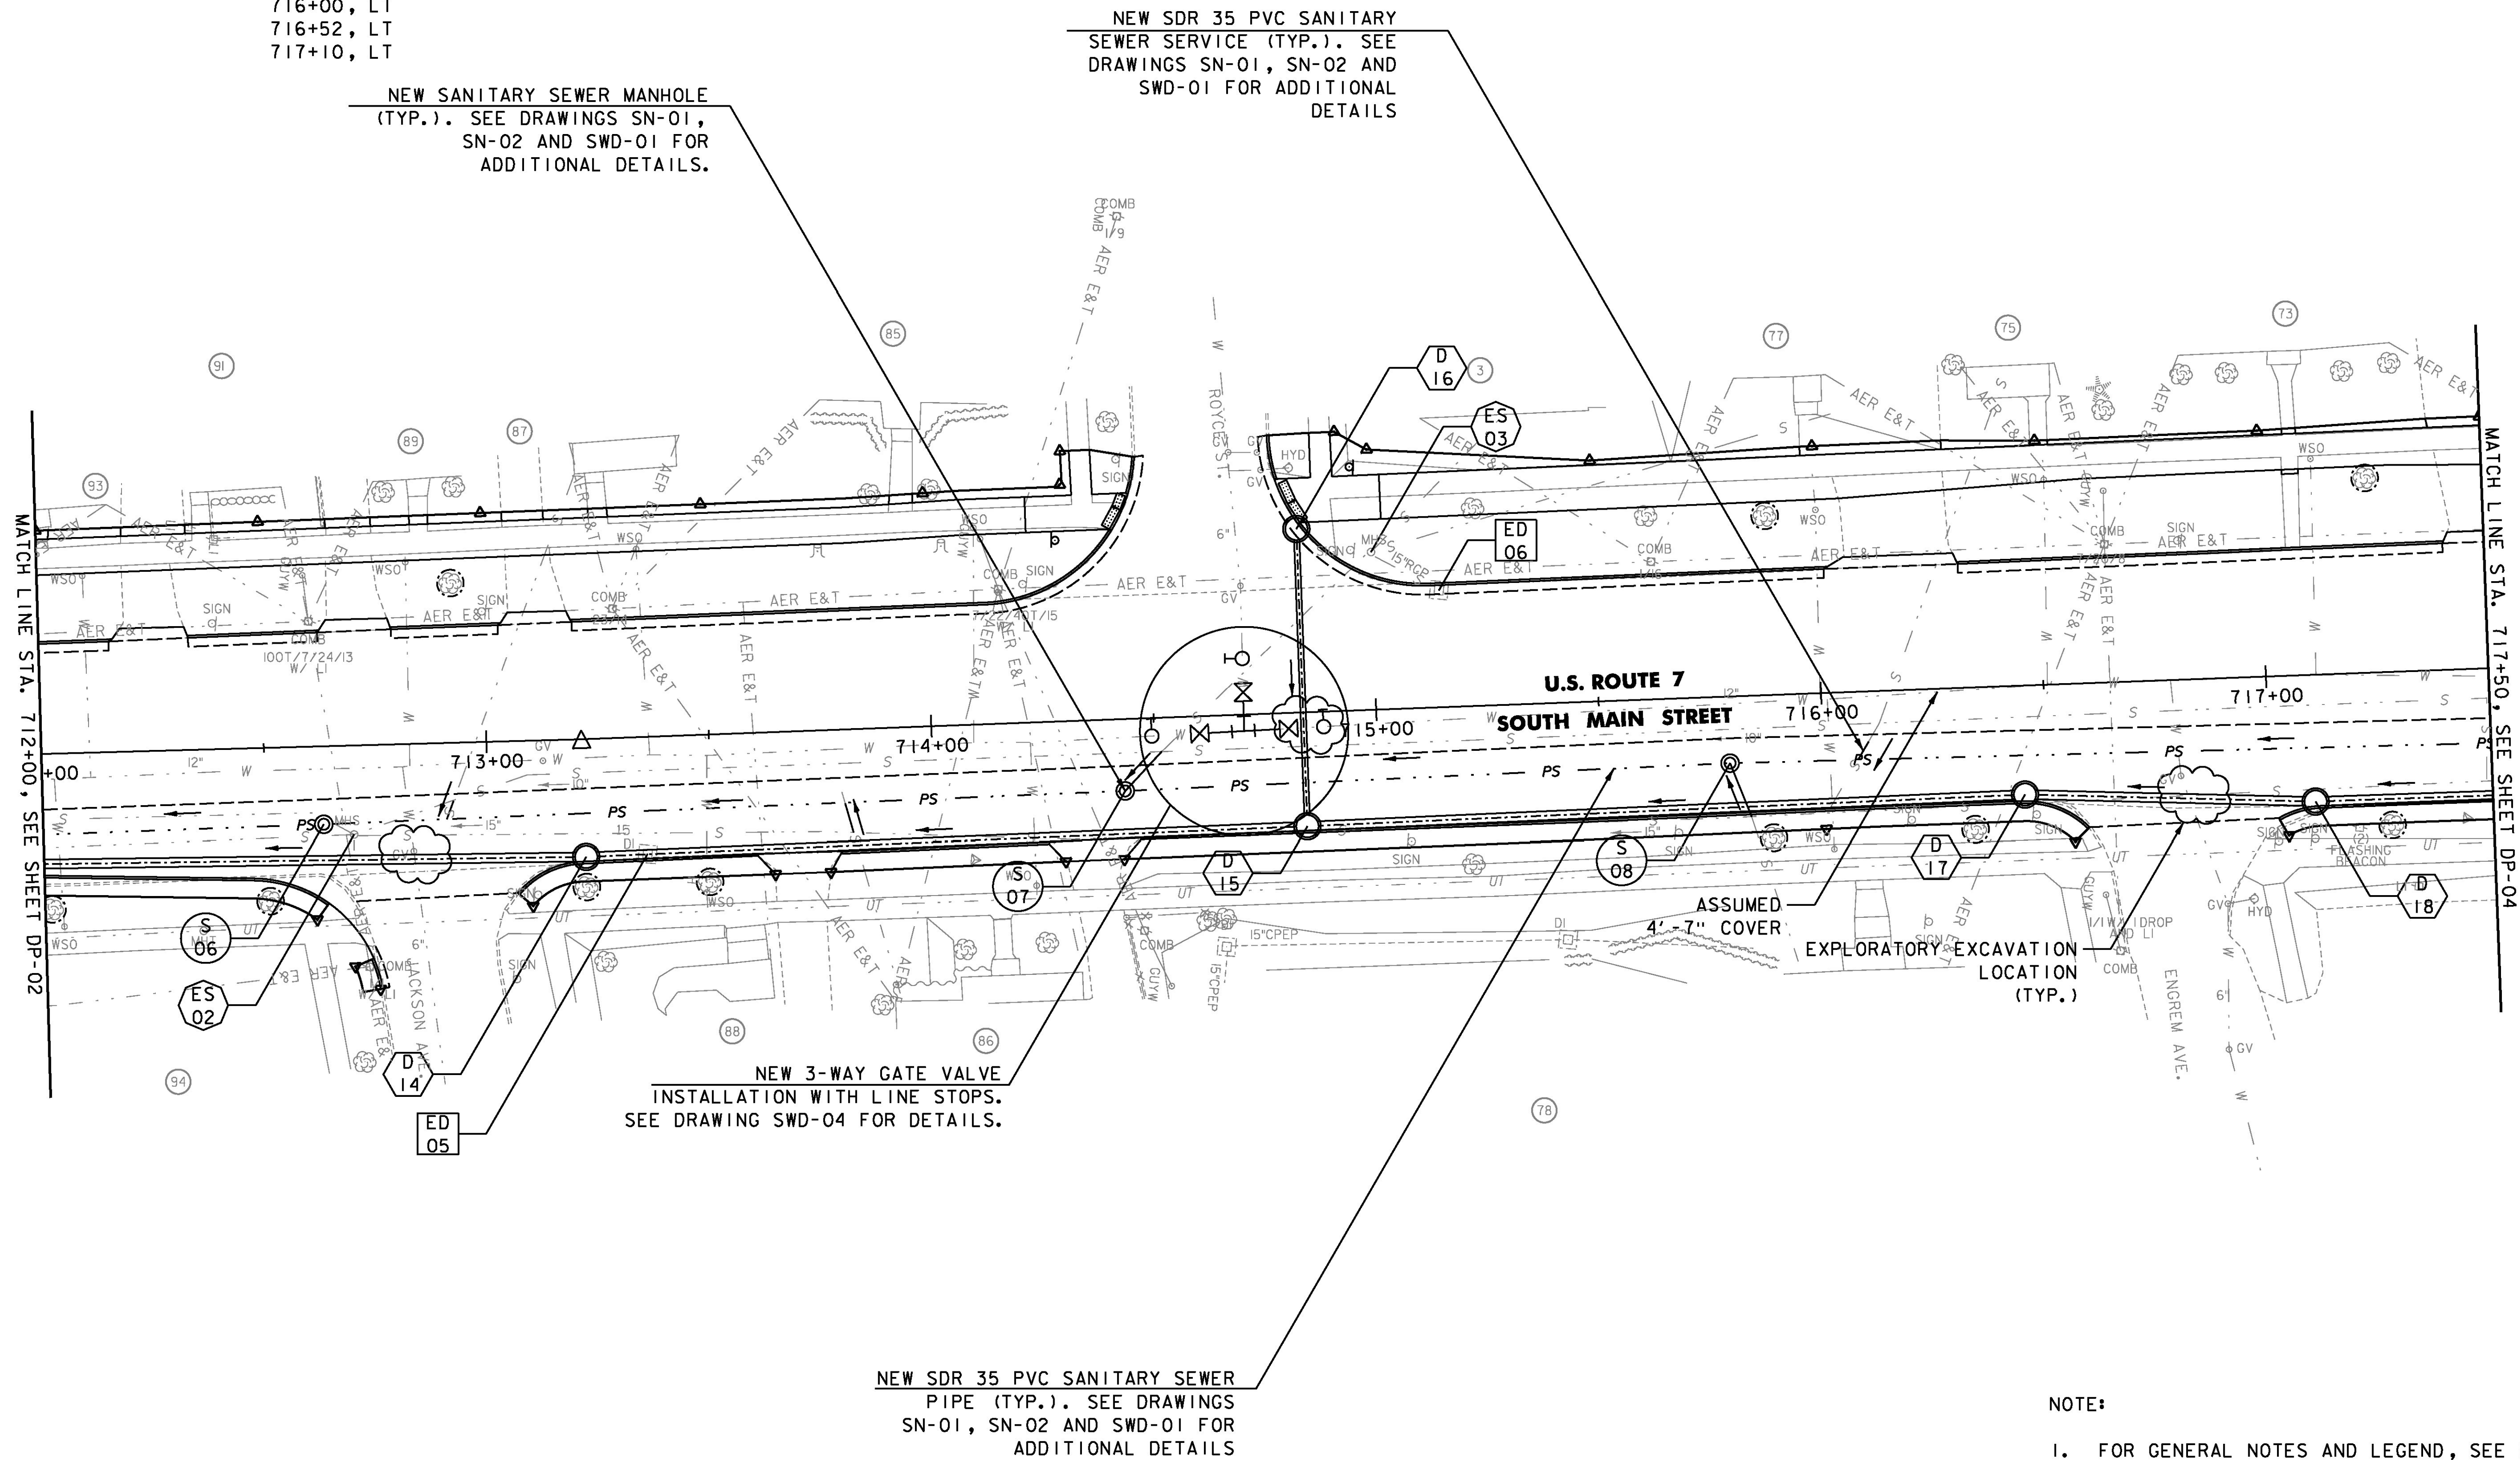


**SPECIAL PROVISION  
(ADJUST ELEVATION  
OF VALVE BOX)**

712+83, RT  
714+75, LT  
714+76, LT  
716+80, RT

**SPECIAL PROVISION  
(ADJUST ELEVATION  
OF WATER SHUT OFF)**

712+10, LT  
712+83, LT  
713+35, LT  
714+11, LT  
716+00, LT  
716+52, LT  
717+10, LT

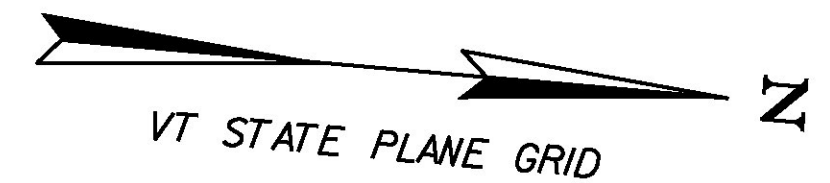

NOTE:  
1. FOR GENERAL NOTES AND LEGEND, SEE SHEET SS-01

PROJECT NAME:	RUTLAND CITY
PROJECT NUMBER:	STP 019-3(57)
FILE NAME:	...PlotFiles\rut_drrnplan.dgn
PROJECT LEADER:	GAE
DESIGNED BY:	TFD
STORM AND UTILITY PLAN	SS-03
PLOT DATE:	7/12/2013
DRAWN BY:	PZA
CHECKED BY:	GAE
SHEET	298 OF 392

