


NEW SANITARY SEWER MANHOLE (TYP.). SEE DRAWINGS SN-01, SN-02 AND SWD-01 FOR ADDITIONAL DETAILS.

NEW SDR 35 PVC SANITARY SEWER SERVICE (TYP.). SEE DRAWINGS SN-01, SN-02 AND SWD-01 FOR ADDITIONAL DETAILS.

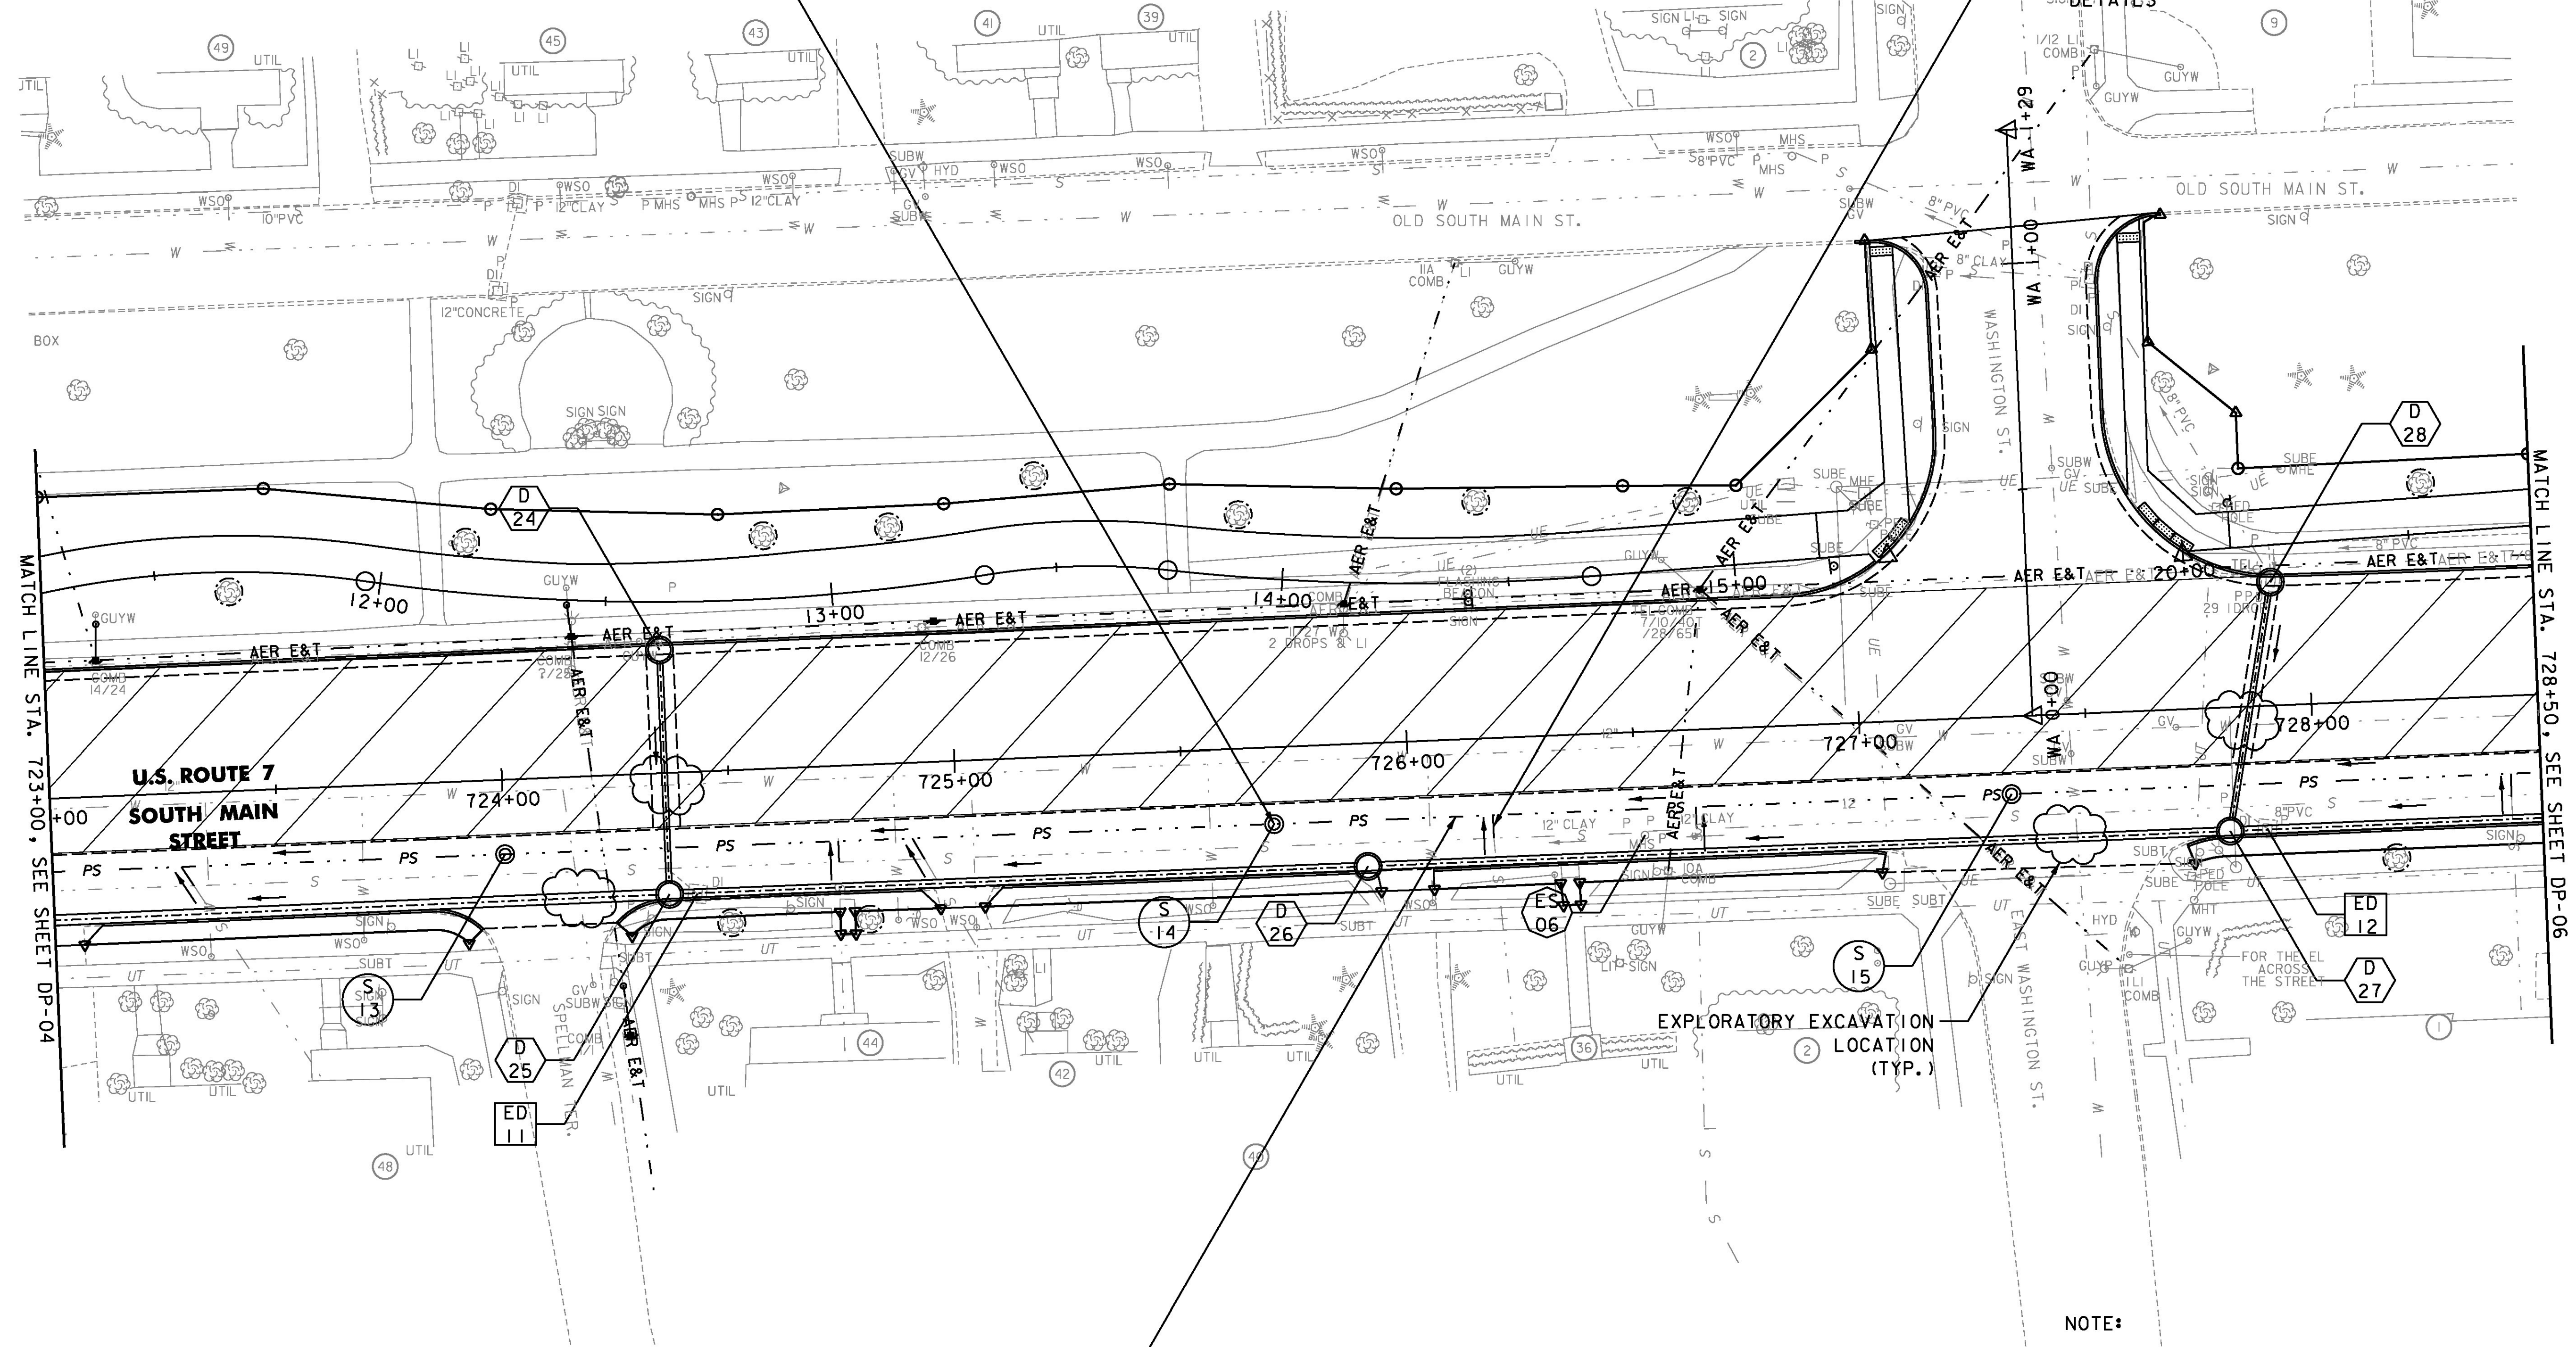


NEW SDR 35 PVC SANITARY SEWER PIPE (TYP.). SEE DRAWINGS SN-01, SN-02 AND SWD-01 FOR ADDITIONAL DETAILS.

EXPLORATORY EXCAVATION LOCATION (TYP.)

NOTE:

1. FOR GENERAL NOTES AND LEGEND, SEE SHEET SS-01

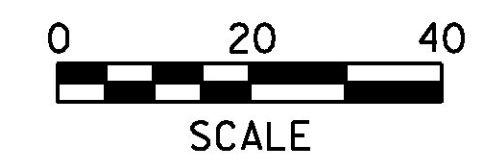

PROJECT NAME:	RUTLAND CITY
PROJECT NUMBER:	STP 019-3(57)
FILE NAME:	...\\PlotFiles\rut_drnplan.dgn
PROJECT LEADER:	GAE
DESIGNED BY:	TFD
STORM AND UTILITY PLAN SS-05	
PLOT DATE:	7/12/2013
DRAWN BY:	PZA
CHECKED BY:	GAE
SHEET	300 OF 392