



LIGHTING CONSTRUCTION

AT THE DISCRETION OF THE CITY, THE LIGHTS SHOWN ON THIS PLAN MAY BE ELIMINATED FROM THE PROJECT.

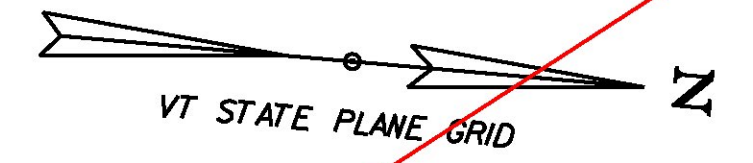

SEE REVISED SHEET 360A

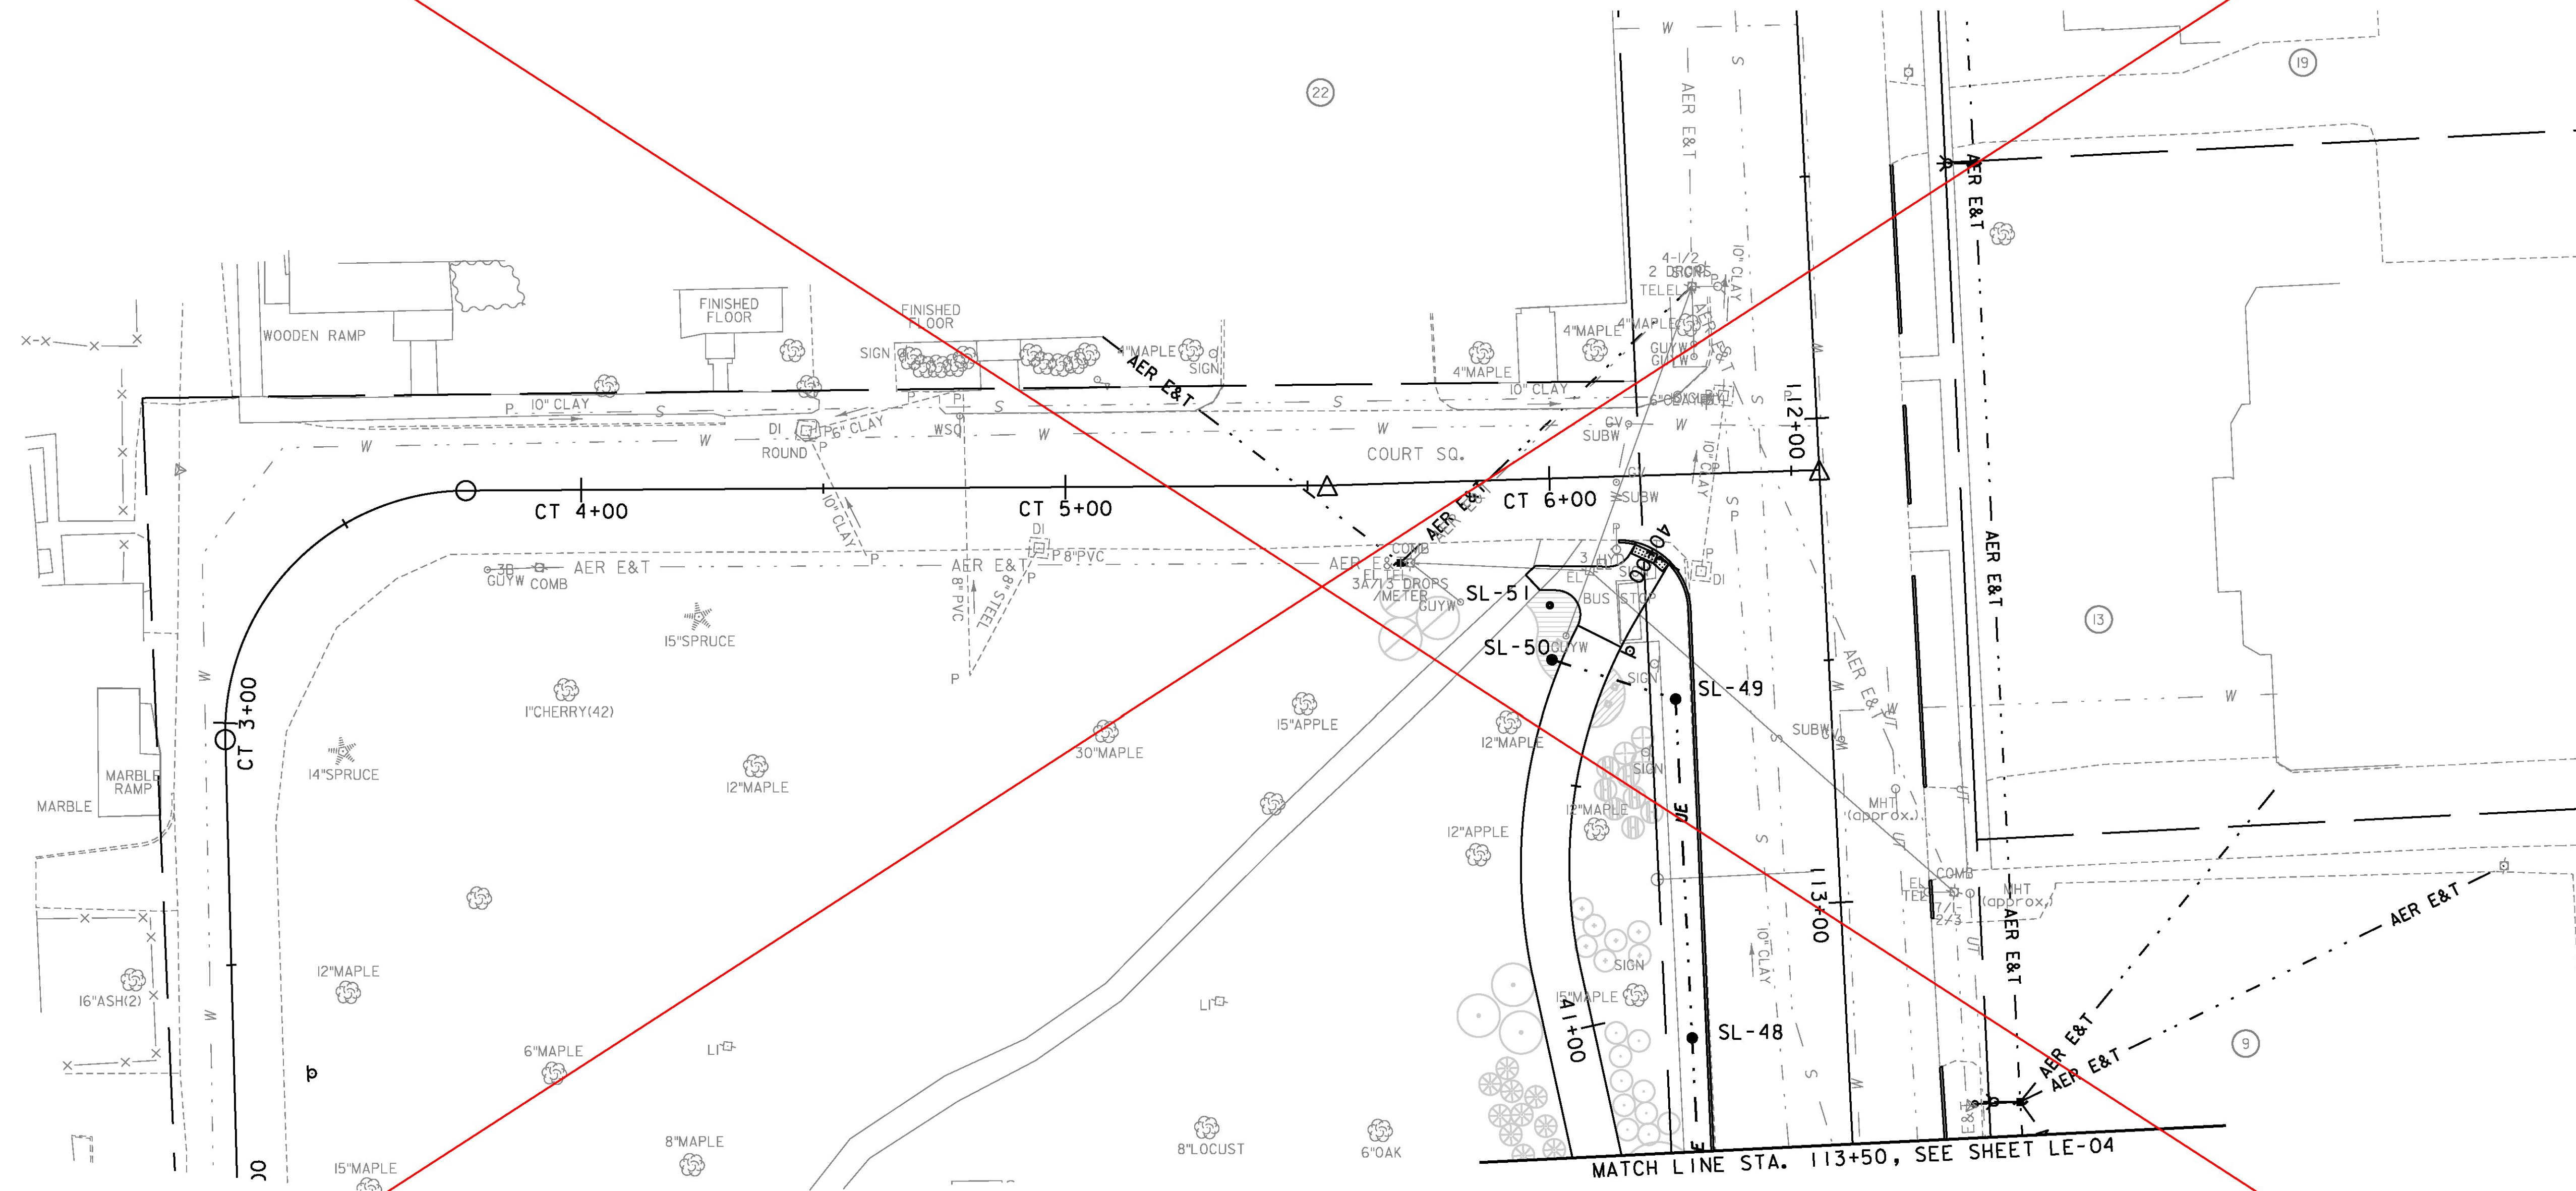

NOTE:
1. FOR LIGHTING AND ELECTRICAL NOTES SEE SHEET LE-01.

STREET LIGHTING SCHEDULE			
STREET LIGHT NO.	LOCATION	OFFSET	FIXTURE TYPE
SL-48	113+26	32' RT	A
SL-49	112+56	32' RT	A
SL-50	112+47	57' RT	A
SL-51	112+36	57' RT	D



PROJECT NAME:	RUTLAND CITY
PROJECT NUMBER:	STP 019-3(57)
FILE NAME:	...Trans\PlotFiles\rut_light.dgn
PLOT DATE:	7/12/2013
PROJECT LEADER:	GAE
DRAWN BY:	PZA
DESIGNED BY:	TFD
CHECKED BY:	GAE
LIGHTING & ELECTRICAL PLAN LE-05	SHEET 360 OF 392