


**LIGHTING CONSTRUCTION**


AT THE DISCRETION OF THE CITY, THE LIGHTS SHOWN ON THIS PLAN MAY BE ELIMINATED FROM THE PROJECT.

REVISION	BY	DATE
△ CONDUIT AND LIGHTING REMOVED FROM CONTRACT	TFD	11/05/13

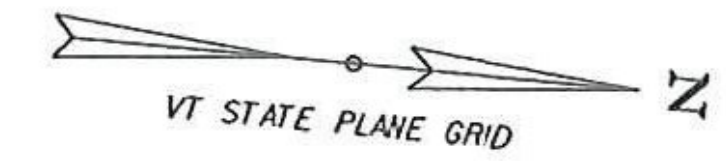

**REVISION LEGEND**


- = STREET LIGHT TO BE REMOVED FROM THE CONTRACT
- X- = WIRED CONDUIT TO BE REMOVED FROM THE CONTRACT

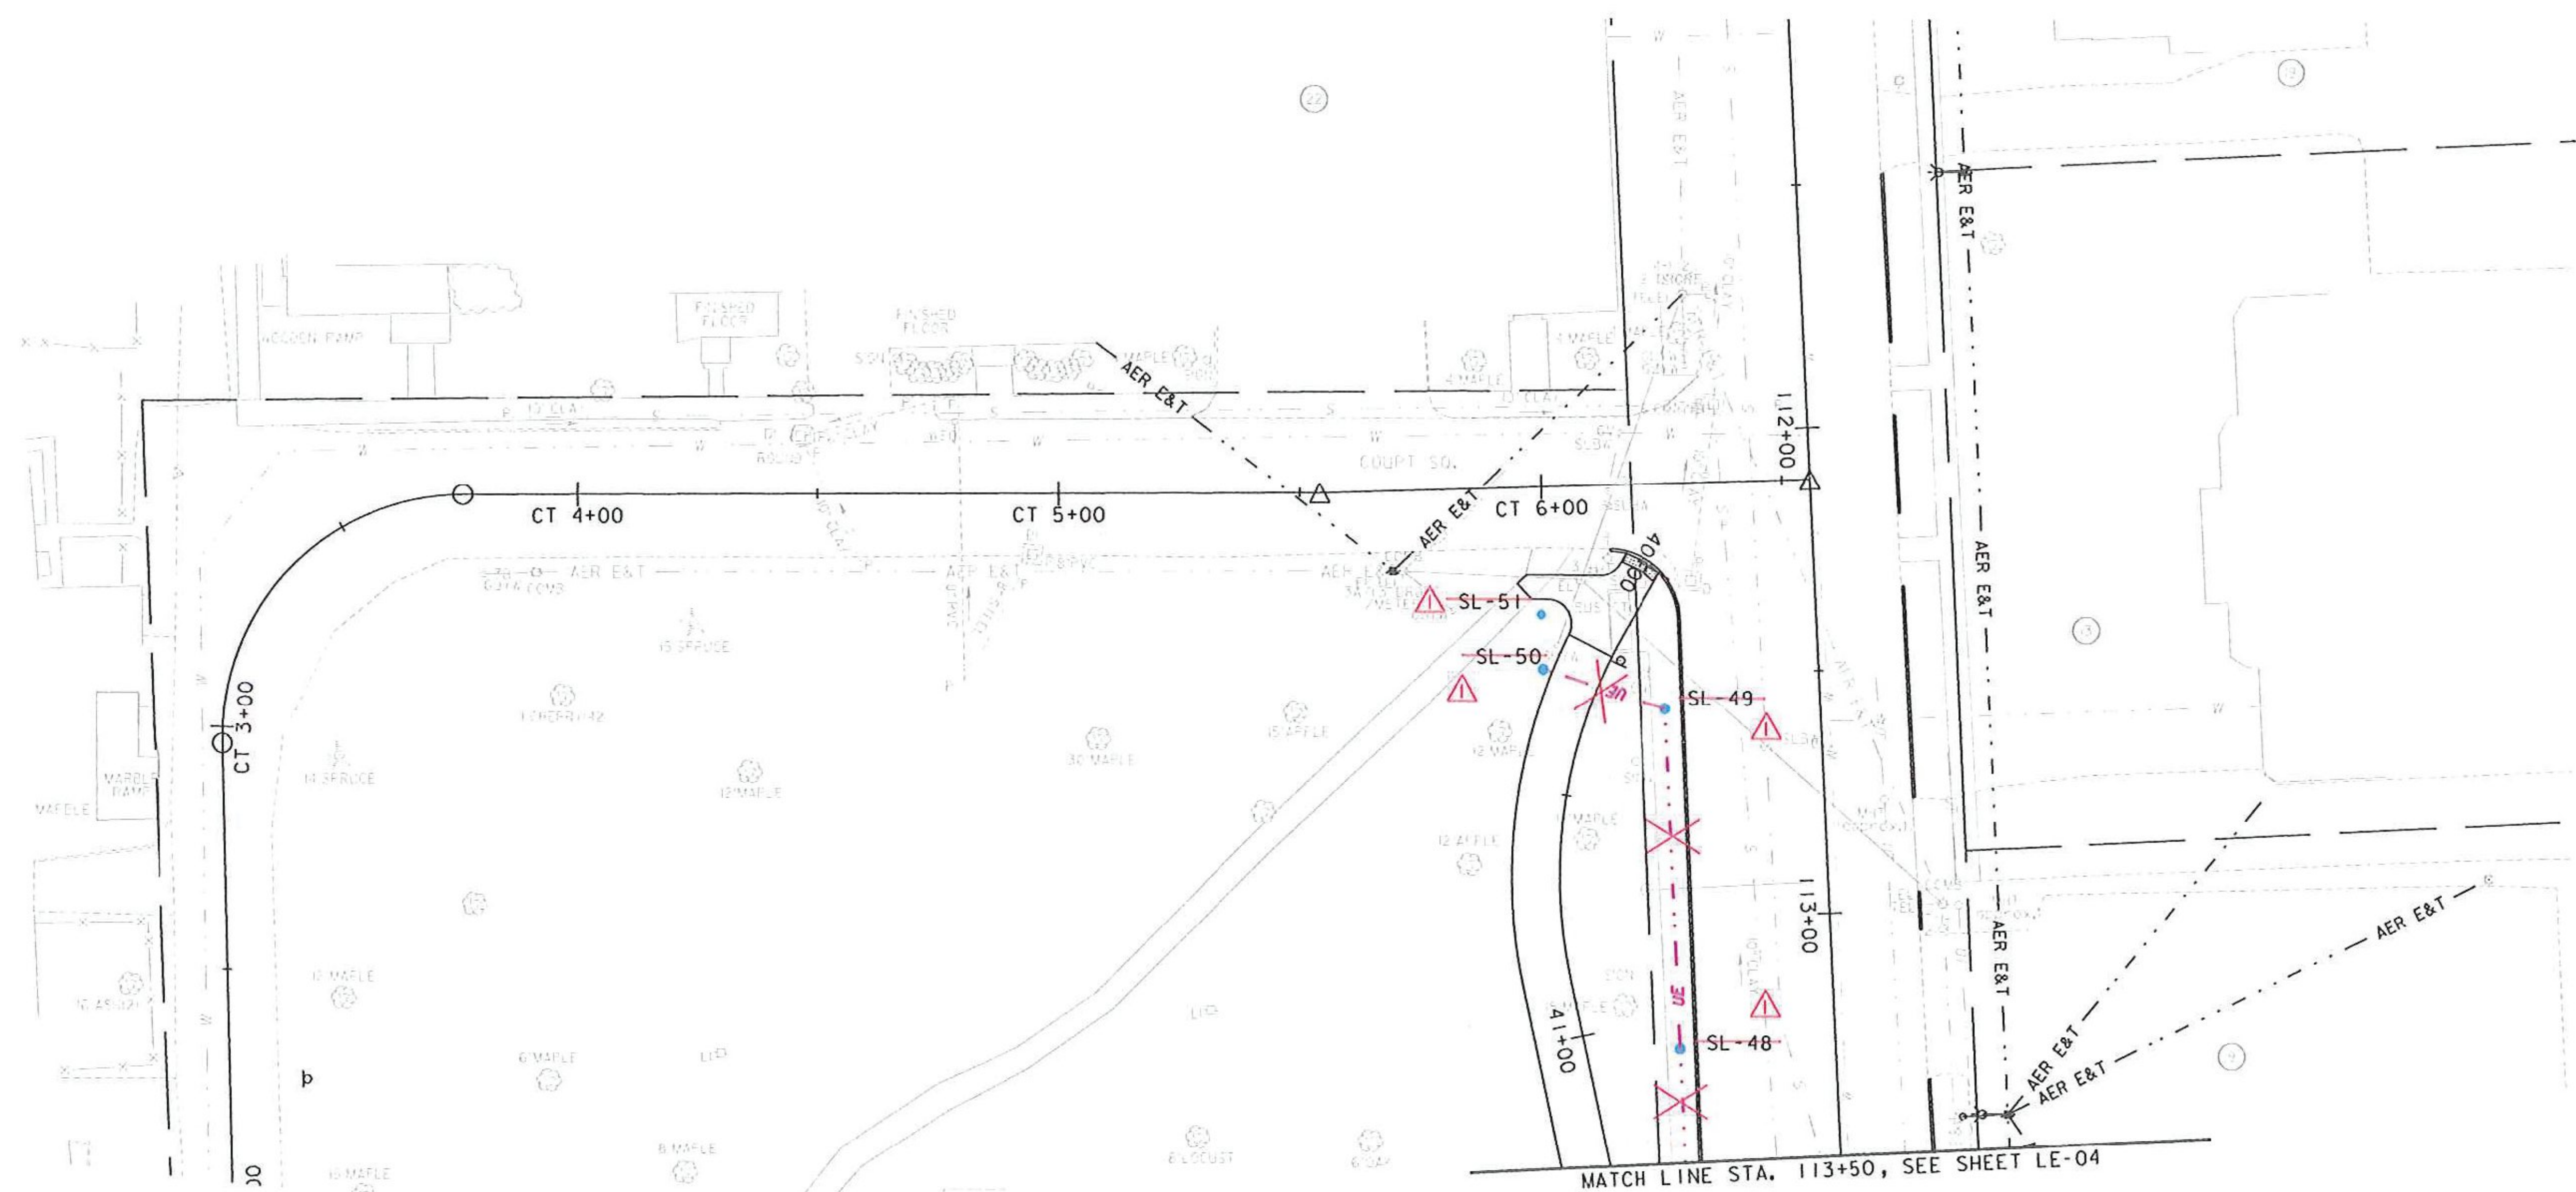

MATCH LINE STA. 113+50, SEE SHEET LE-04

NOTE:  
1. FOR LIGHTING AND ELECTRICAL NOTES SEE SHEET LE-01.

STREET LIGHTING SCHEDULE			
STREET LIGHT NO.	LOCATION	OFFSET	FIXTURE TYPE
SL-48	113+26	32' RT	A
SL-49	112+56	32' RT	A
SL-50	112+47	57' RT	A
SL-51	112+36	57' RT	D

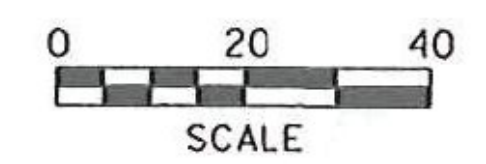

PROJECT NAME: RUTLAND CITY	PLOT DATE: 11/5/2013
PROJECT NUMBER: STP 019-3(57)	DRAWN BY: PZA
FILE NAME: ...rur_lght.dgn	DESIGNED BY: TFD
PROJECT LEADER: GAE	CHECKED BY: GAE
LIGHTING & ELECTRICAL PLAN LE-05	SHEET 360AOF 392