


DP-XX = REFERENCE TO CORRESPONDING DRAINAGE PLAN SHEET



**CB309 - DI319**  
**NB 8+700 - NB 9+045 LT**


**DP-01, DP-02**

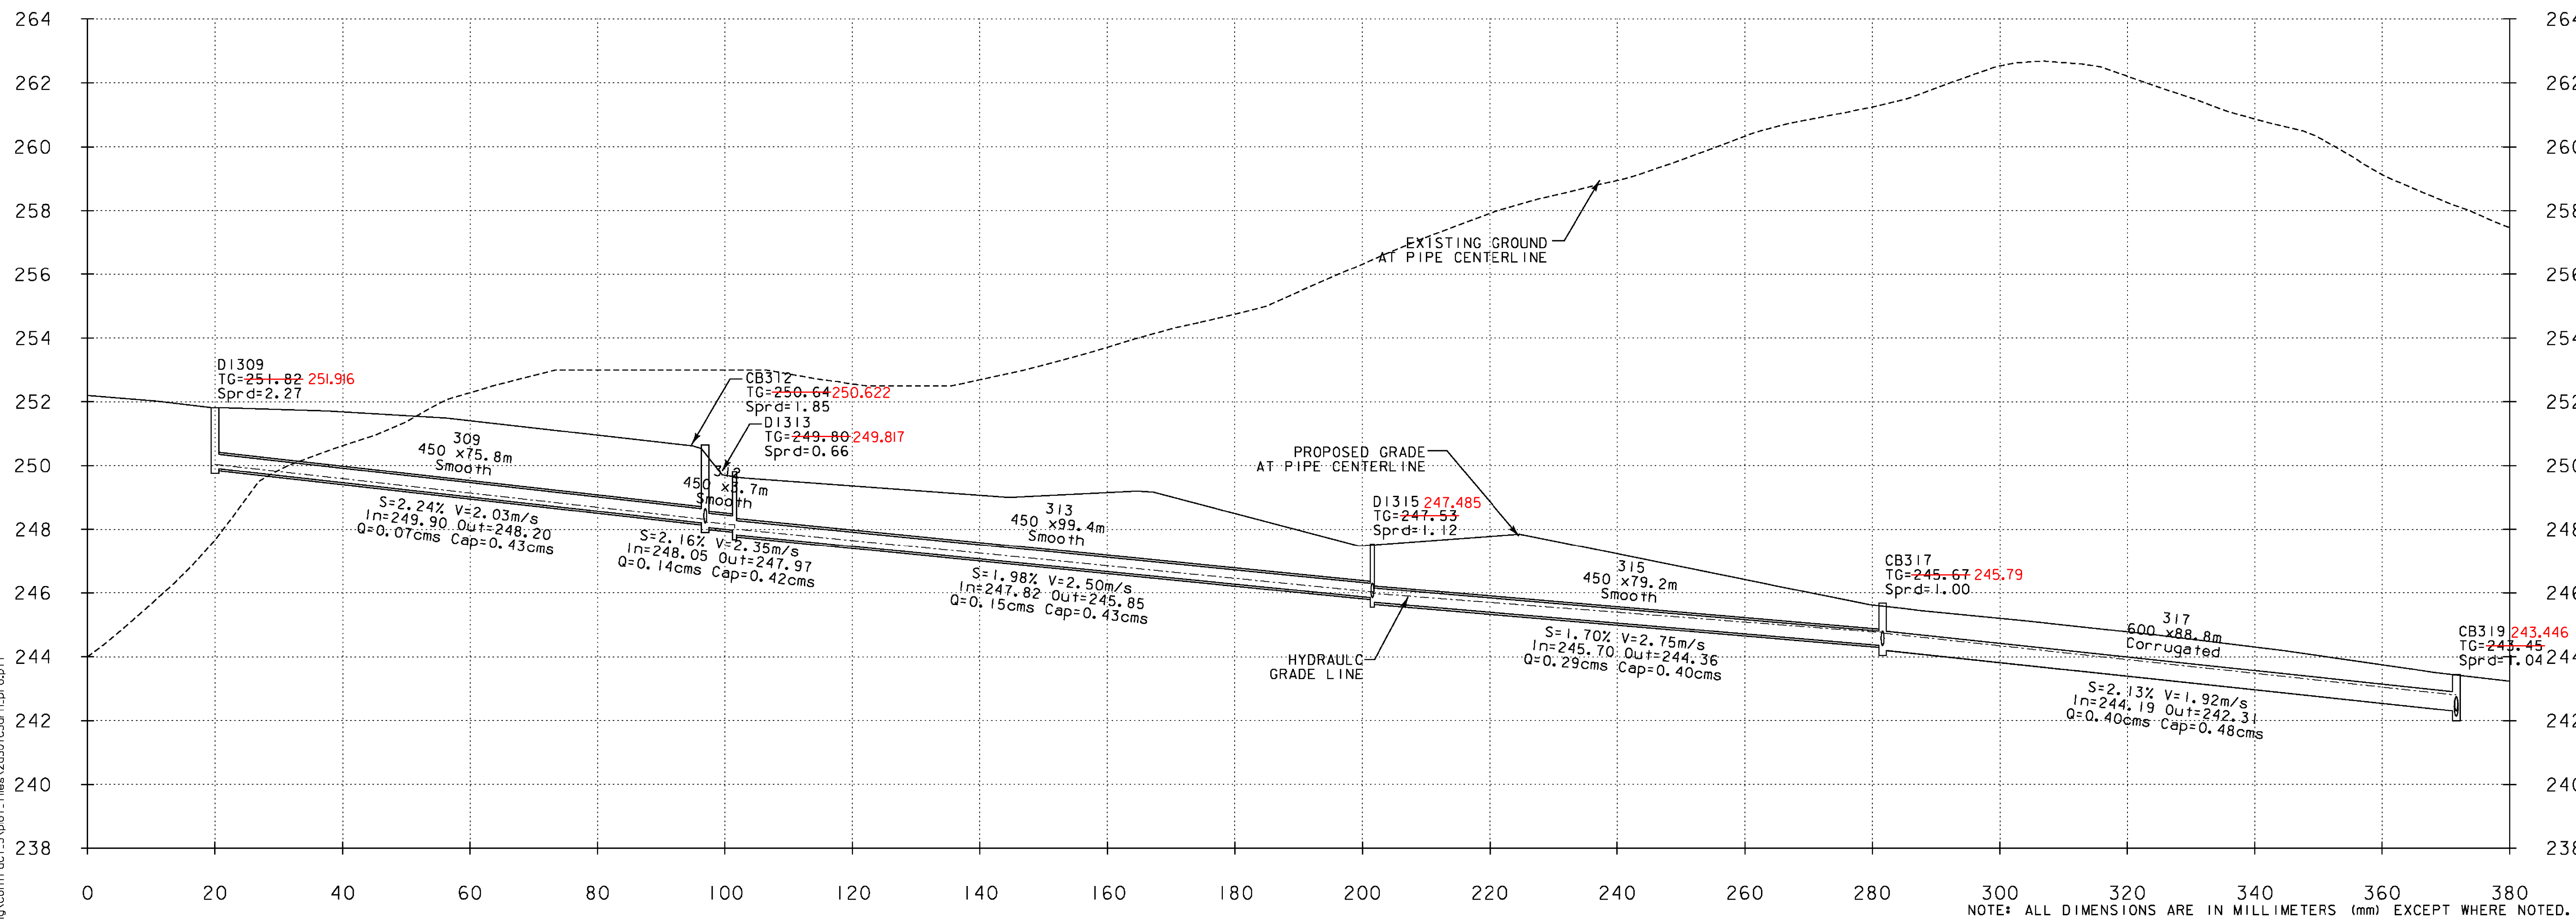

NOTE: ALL DIMENSIONS ARE IN MILLIMETERS (mm) EXCEPT WHERE NOTED.

**SYSTEM 3**

VERMONT AGENCY OF TRANSPORTATION

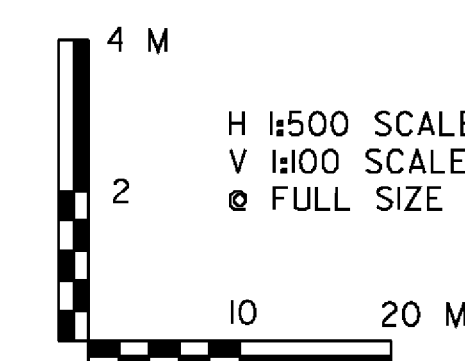

H 1:500 SCALE  
V 1:100 SCALE  
● FULL SIZE



Stantec

PROJECT NAME: BENNINGTON  
PROJECT NUMBER: AC NH 019-1(53)

FILE NAME: ...plot\_files\zd307c3drn\_pro.ptf PLOT DATE: 5/16/2011  
DESIGN SUPERVISOR: GREG EDWARDS DRAWN BY: STANTEC  
DESIGNED BY: MARC FOISY CHECKED BY: GARY SANTY  
**DRAINAGE PROFILE SHEET 2** SHEET 104 OF 577

v:\953\active\9530002\transportation\draining\contract\_3\plot\_files\zd307c3drn\_pro.ptf