



DP-XX = REFERENCE TO CORRESPONDING DRAINAGE PLAN SHEET

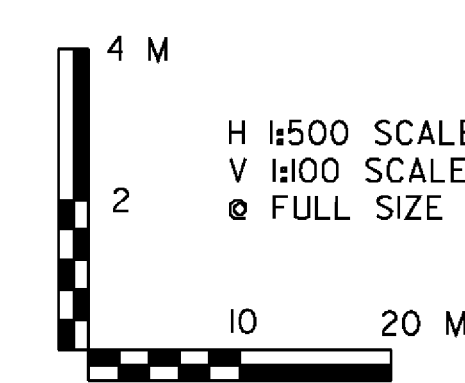

CB319-CB334
NB 9+045 - NB 9+380 LT

DP-02, DP-03

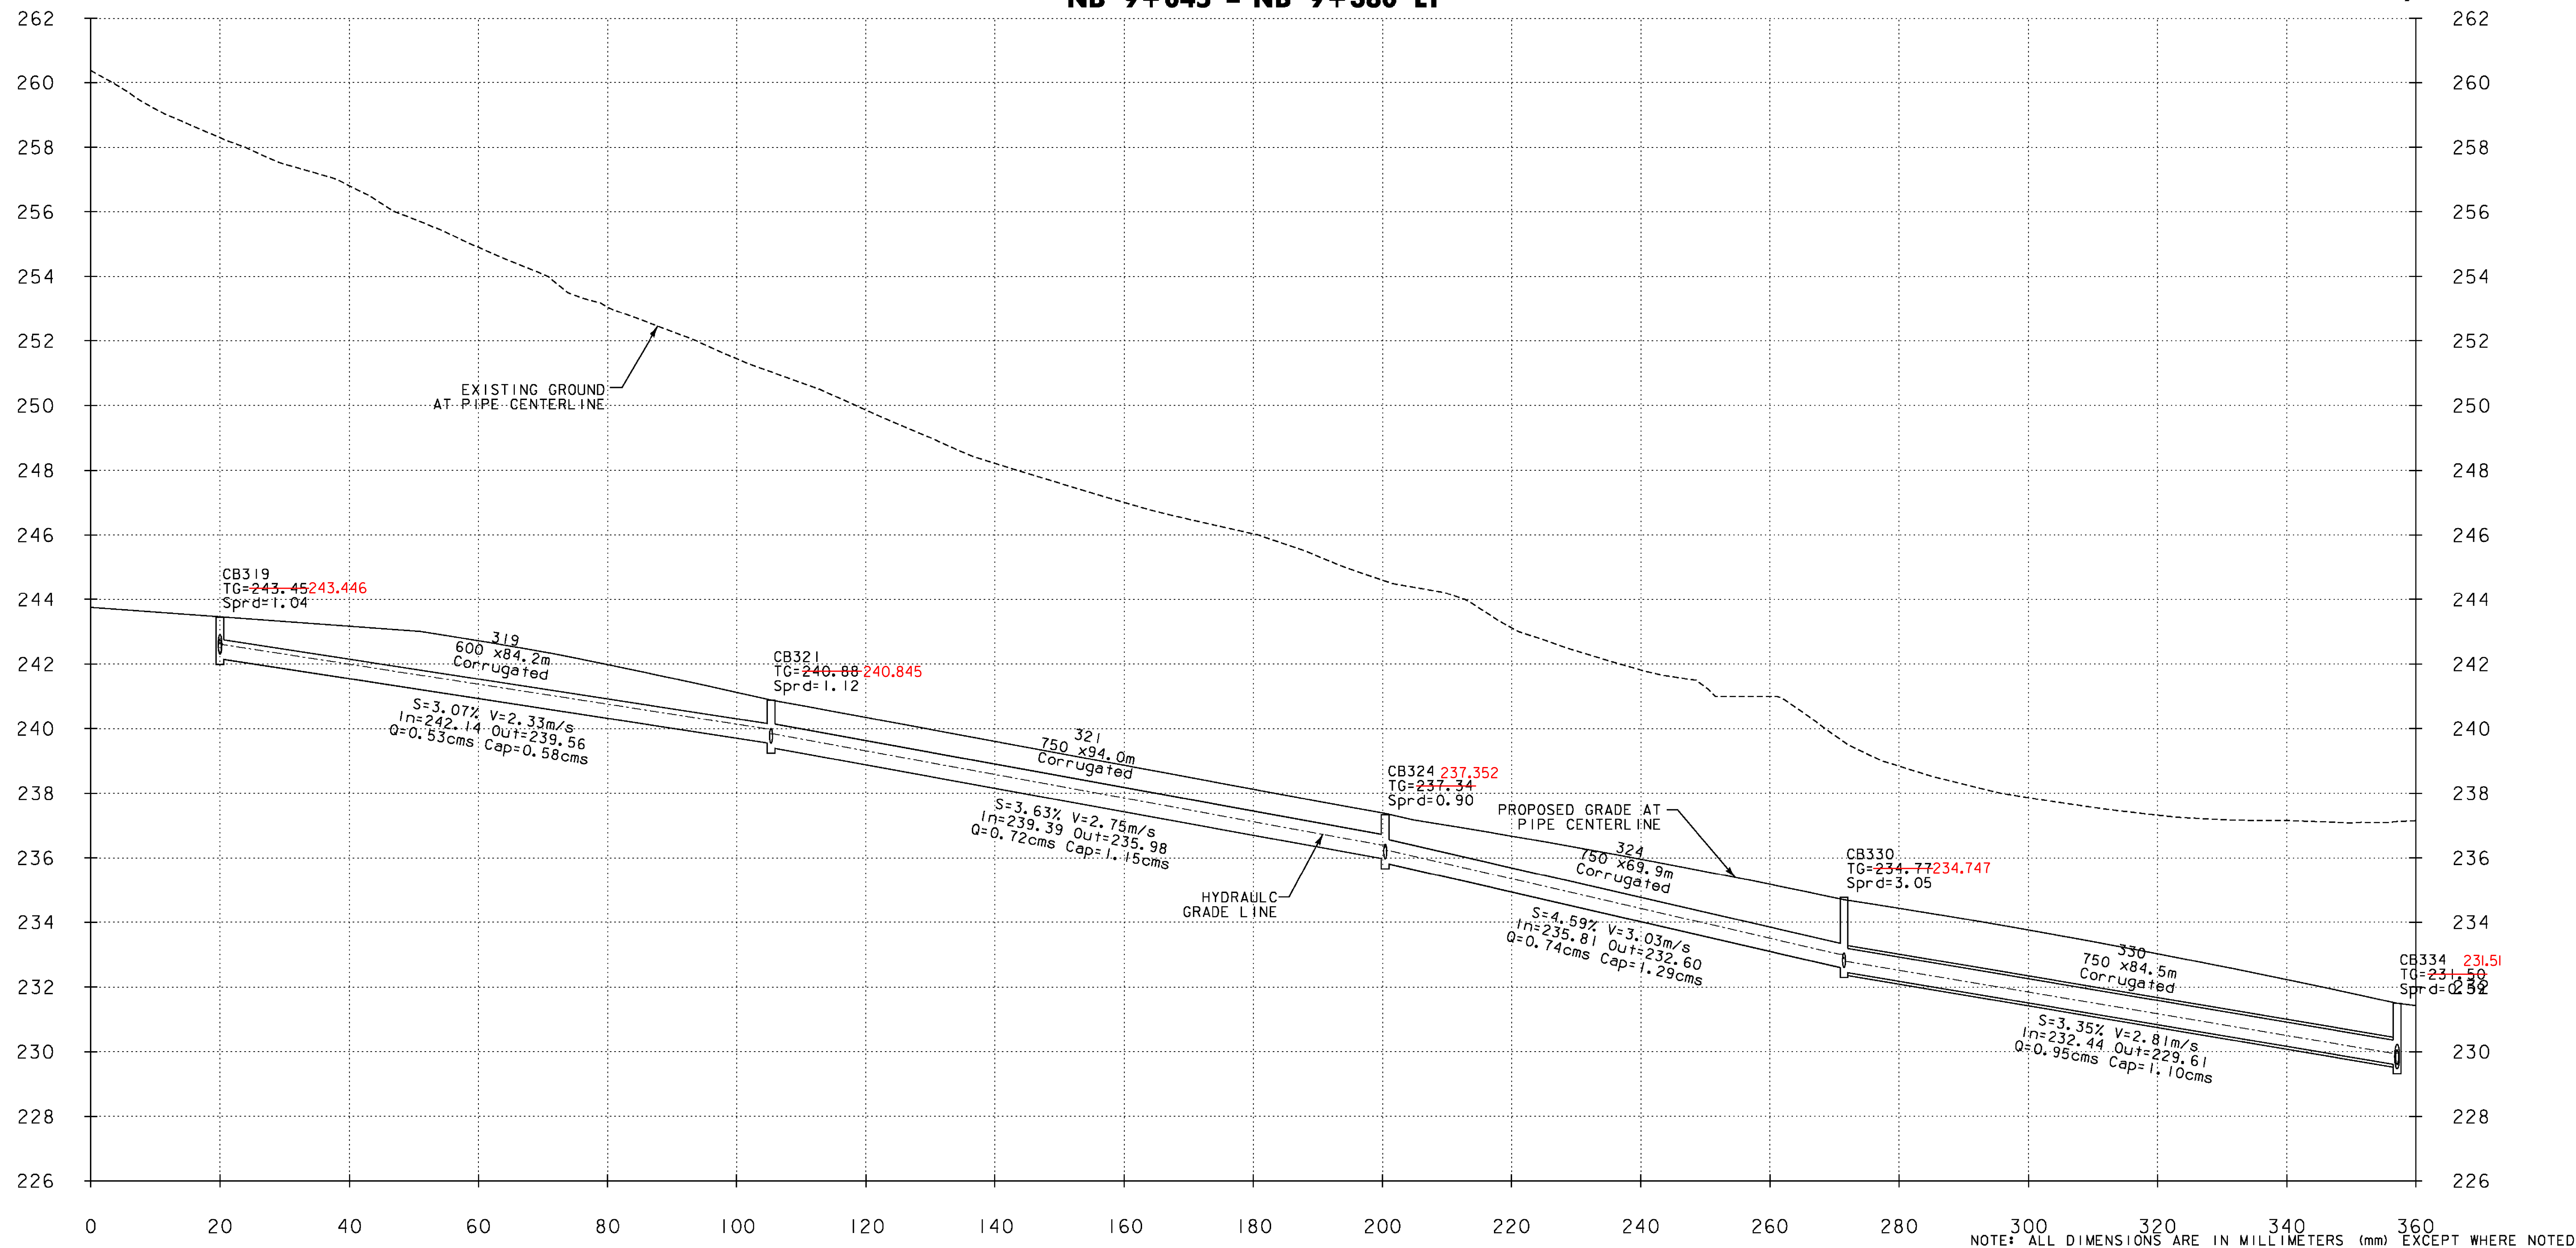

SYSTEM 3	
VERMONT AGENCY OF TRANSPORTATION	
	PROJECT NAME: BENNINGTON
	PROJECT NUMBER: AC NH 019-(153)
FILE NAME: ...\plot_files\zd307c3drn_pro.ptf	PLOT DATE: 5/16/2010
DESIGN SUPERVISOR: GREG EDWARDS	DRAWN BY: STANTEC
DESIGNED BY: MARC FOISY	CHECKED BY: GARY SANTY
DRAINAGE PROFILE SHEET 3	
SHEET 105 OF 577	

vr:\953\active\9530002\transportation\drawing\control\act_3\plot_files\zd307c3drn_pro.ptf