


DP-XX = REFERENCE TO CORRESPONDING DRAINAGE PLAN SHEET

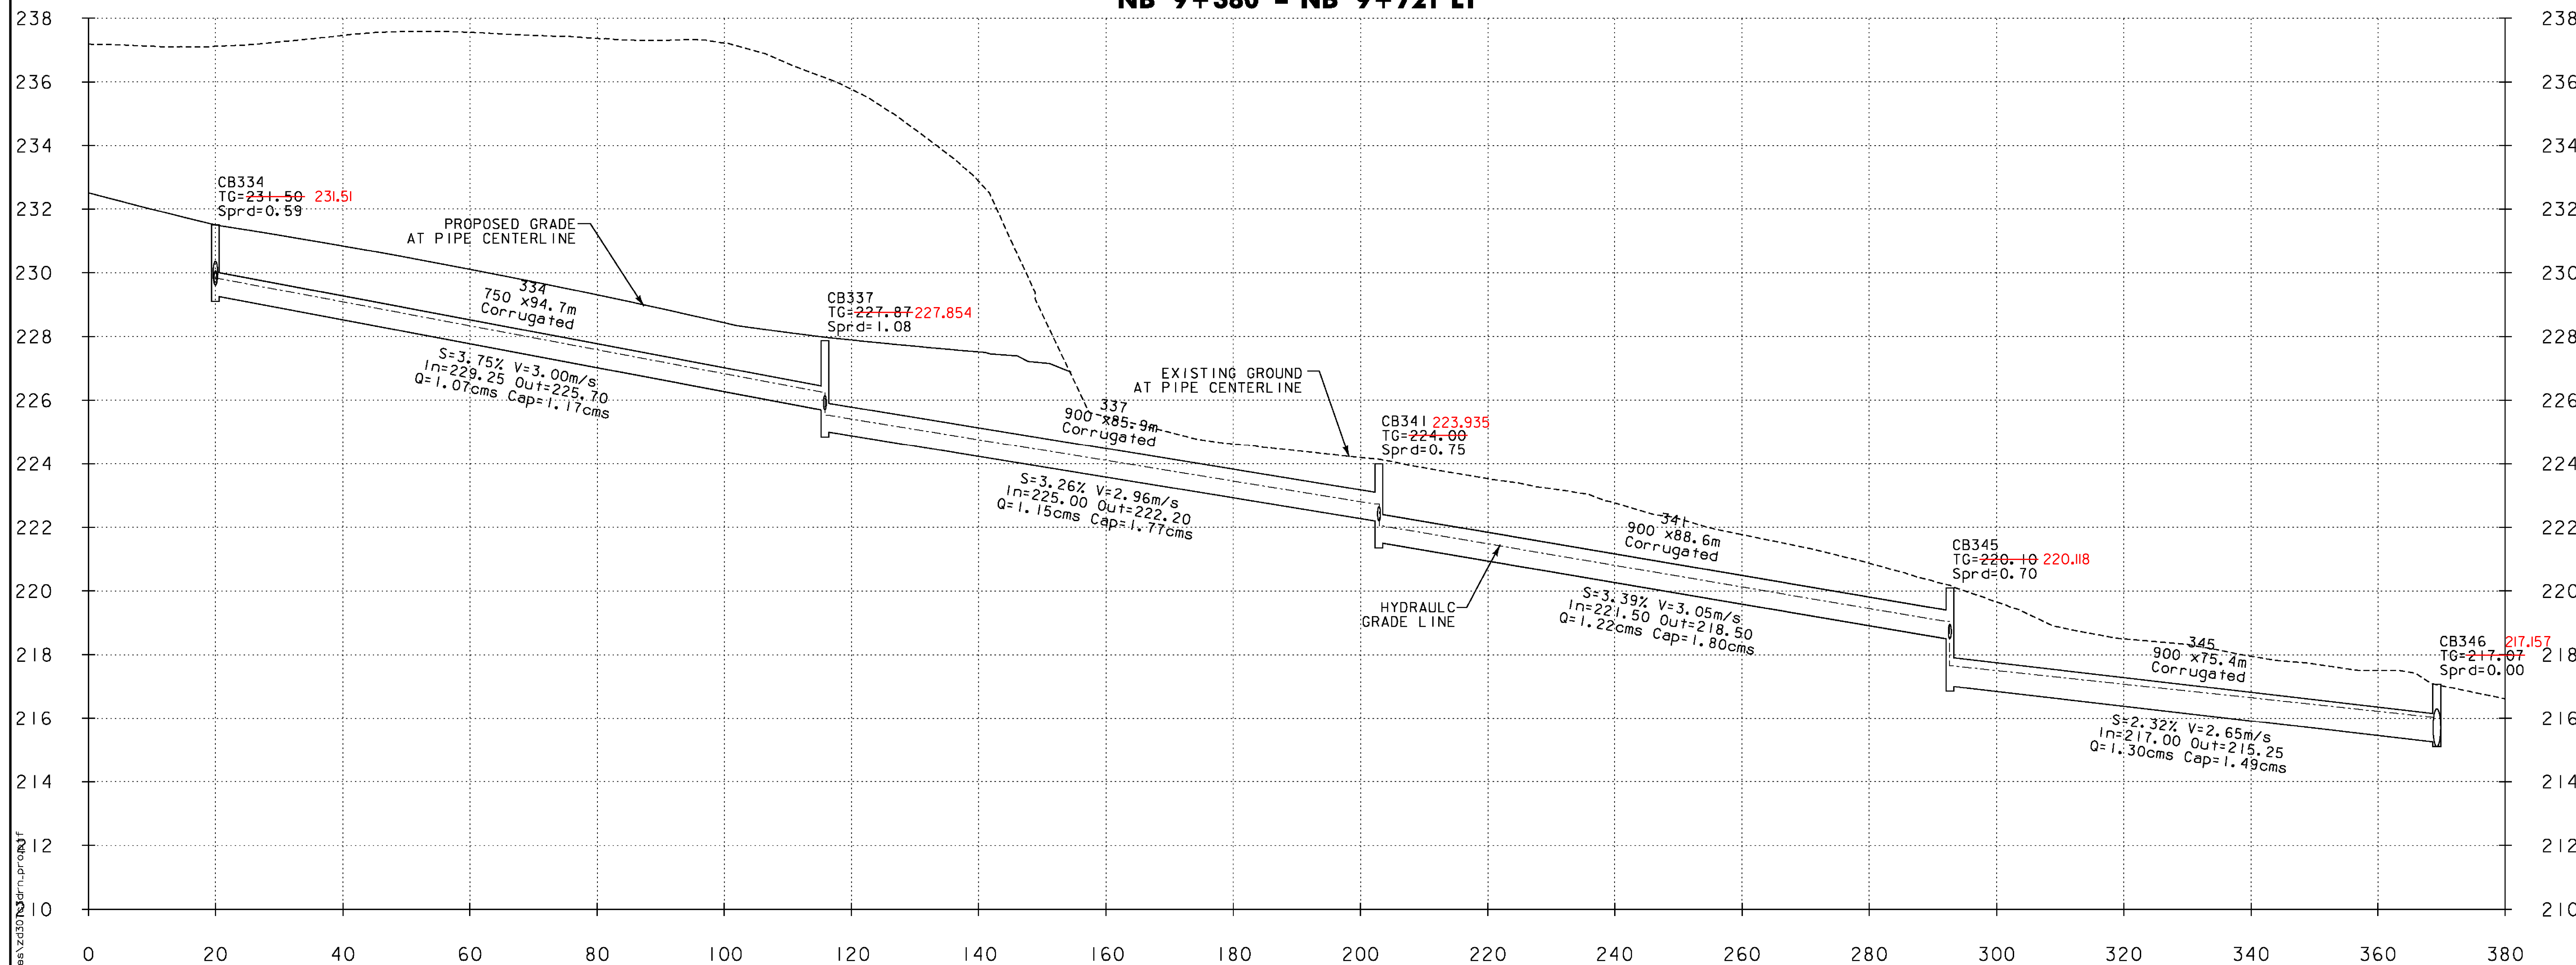


334
CB324 - CB346
NB 9+380 - NB 9+721 LT

DP-03, DP-05



NOTE: ALL DIMENSIONS ARE IN MILLIMETERS (mm) EXCEPT WHERE NOTED.

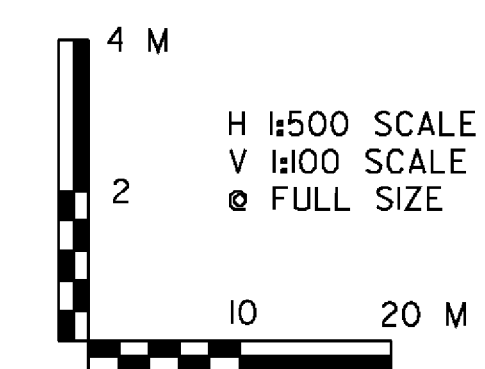

SYSTEM 3	
VERMONT AGENCY OF TRANSPORTATION	
	PROJECT NAME: BENNINGTON PROJECT NUMBER: AC NH 019-1(53)
	FILE NAME: ...plot_files\zd307c3drn.pro.ptf PLOT DATE: 5/16/2011 DESIGN SUPERVISOR: GREG EDWARDS DRAWN BY: STANTEC DESIGNED BY: MARC FOISY CHECKED BY: GARY SANTY DRAINAGE PROFILE SHEET 4 SHEET 106 OF 577

v:\953\active\9530002\transportation\draining\contract_3\plot_files\zd307c3drn.pro.ptf