

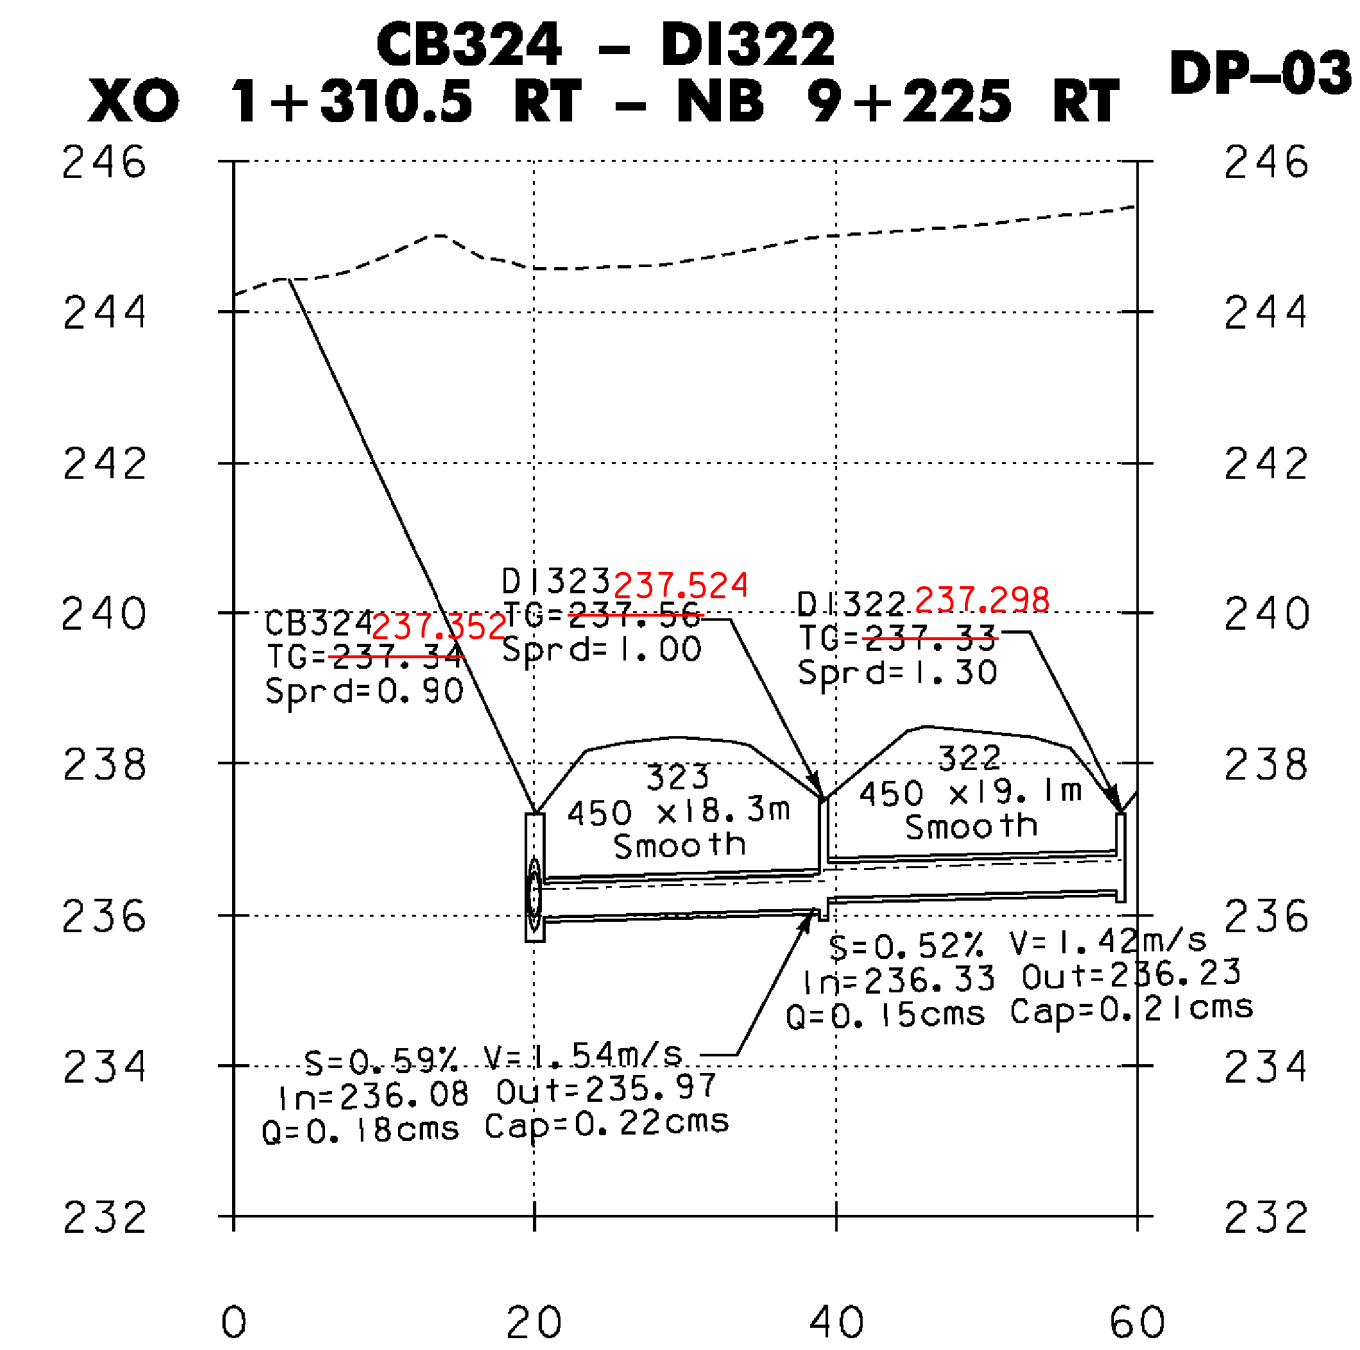
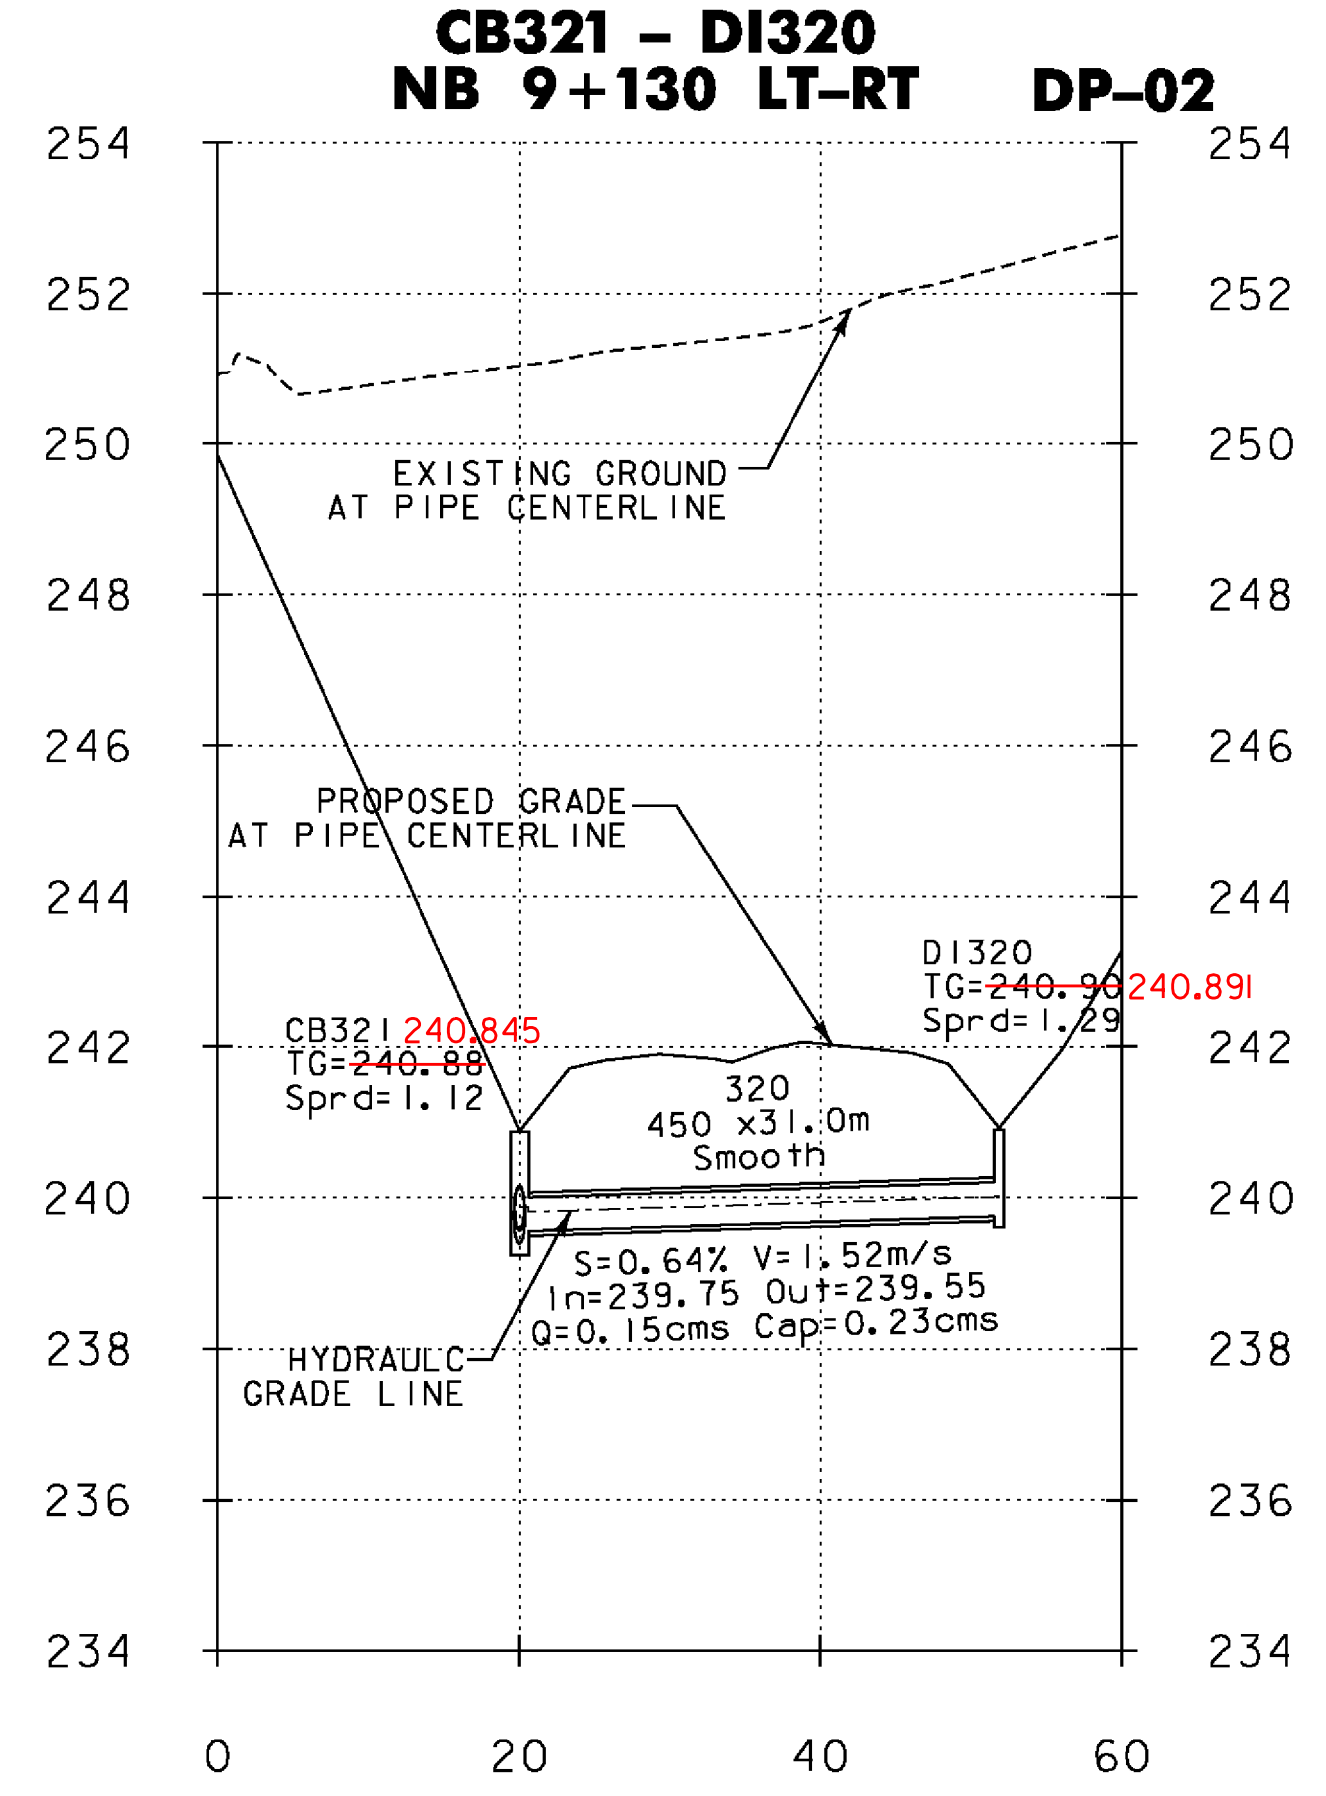
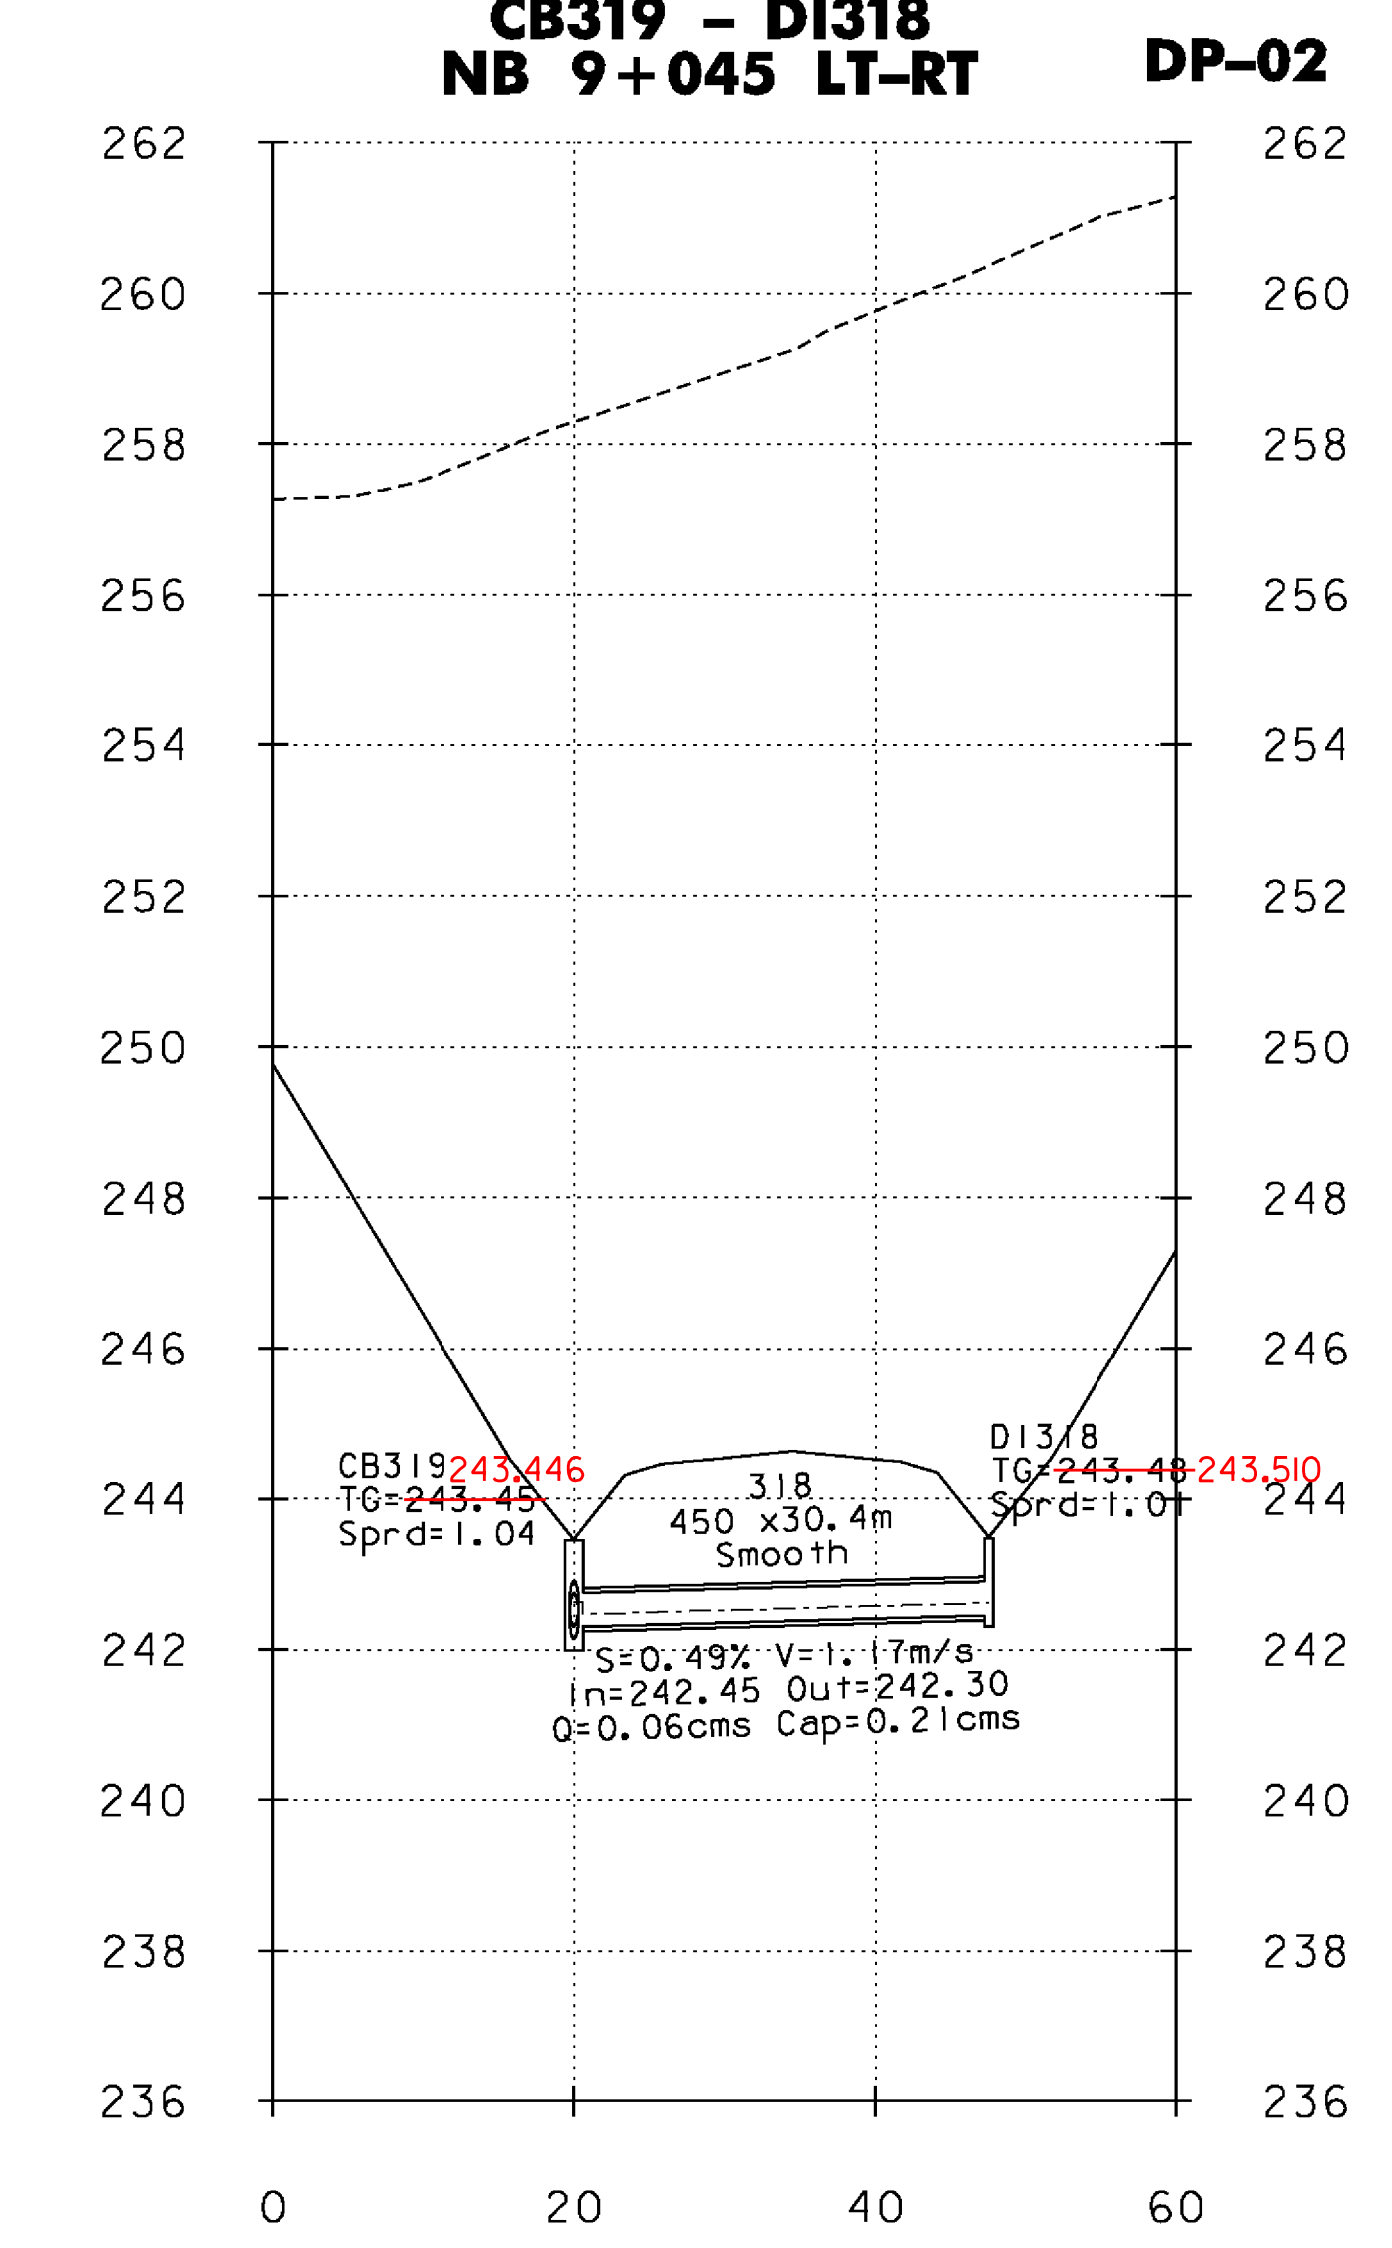
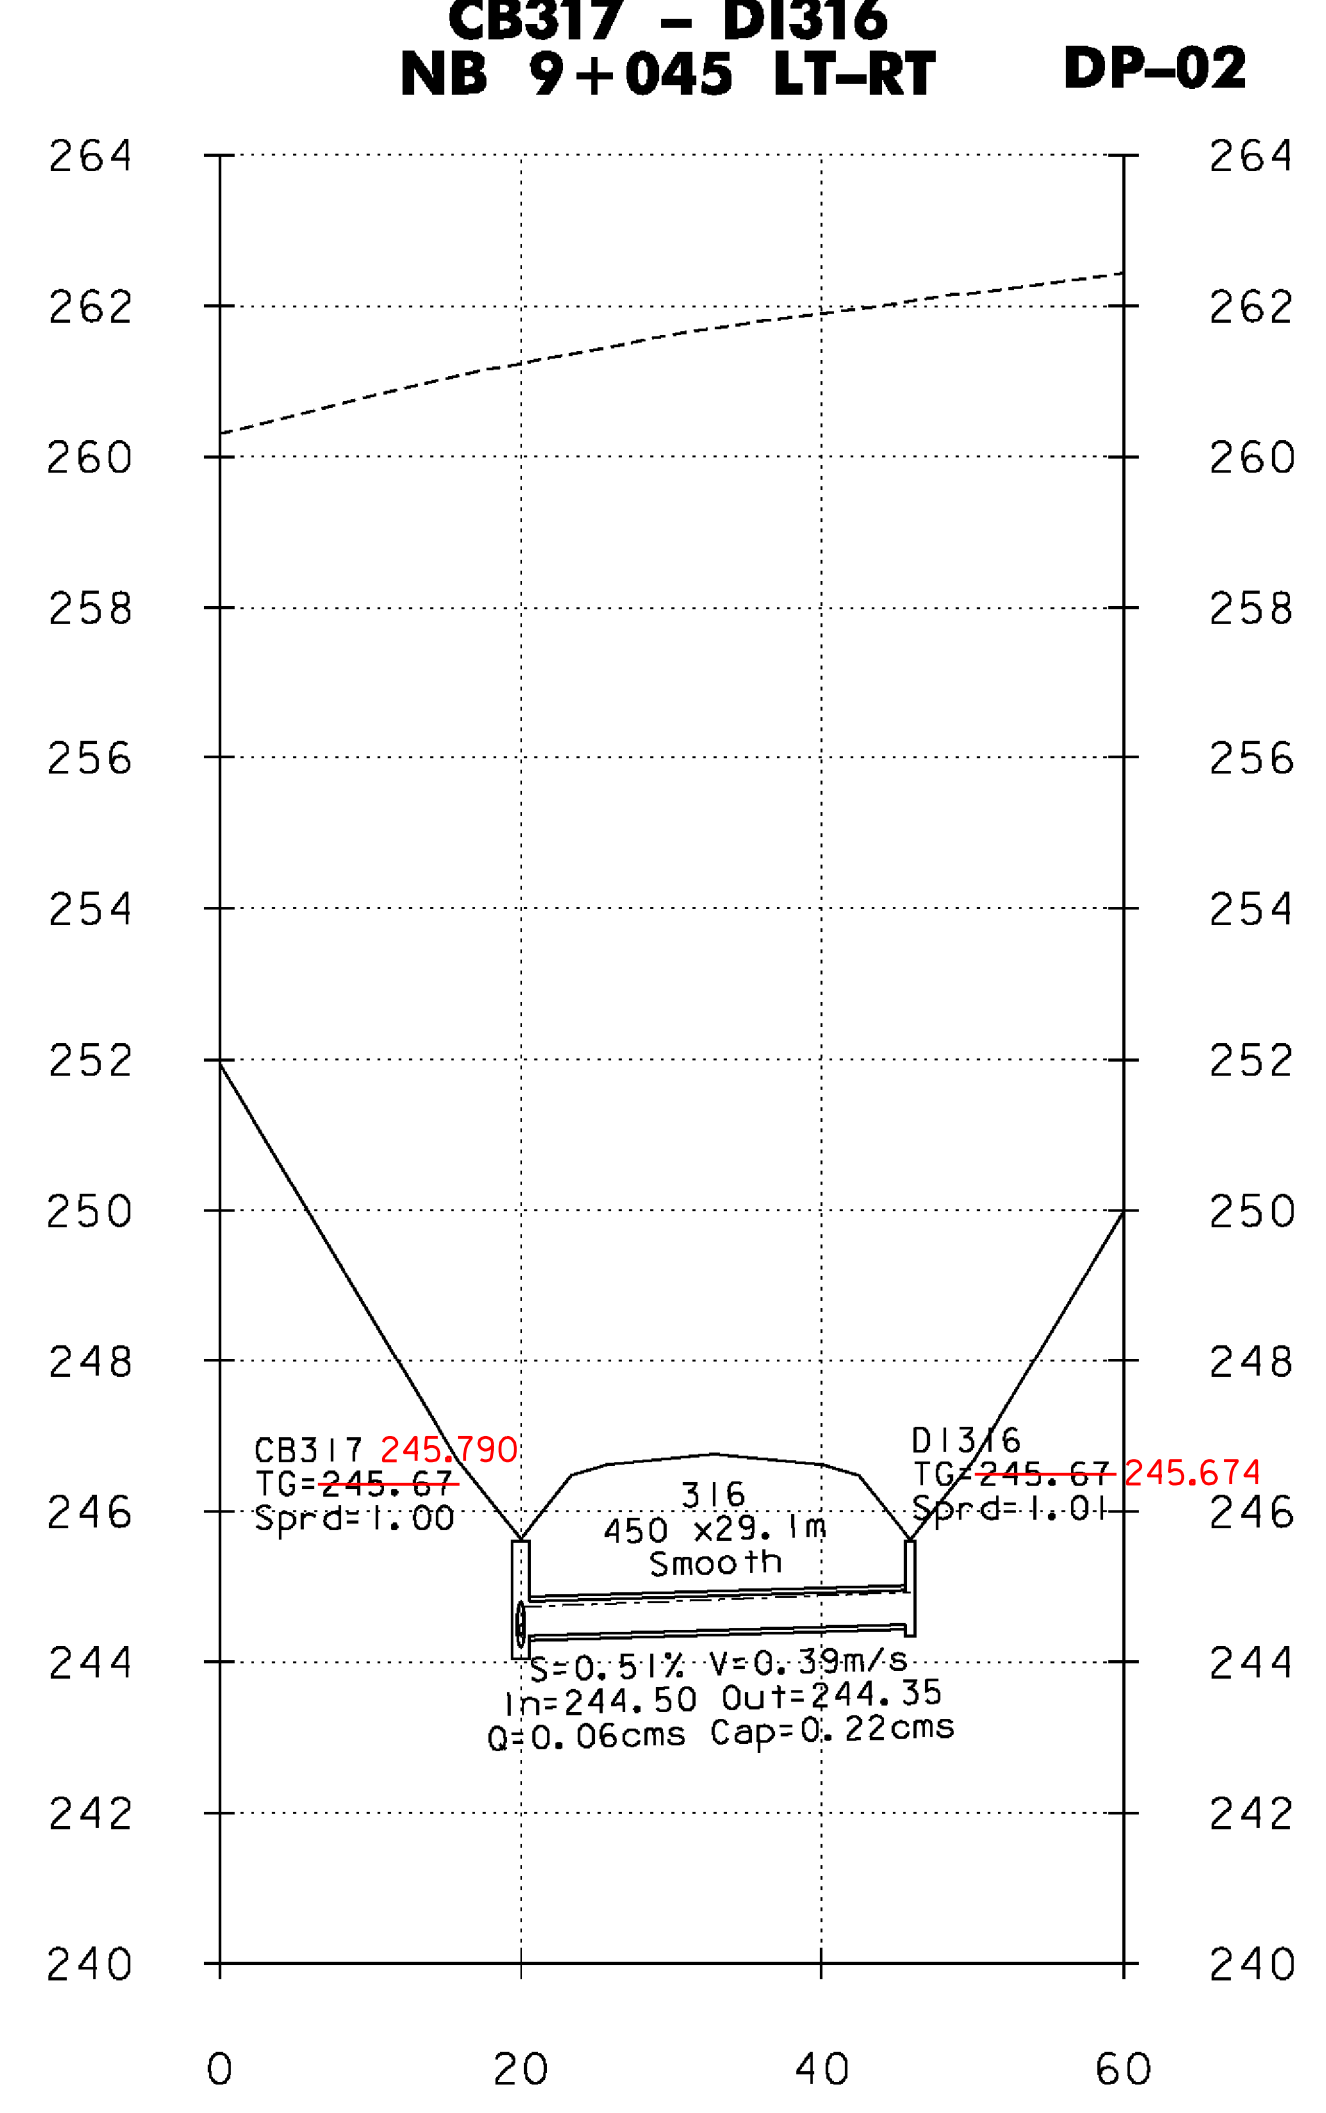
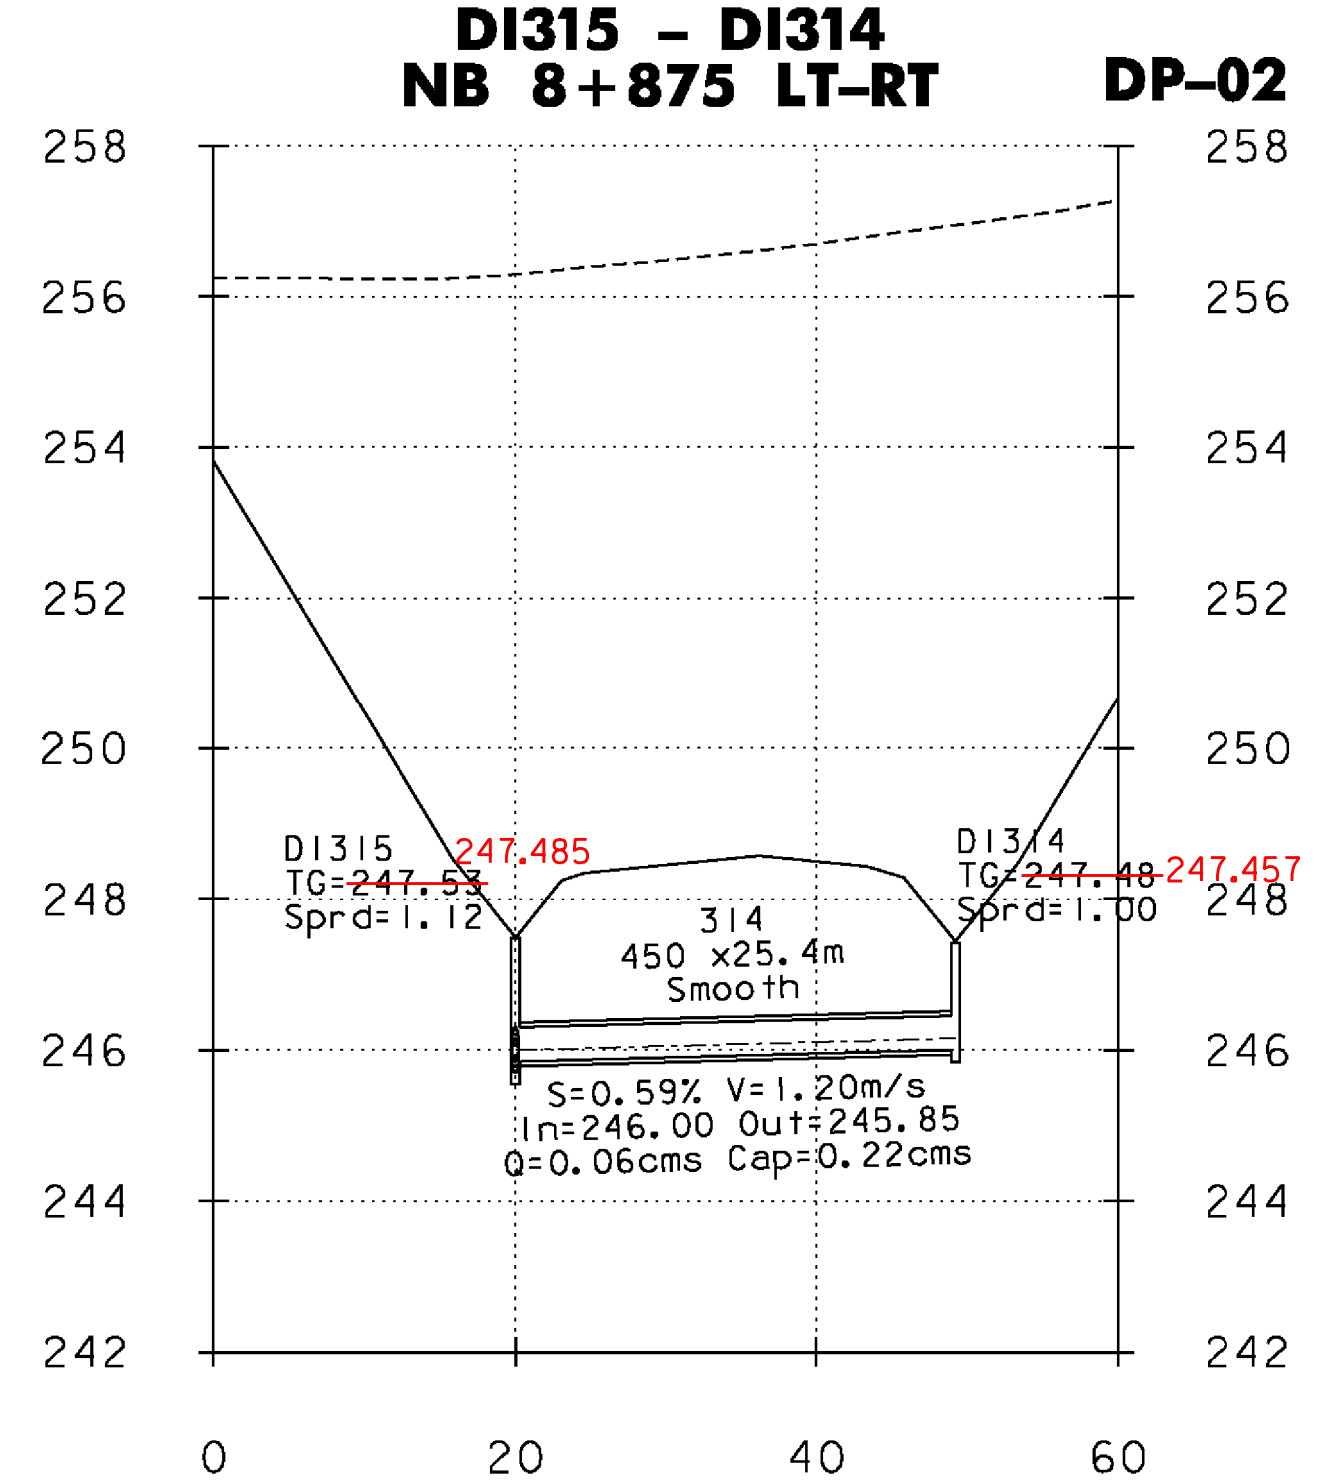


DP-XX = REFERENCE TO CORRESPONDING DRAINAGE PLAN SHEET

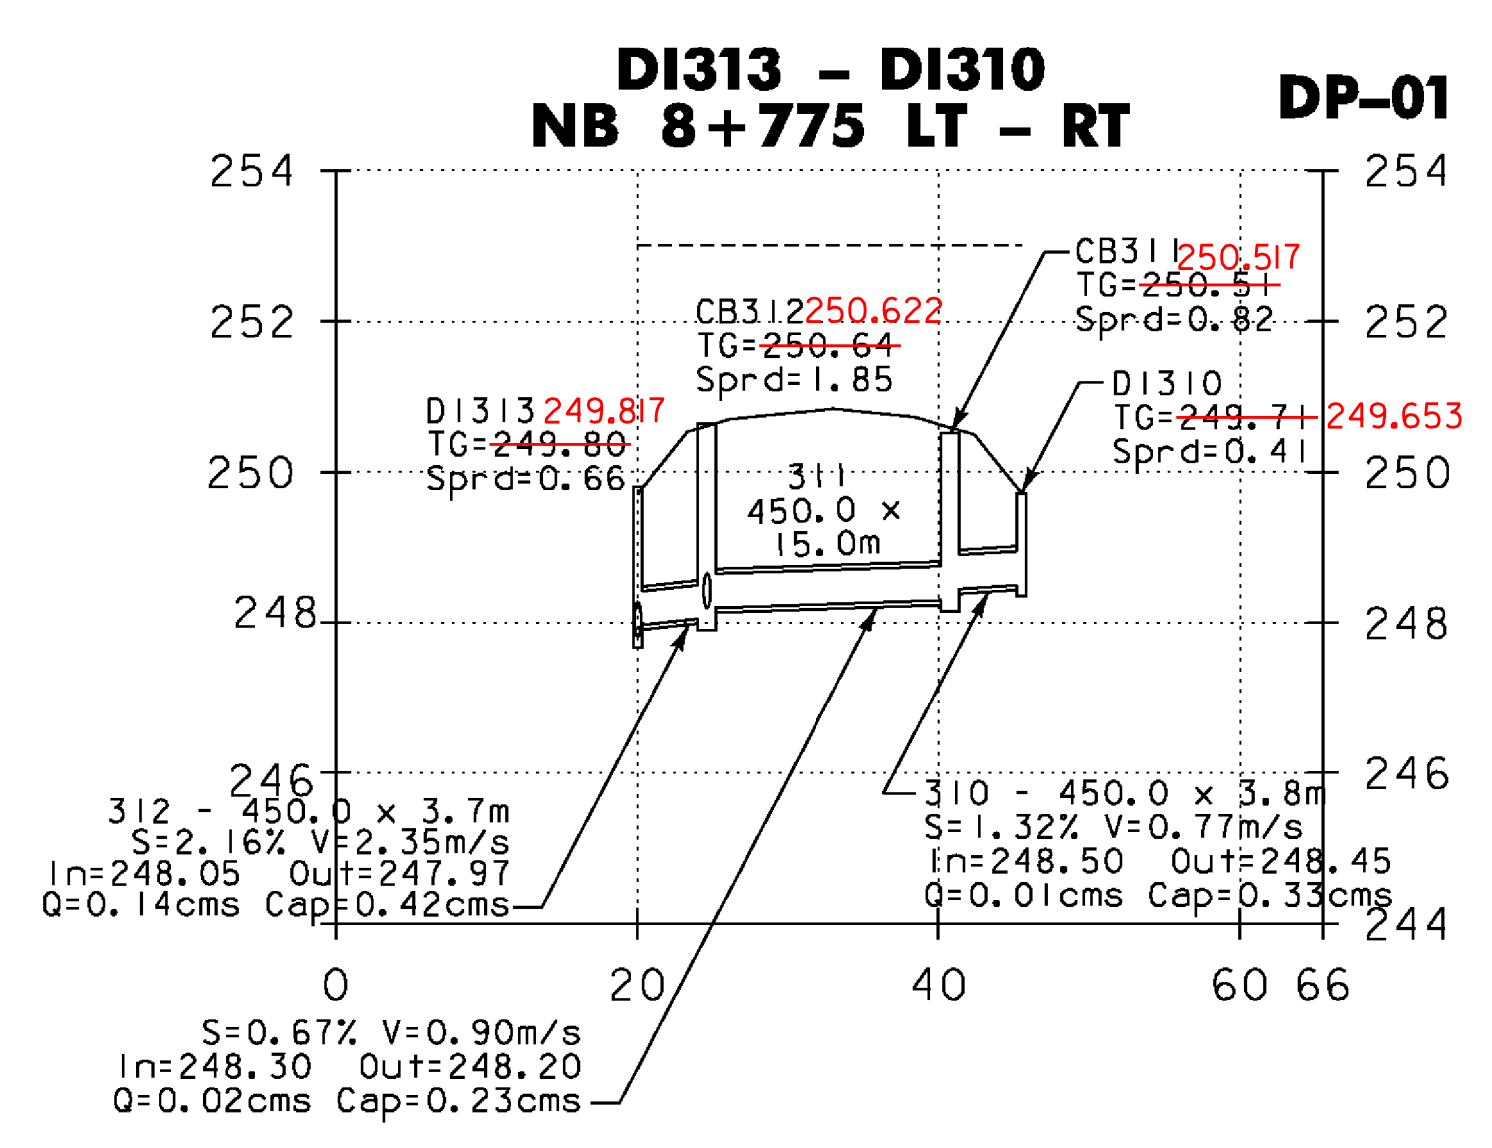

NOTE: ALL DIMENSIONS ARE IN MILLIMETERS (mm) EXCEPT WHERE NOTED.

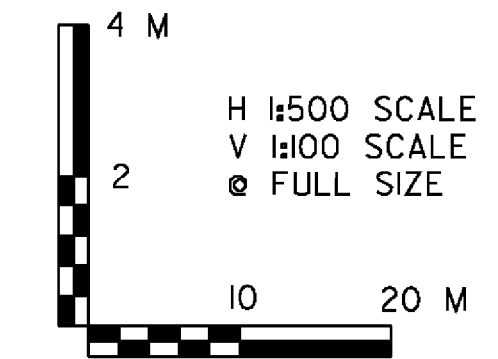

SYSTEM 3

VERMONT AGENCY OF TRANSPORTATION

	PROJECT NAME: BENNINGTON
	PROJECT NUMBER: AC NH 019-1(53)
FILE NAME: ...plot_files\zd307c3drn.pro.ptf	PLOT DATE: 5/16/2011
DESIGN SUPERVISOR: GREG EDWARDS	DRAWN BY: STANTEC
DESIGNED BY: MARC FOISY	CHECKED BY: GARY SANTY
DRAINAGE PROFILE SHEET 5	
SHEET 107 OF 577	

vr:\953\active\9530002\transportation\draining\contract\3\plot_files\zd307c3drn.pro.ptf