
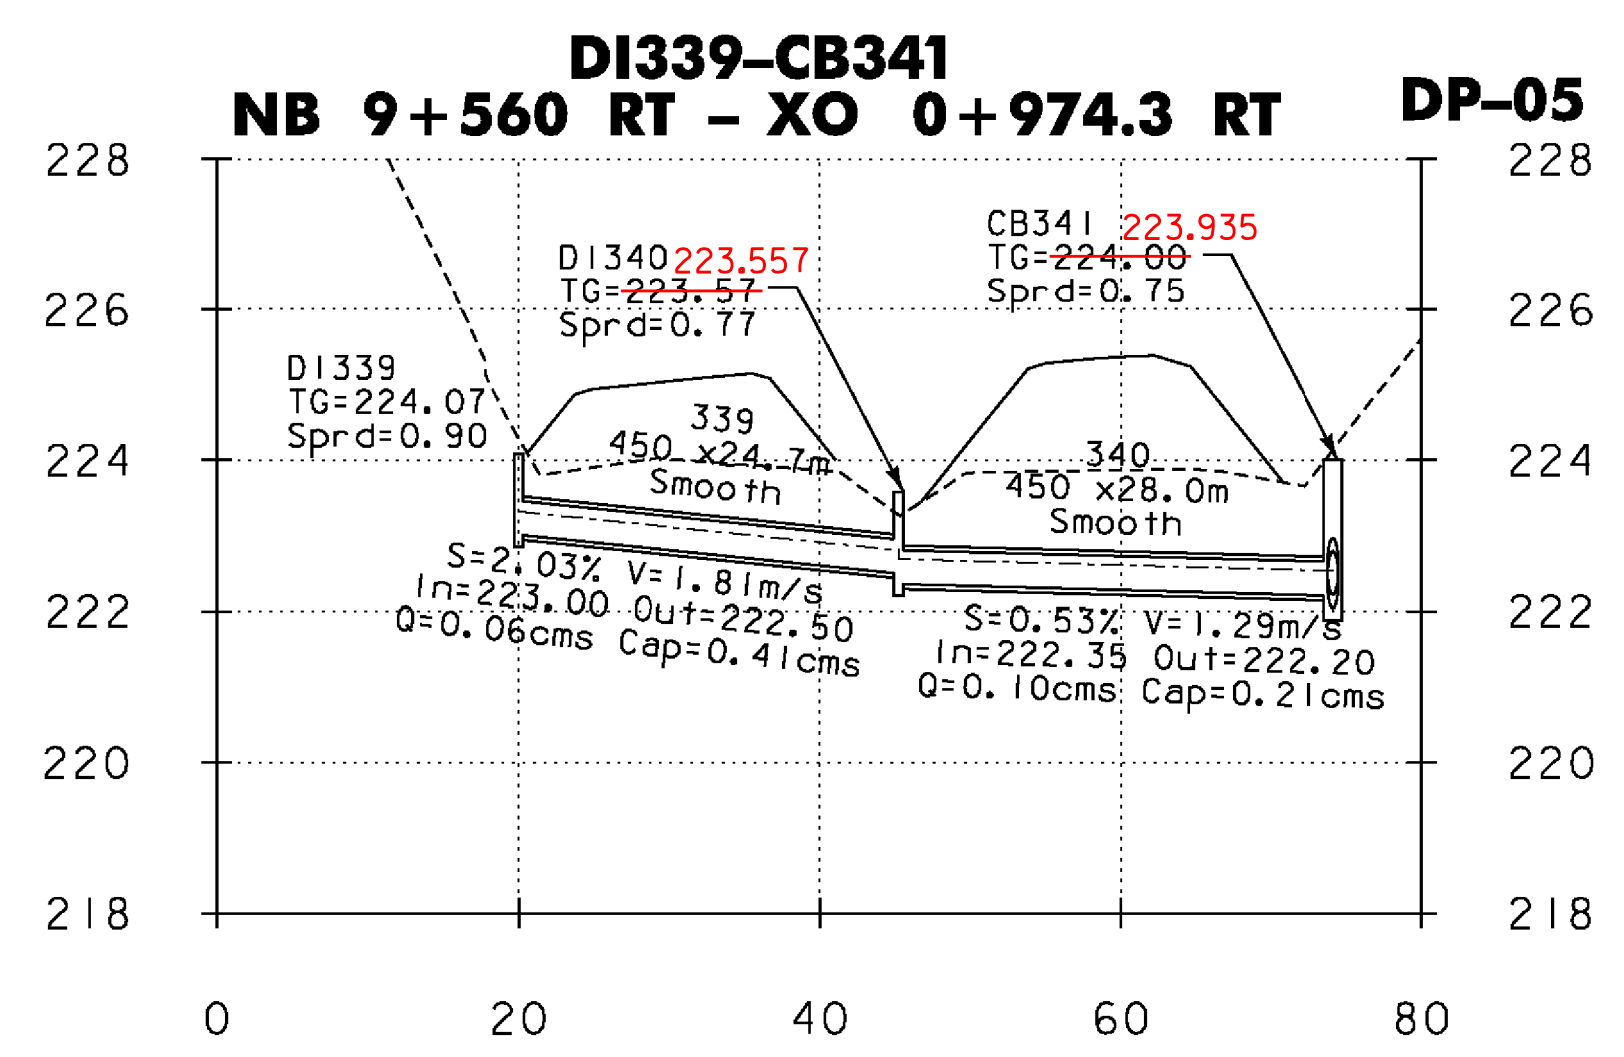
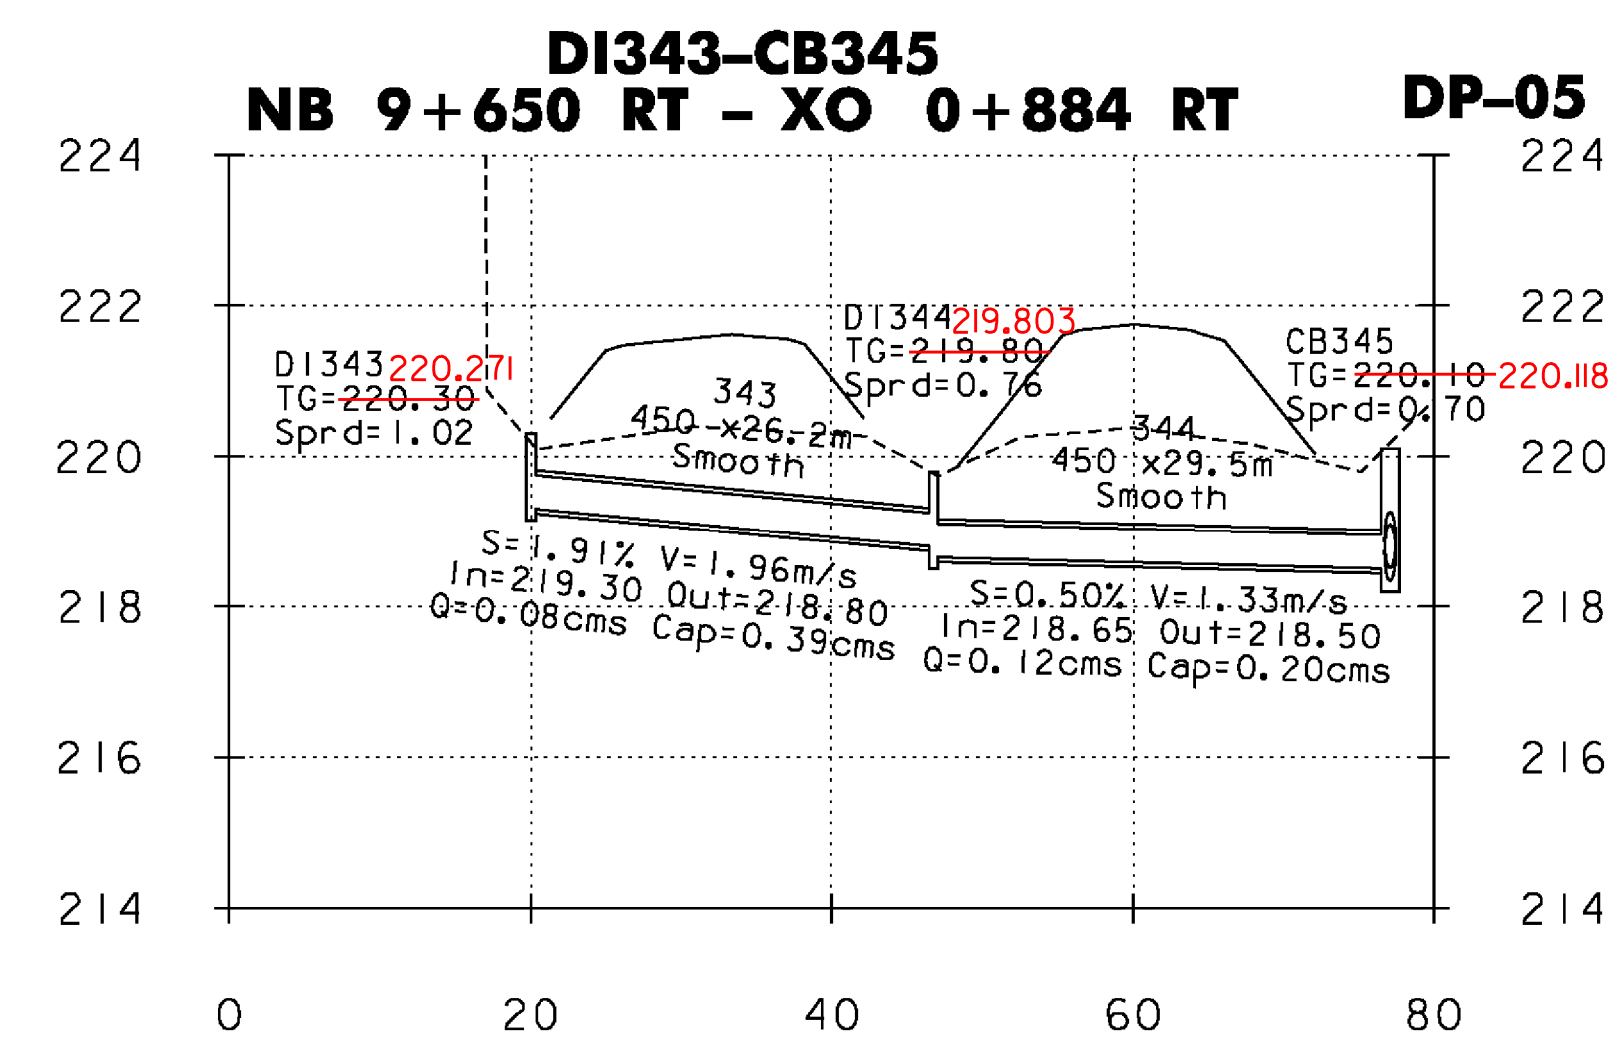
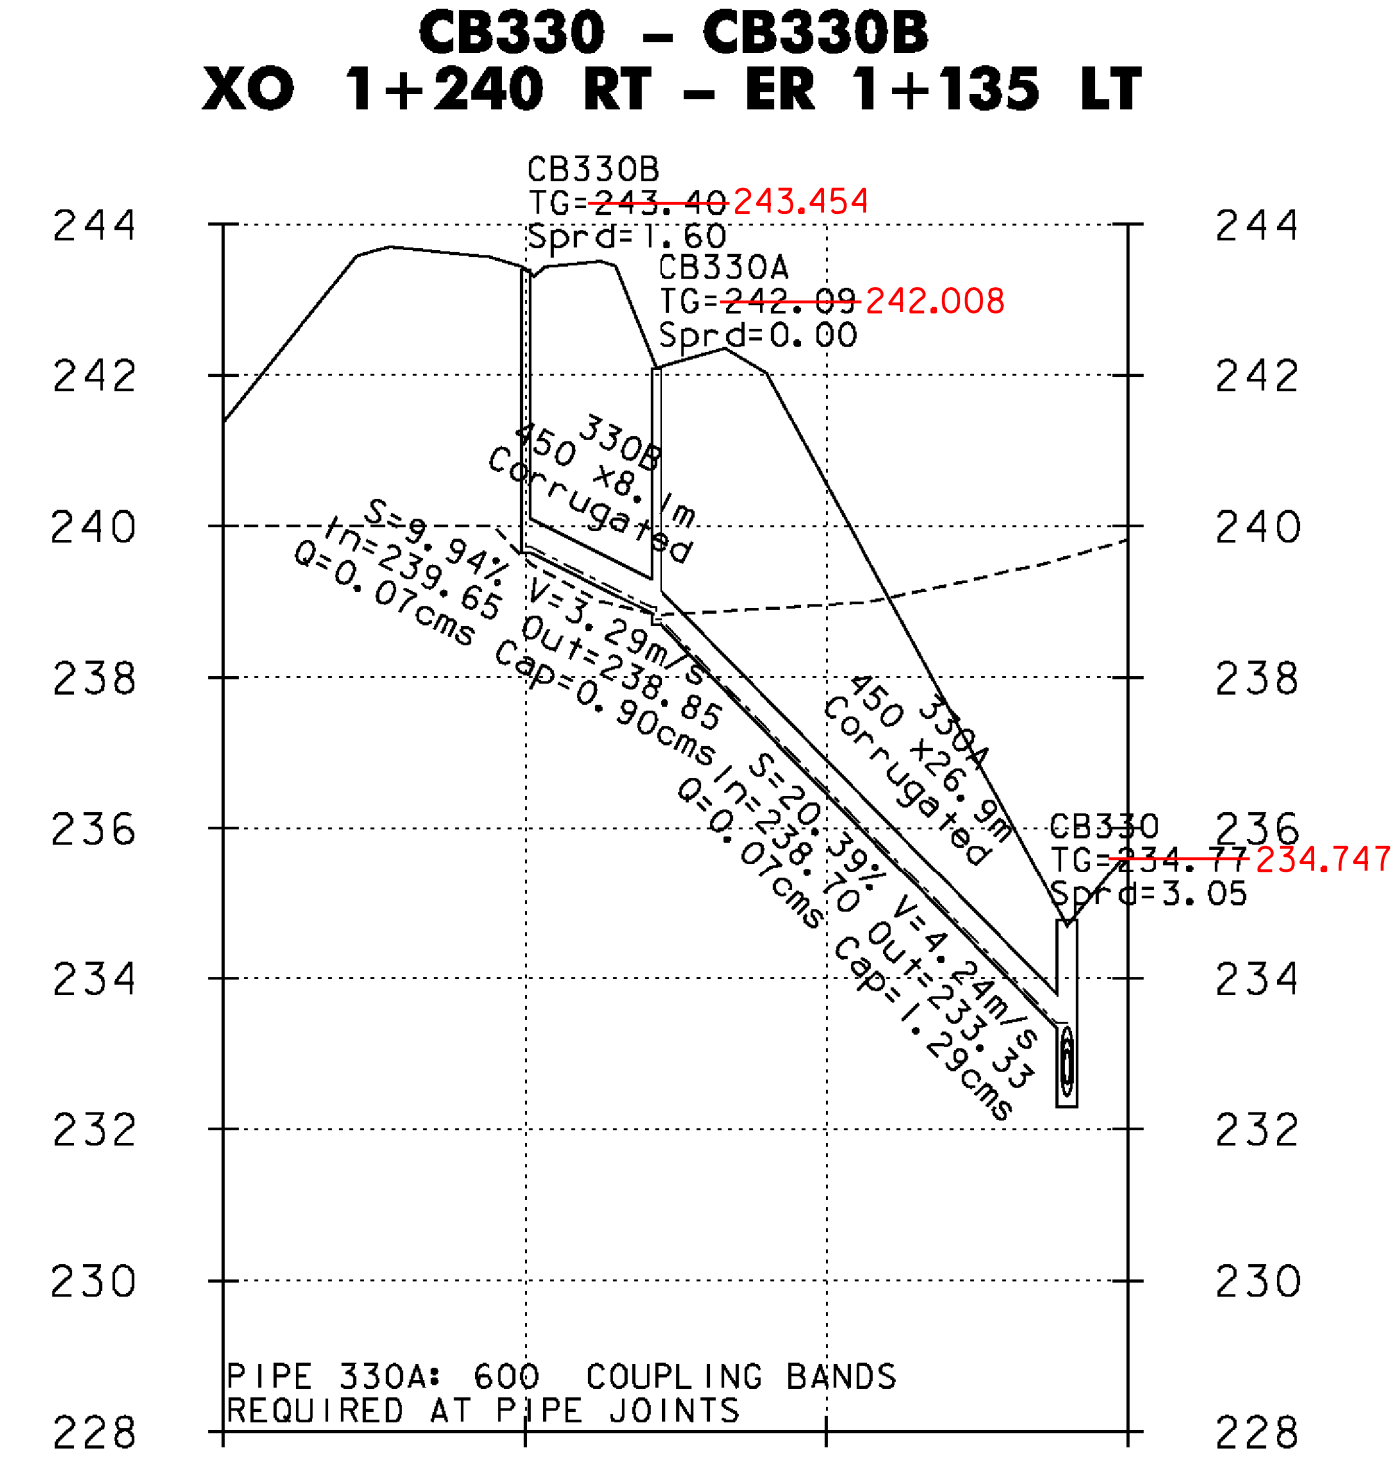
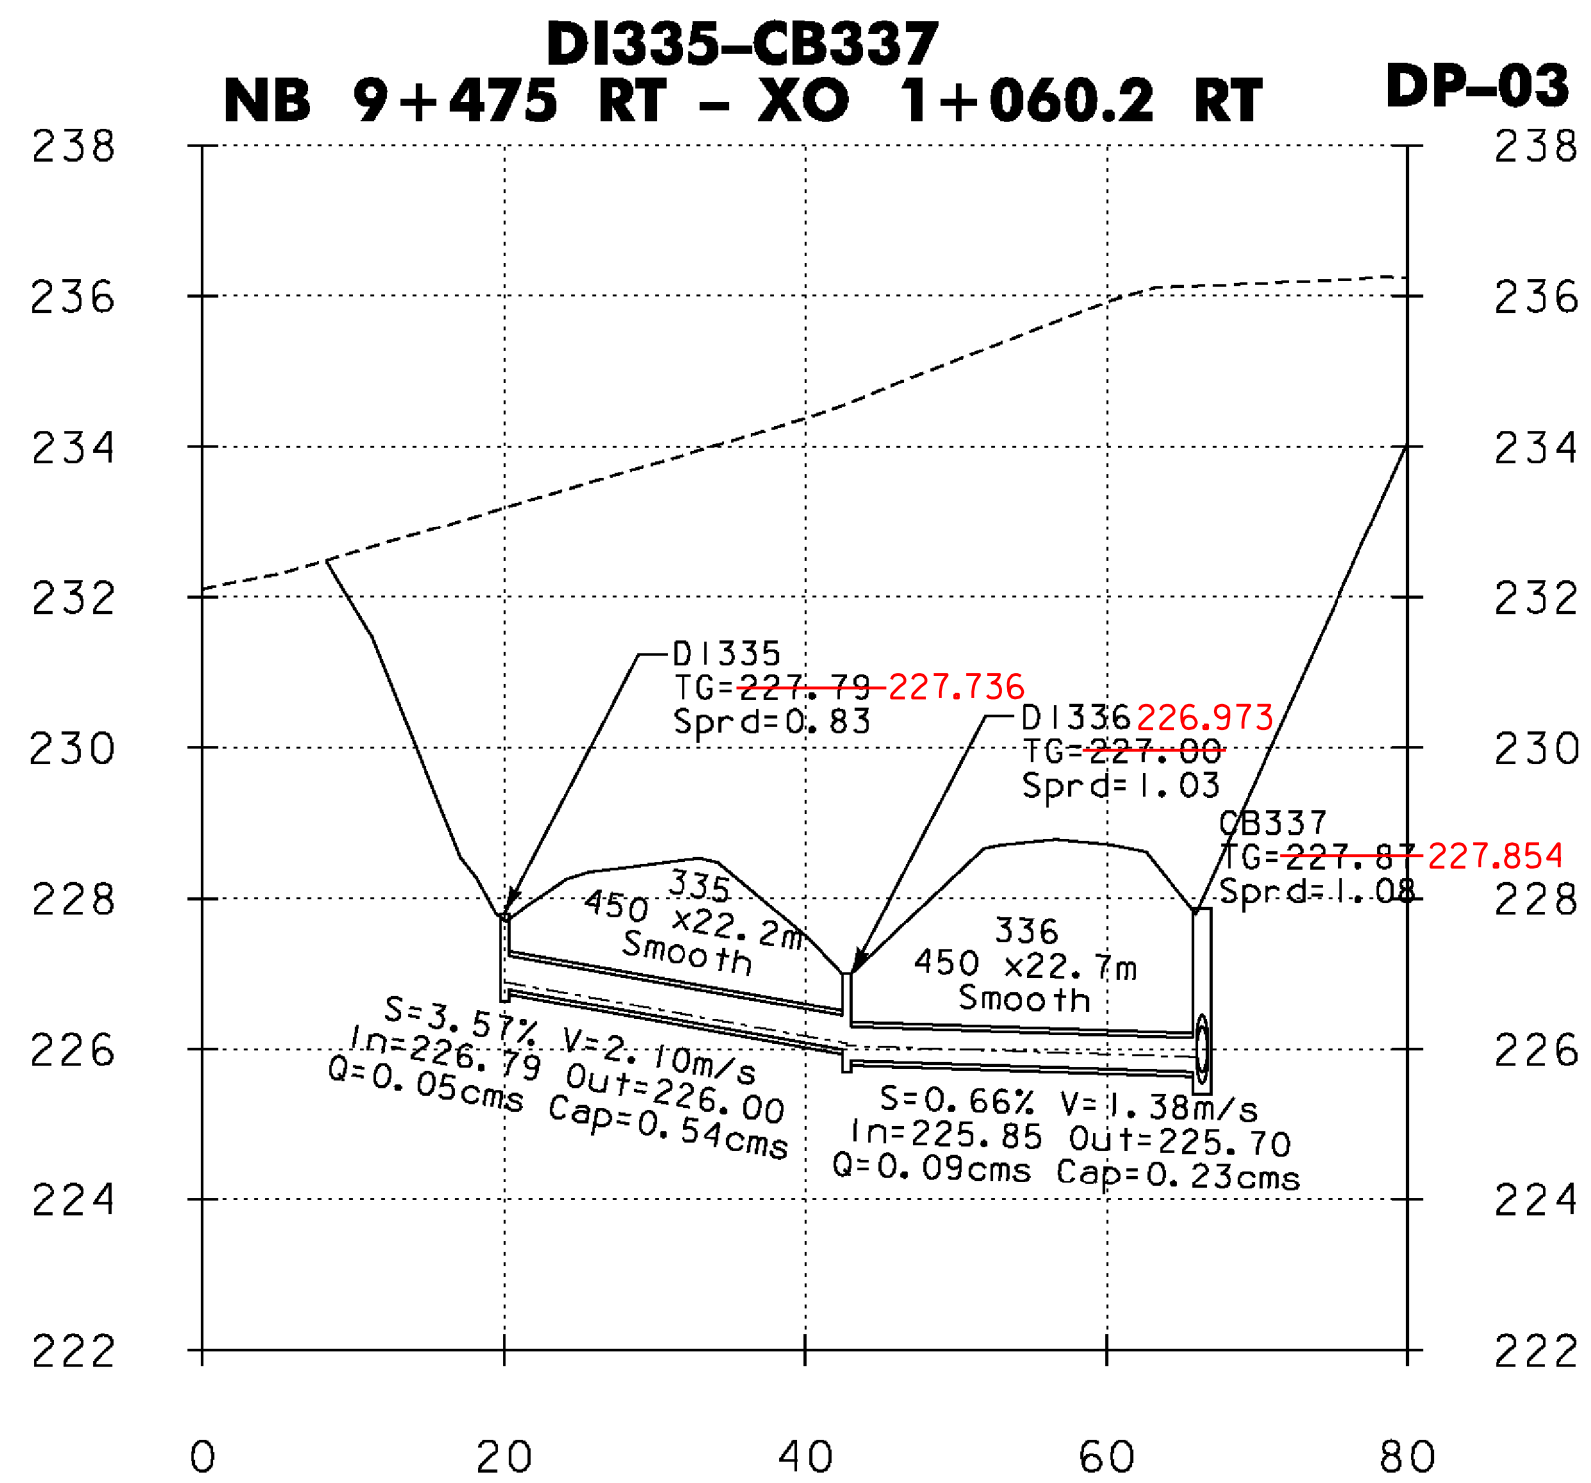
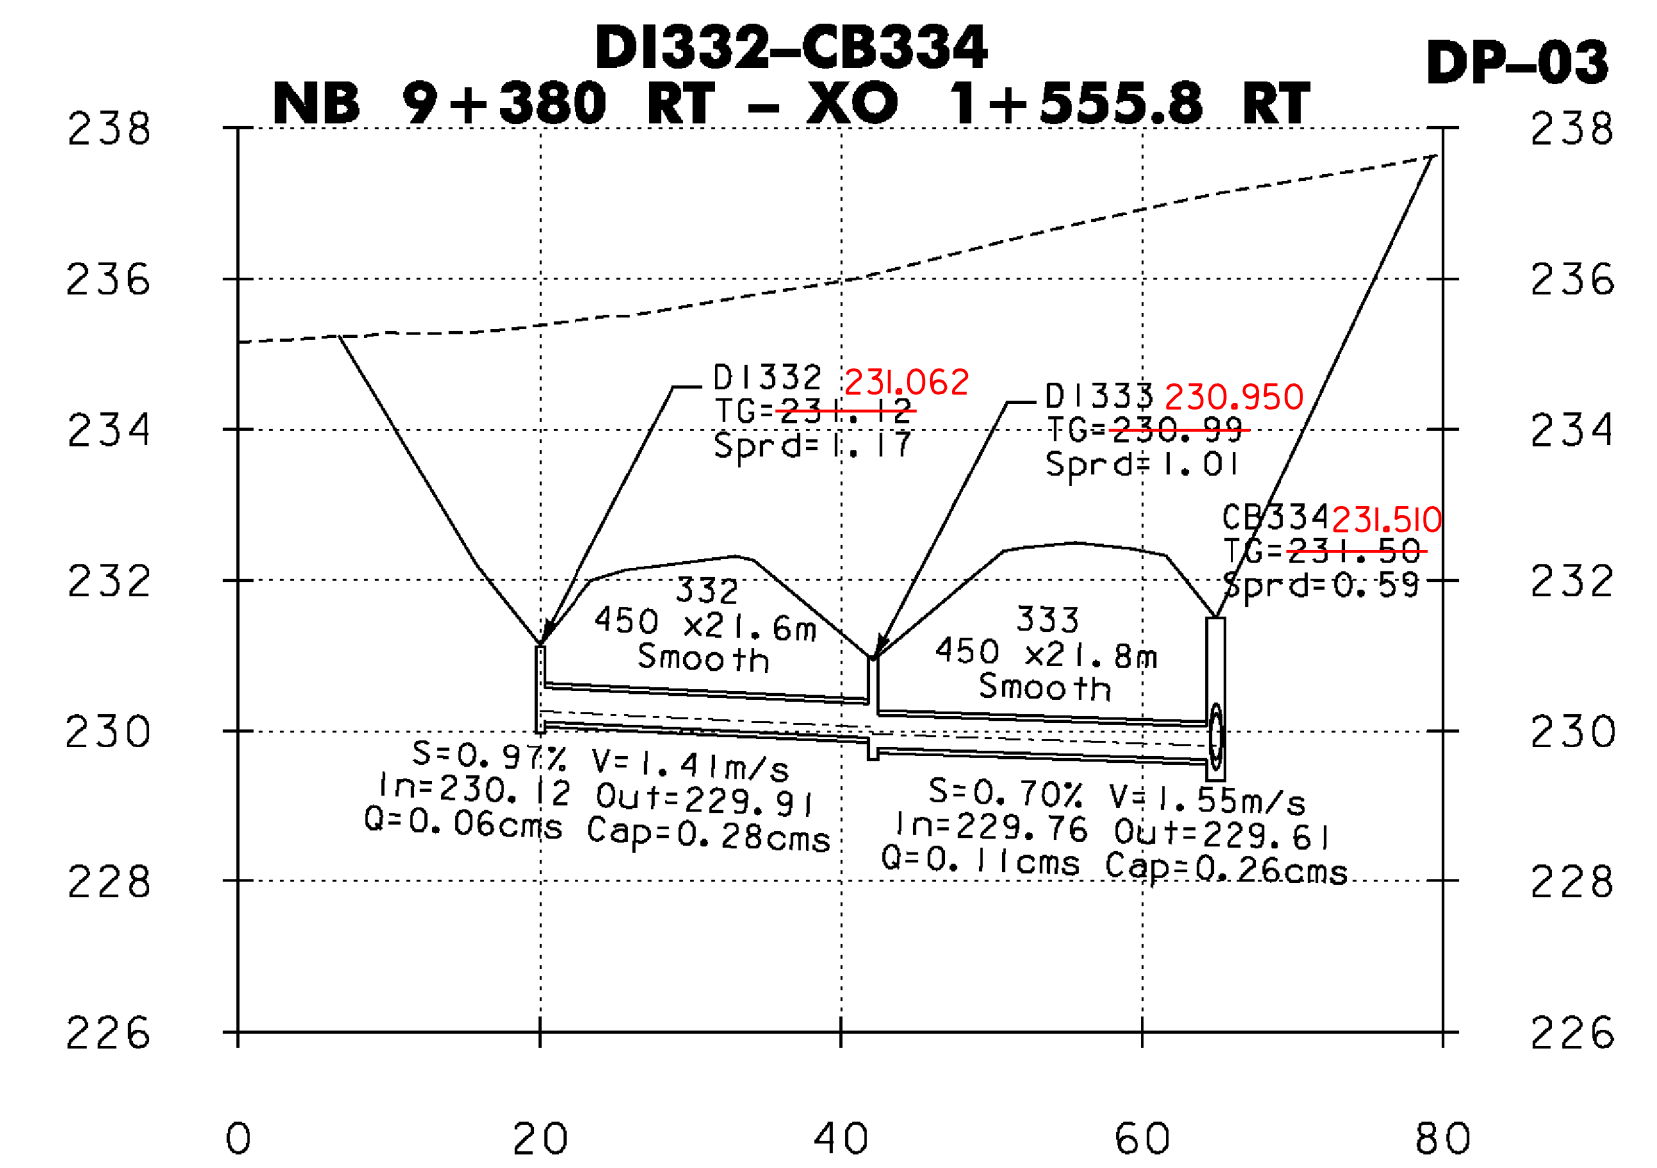
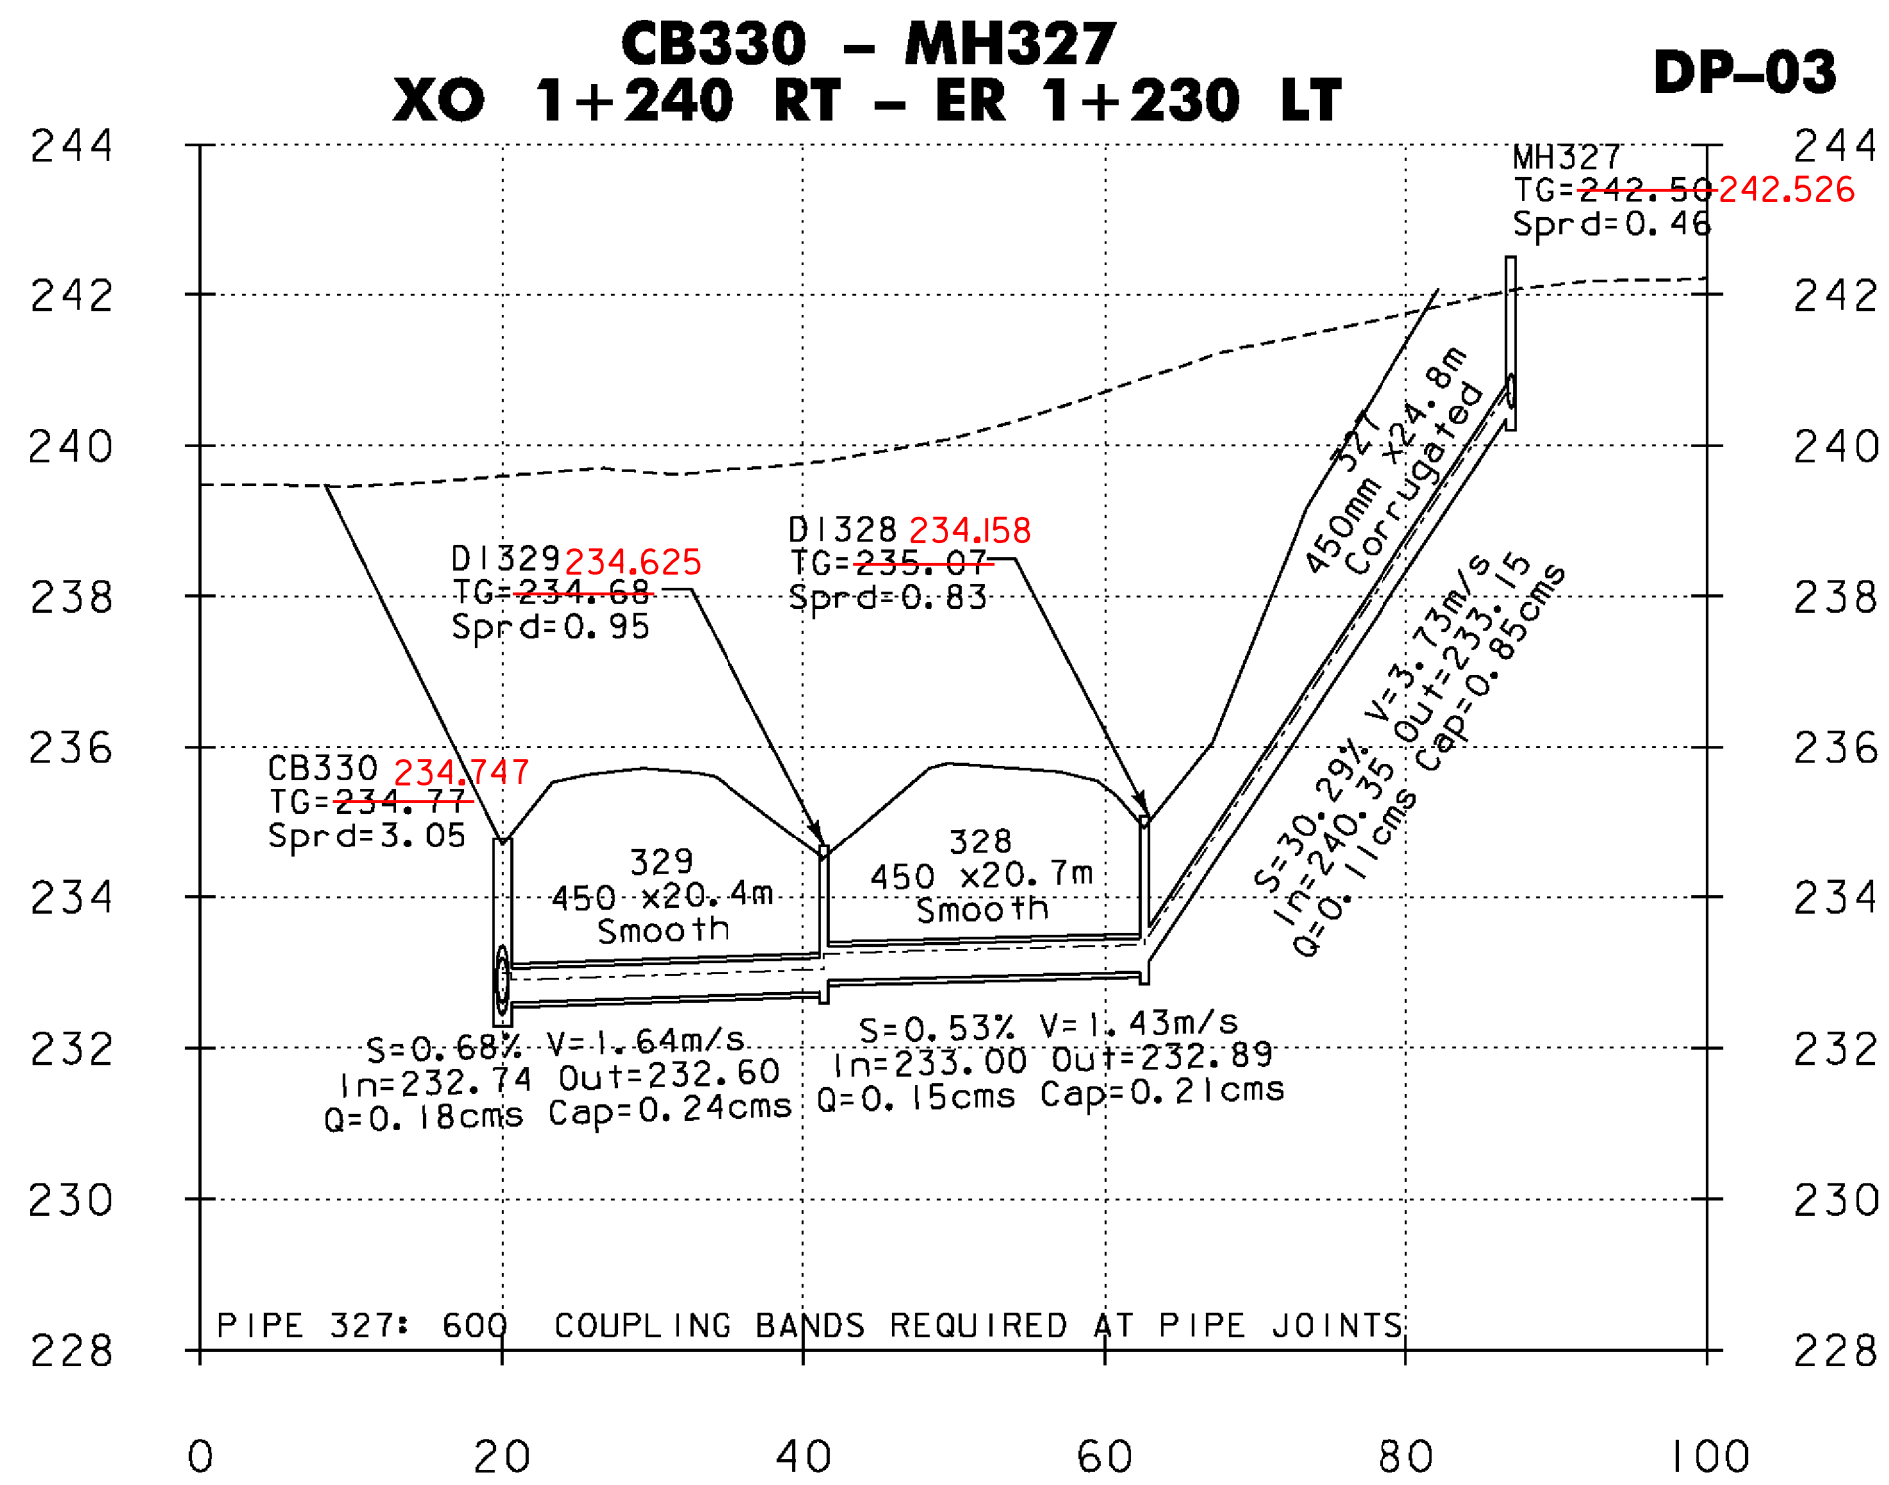


DP-XX = REFERENCE TO CORRESPONDING DRAINAGE PLAN SHEET

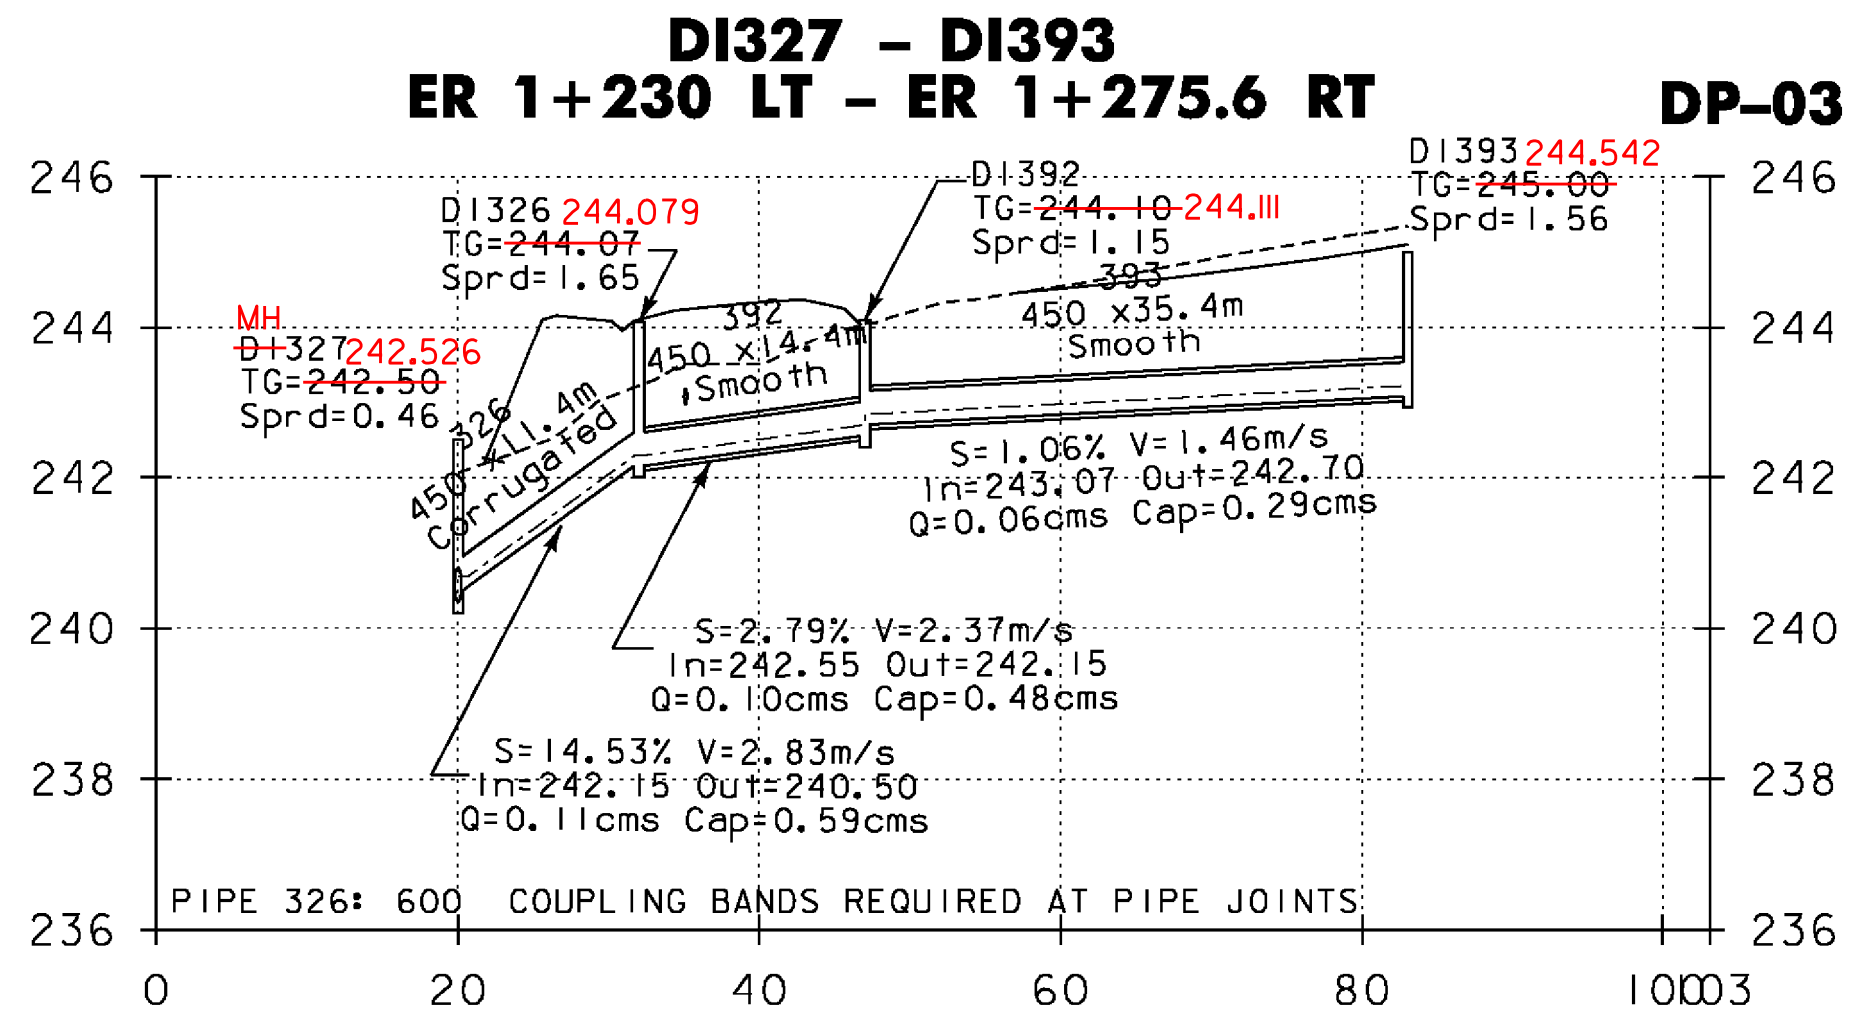


NOTE: ALL DIMENSIONS ARE IN MILLIMETERS (mm) EXCEPT WHERE NOTED.

SYSTEM 3

VERMONT AGENCY OF TRANSPORTATION



PROJECT NAME: BENNINGTON
PROJECT NUMBER: AC NH 019-(K53)
FILE NAME: ...plot_files\zd307c3drn_pro.ptf PLOT DATE: 5/16/2011
DESIGN SUPERVISOR: GREG EDWARDS DRAWN BY: STANTEC
DESIGNED BY: MARC FOISY CHECKED BY: GARY SANTY
DRAINAGE PROFILE SHEET 6 SHEET 108 OF 577

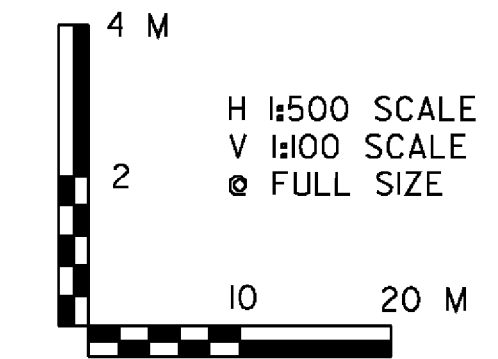

vr:\953\active\9530002\transportation\draining\contract_3\plot_files\zd307c3drn_pro.ptf