
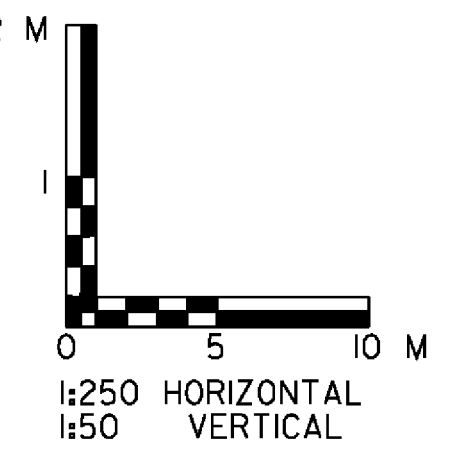
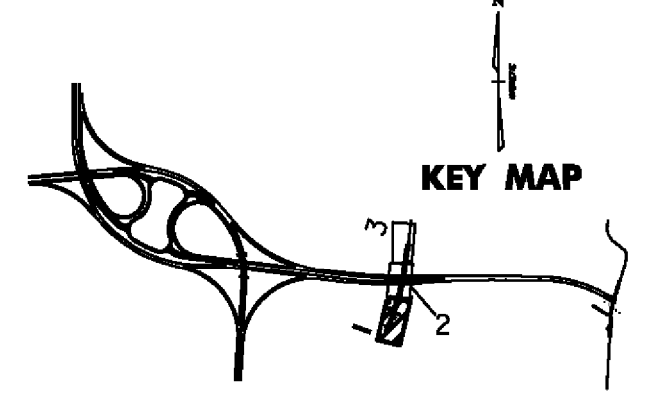


- UTILITY CONTACT INFORMATION**
- CENTRAL VERMONT PUBLIC SERVICE CORPORATION**
RANDY SCHRAMM, (802) 375-8053, ETC. 109 (DISTRIBUTION LINES)
 - VERIZON NEW ENGLAND, INC.**
BRIAN GRESL, (802) 747-1051 OR,
STEVE ATKINS (802) 257-5070 (OFFICE), (802) 254-1628 (CELL)
 - COMCAST (FORMERLY KNOWN AS MOUNTAIN CABLE COMPANY, L.P., D/B/A ADELPHIA CABLE COMMUNICATIONS, INC.)**
IVAN PELLE, (802) 447-1534, EXT. 306
 - LEVEL 3 COMMUNICATIONS (FORMERLY KNOWN AS TELCOVE OF VERMONT)**
MARK TESSIER, (802) 776-1111 (OFFICE), (802) 363-0266 (CELL)
 - TOWN OF BENNINGTON**
TERRANCE MORSE, WATER RESOURCES SUPERINTENDENT,
(802) 442-1037

LEGEND

TEMPORARY WATER	-----
TEMPORARY SEWER	-----
PERMANENT WATER	— PW —
PERMANENT SEWER	— PS —
EXISTING WATER	— W —
EXISTING SEWER	— S —

NOTE:
FOR MORE INFORMATION ON TEMPORARY UTILITY CONNECTIONS SEE SHEETS TU-01 THRU TU-03

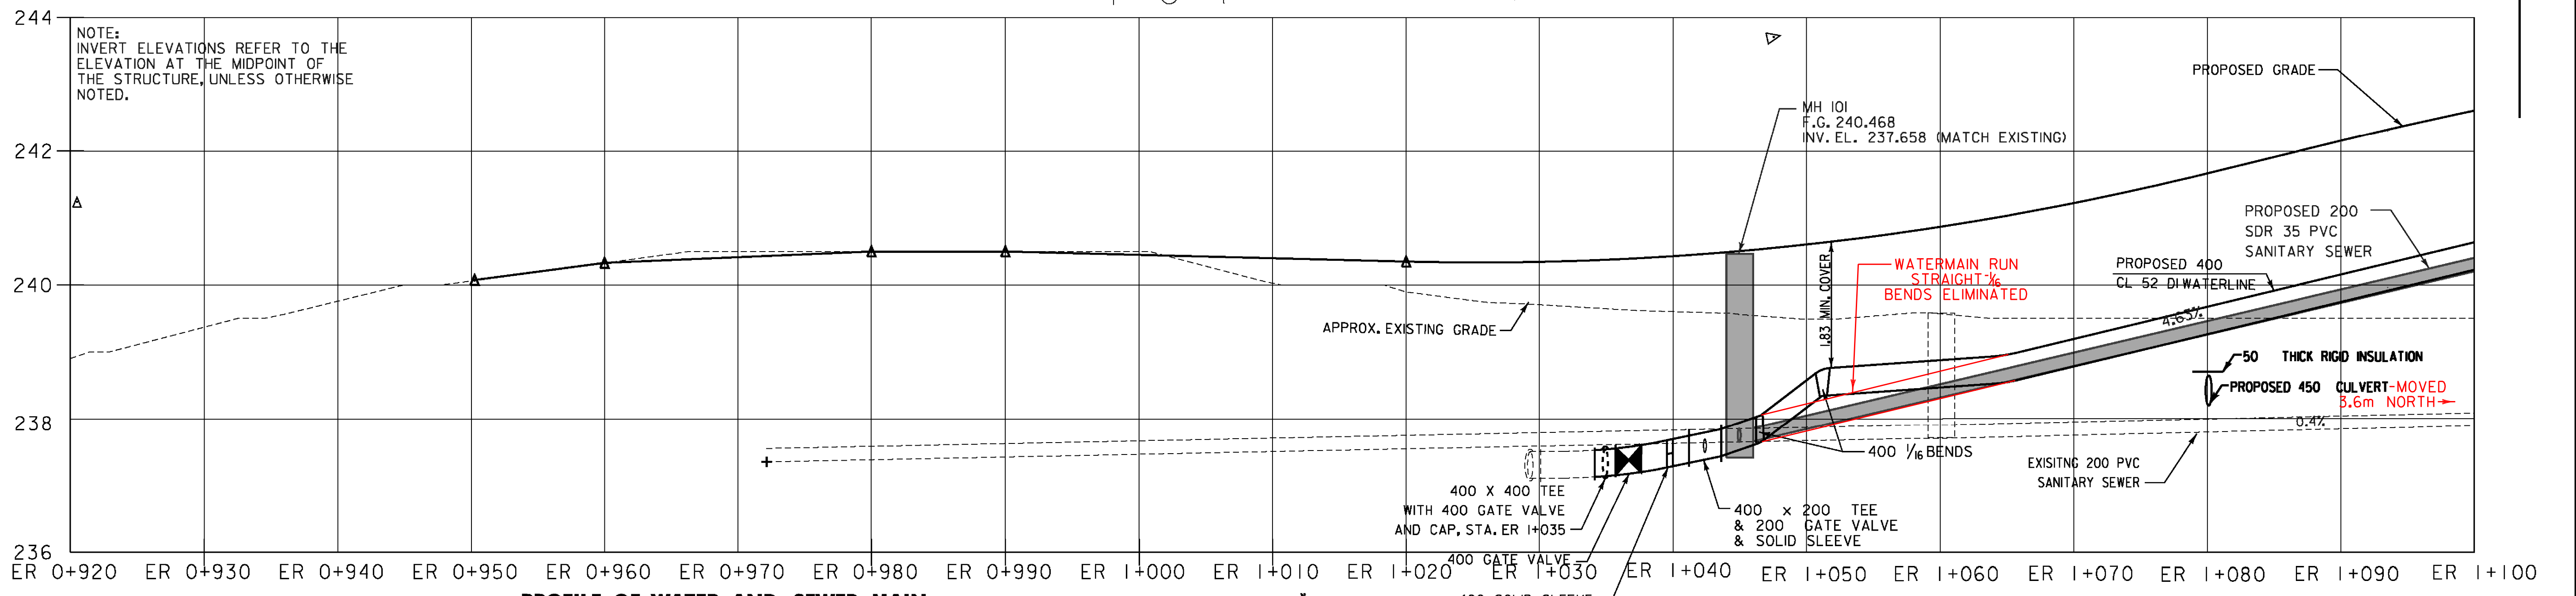

NOTE: ALL DIMENSIONS ARE IN MILLIMETERS (mm) EXCEPT WHERE NOTED.

VERMONT AGENCY OF TRANSPORTATION

PROJECT NAME: BENNINGTON
PROJECT NUMBER: AC NH 019-1(53)

FILE NAME: ...\\plot_files\zd30763utl.lpf PLOT DATE: 5/25/2011
DESIGN SUPERVISOR: GREG EDWARDS DRAWN BY: STANTEC
DESIGNED BY: T. KNIGHT CHECKED BY: M. CHENETTE
UTILITY PLAN U-01 SHEET 155 OF 577

va:\953\active\1953002\transportation\drawing\cont\tr-act-3\plot_files\zd30763utl.lpf

MATCH LINE STA. ER 1+100.2, SEE SHEET U-02