
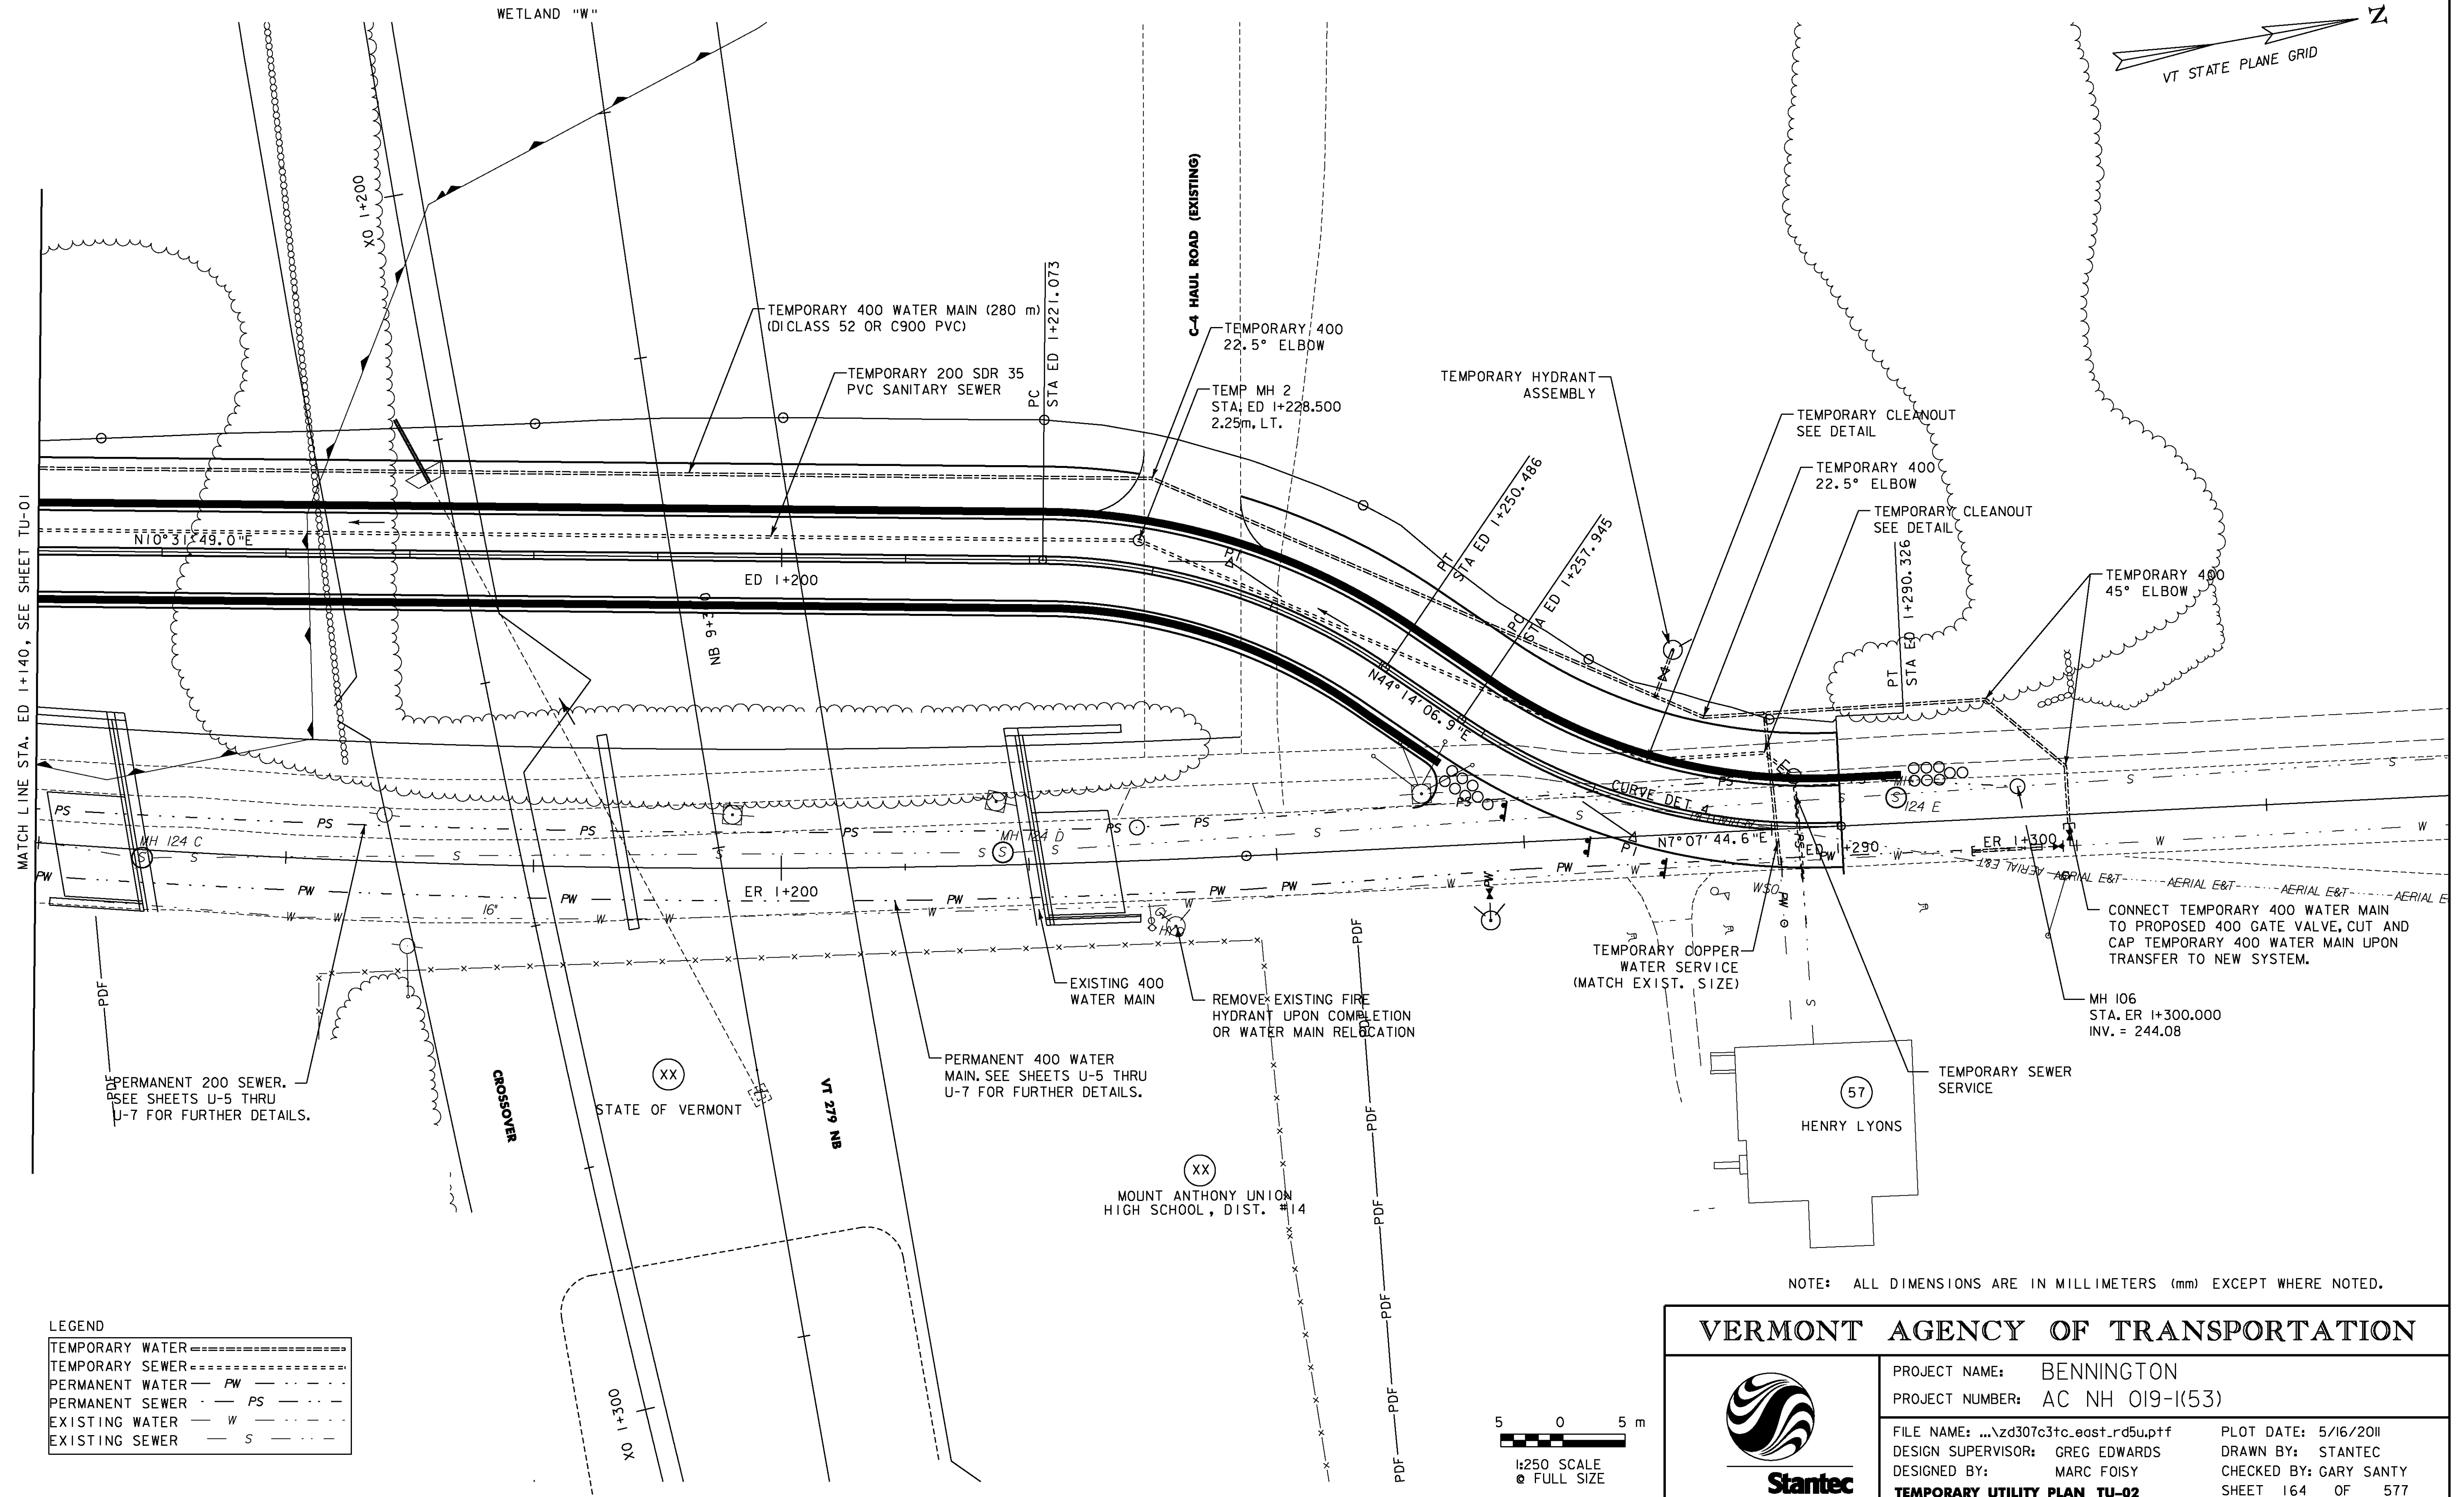


**UTILITY NOTES**

1. FOR ALL SEWER GENERAL NOTES REFER TO SHEET TC-4.

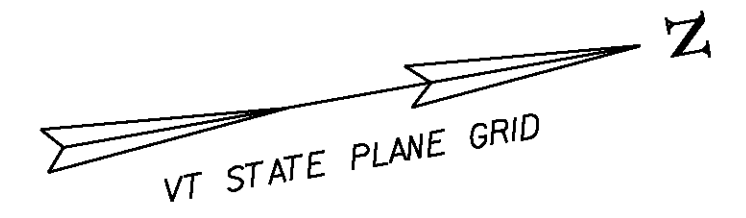

MATCH LINE STA. ED 1+140, SEE SHEET TU-01


**LEGEND**

TEMPORARY WATER	-----
TEMPORARY SEWER	-----
PERMANENT WATER	— PW —
PERMANENT SEWER	— PS —
EXISTING WATER	— W —
EXISTING SEWER	— S —

NOTE: ALL DIMENSIONS ARE IN MILLIMETERS (mm) EXCEPT WHERE NOTED.

**VERMONT AGENCY OF TRANSPORTATION**

	PROJECT NAME: BENNINGTON
	PROJECT NUMBER: AC NH 019-(153)
	FILE NAME: ...\\zd307c3tc.east.rd5u.ptf
	DESIGN SUPERVISOR: GREG EDWARDS
DESIGNED BY: MARC FOISY	PLOT DATE: 5/16/2011
TEMPORARY UTILITY PLAN TU-02	DRAWN BY: STANTEC
	CHECKED BY: GARY SANTY
	SHEET 164 OF 577

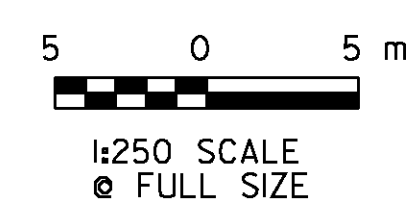

V:\953\active\9530002\transportation\drawing\contract\_3\plot\_files\zd307c3tc.east.rd5u.ptf