


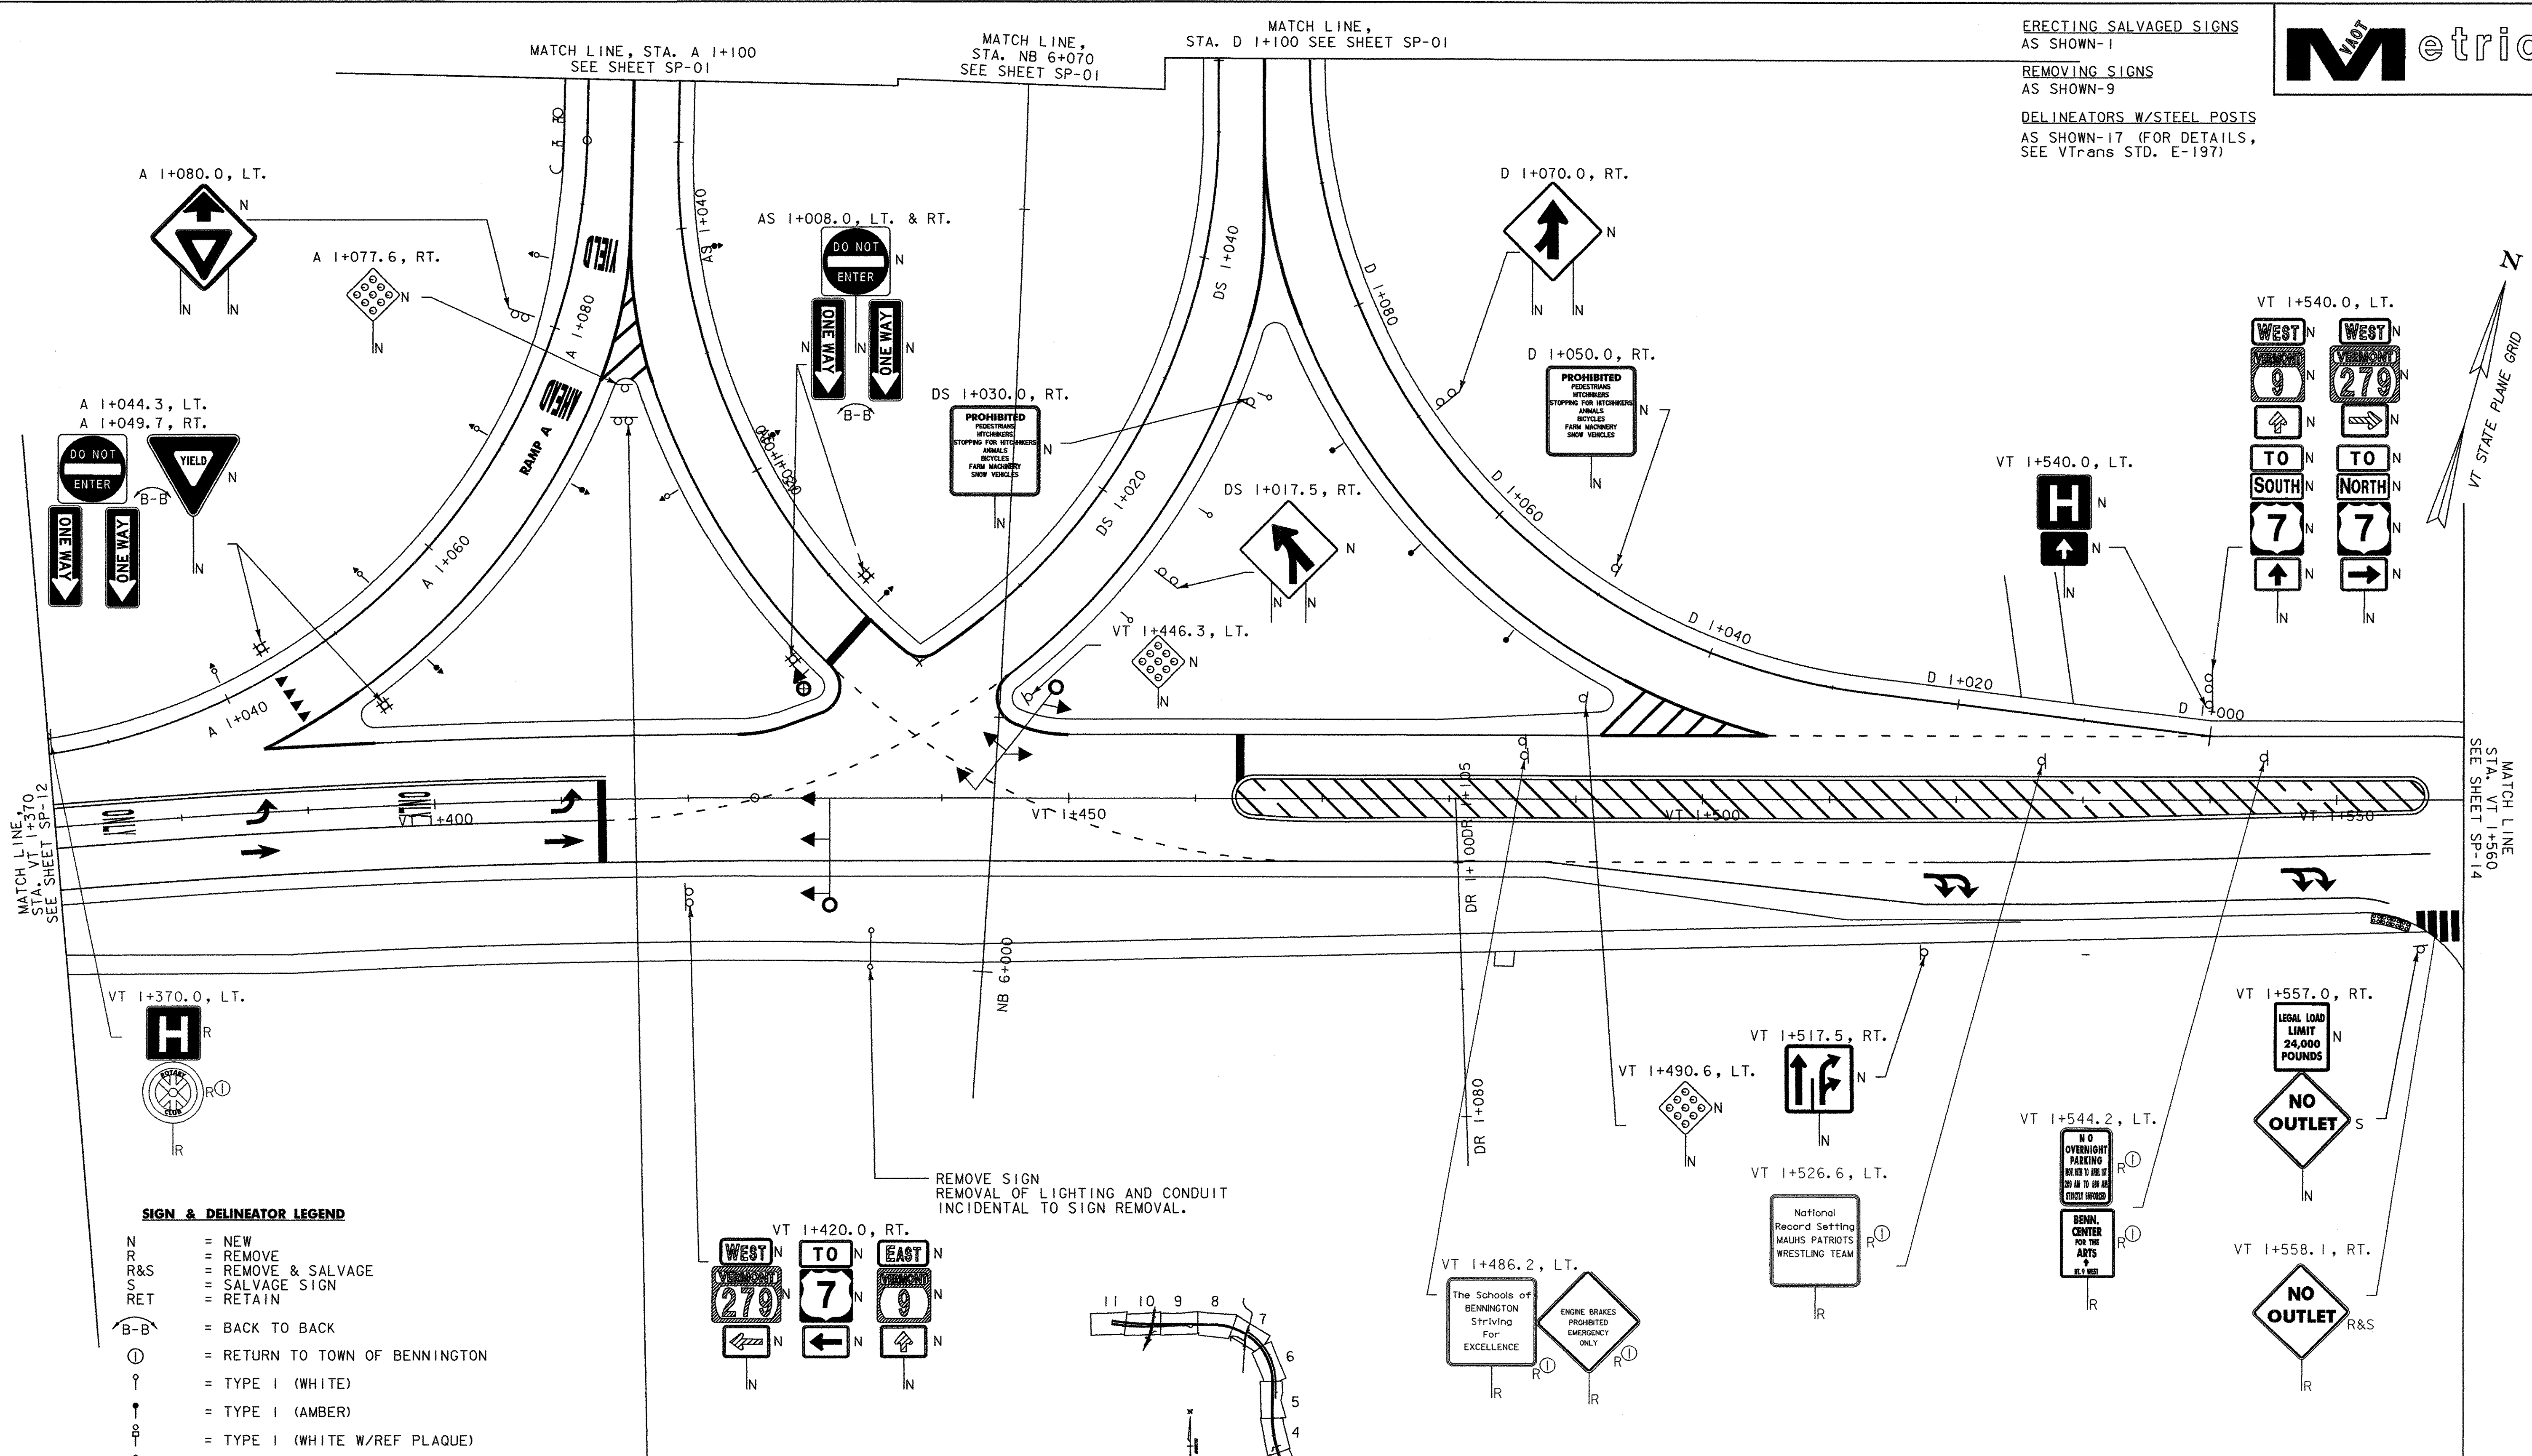

ERECTING SALVAGED SIGNS
AS SHOWN-1

REMOVING SIGNS
AS SHOWN-9


DELINEATORS W/STEEL POSTS
AS SHOWN-17 (FOR DETAILS,
SEE VTrans STD. E-197)



SIGN & DELINEATOR LEGEND

- N = NEW
- R = REMOVE
- R&S = REMOVE & SALVAGE
- S = SALVAGE SIGN
- RET = RETAIN
- B-B = BACK TO BACK
- ⊙ = RETURN TO TOWN OF BENNINGTON
- ⊙ = TYPE I (WHITE)
- ⊙ = TYPE I (AMBER)
- ⊙ = TYPE I (WHITE W/REF PLAQUE)
- ⊙ = TYPE II
- ⊙ = TYPE III (WHITE)
- ⊙ = TYPE III (AMBER)
- * = MATCH EXISTING CONDITIONS

REMOVE SIGN
REMOVAL OF LIGHTING AND CONDUIT
INCIDENTAL TO SIGN REMOVAL.

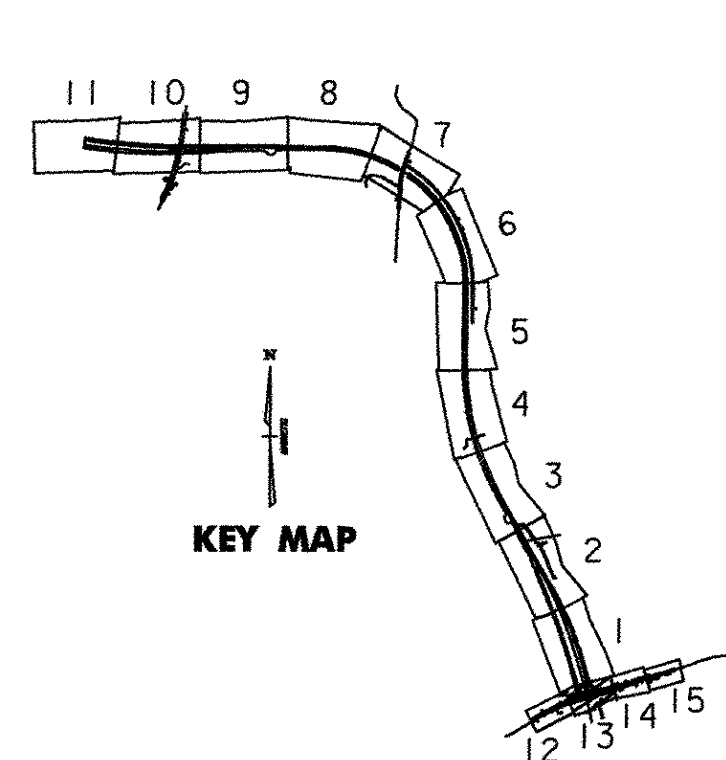

NOTE:
1) FOR FURTHER DETAILS ON LIGHTING,
SEE LIGHTING PLAN SHEET LP-06
2) FOR PROPOSED PAVEMENT MARKINGS, SEE
SHEET SP-13.

NOTE: ALL DIMENSIONS, NOTES, AND CALLOUTS IN MILLIMETERS (mm) EXCEPT AS NOTED

VERMONT AGENCY OF TRANSPORTATION



PROJECT NAME: BENNINGTON
PROJECT NUMBER: AC NH 019-1(51)

FILE NAME: ...\\plot files\zd307\clt\xt_sgn.plt PLOT DATE: 1/30/2009
DESIGN SUPERVISOR: GREG EDWARDS DRAWN BY: STANTEC
DESIGNED BY: MARC FOISY CHECKED BY: GARY SANTY
SIGNS AND MARKINGS SP-13a SHEET 122 OF 367

V:\1953\active\19530002\transportation\drawing\confr\act\plot_files\zd307\clt\xt_sgn.plt