

TEMPORARY 100 WHITE LINE &
DURABLE 100 WHITE LINE, THERMOPLASTIC
STA. VT 1+560.0 TO VT 1+700.0, SOLID LT. & RT.
(WITH EDGELINE BREAKS FOR HARVARD ST.
& HICKORY HILL ROAD)
STA. VT 1+569.5 TO VT 1+646.8, SOLID RT.
(LANE LINE)
VT 1+573.1 - VT 1+648.8, SOLID RT.
VT 1+655.5 - VT 1+700.0, SOLID RT.

TEMPORARY 600 STOP BAR &
DURABLE 600 STOP BAR, THERMOPLASTIC
STA. VT 1+563.5, RT. (HARVARD ST.)
STA. VT 1+651.5, RT. (HICKORY HILL ROAD)

TEMPORARY 100 YELLOW LINE &
DURABLE 100 YELLOW LINE, THERMOPLASTIC
STA. VT 1+570.0 TO VT 1+600.0, DOUBLE SOLID, LT. & RT.
STA. VT 1+600.0 TO VT 1+644.5, DOUBLE SOLID, C
STA. VT 1+656.5 TO VT 1+700.0, DOUBLE SOLID, C
STA. VT 1+563.5, RT. (HARVARD STREET)
STA. VT 1+651.5, RT. (HICKORY HILL ROAD)


DURABLE CROSSWALK MARKING, THERMOPLASTIC
STA. VT 1+563.5, RT. (HARVARD ST.)
SEE SP-12 FOR DETAIL

TEMPORARY 200 YELLOW LINE &
DURABLE 200 YELLOW LINE, THERMOPLASTIC
STA. VT 1+570.0 TO VT 1+590.0, DIAGONALS


TEMPORARY LETTER OR SYMBOL
STA. VT 1+565.8, RT. - " STOP " (HARVARD ST.)
STA. VT 1+578.4, RT. - " ONLY " "
STA. VT 1+590.4, RT. - " ONLY " "
STA. VT 1+602.0, RT. - " ONLY " "
STA. VT 1+614.0, RT. - " ONLY " "
STA. VT 1+625.5, RT. - " ONLY " "
STA. VT 1+637.5, RT. - " ONLY " "
STA. VT 1+653.4, RT. - " STOP " (HICKORY HILL ROAD)

DURABLE LETTER OR SYMBOL, THERMOPLASTIC
STA. VT 1+565.8, RT. - " STOP " (HARVARD STREET)
STA. VT 1+578.4, RT. - " ONLY " "
STA. VT 1+590.4, RT. - " ONLY " "
STA. VT 1+602.0, RT. - " ONLY " "
STA. VT 1+614.0, RT. - " ONLY " "
STA. VT 1+625.5, RT. - " ONLY " "
STA. VT 1+637.5, RT. - " ONLY " "
STA. VT 1+653.4, RT. - " STOP " (HICKORY HILL ROAD)

REMOVING SIGNS
AS SHOWN-9
ERECTING SALVAGED SIGNS
AS SHOWN-3

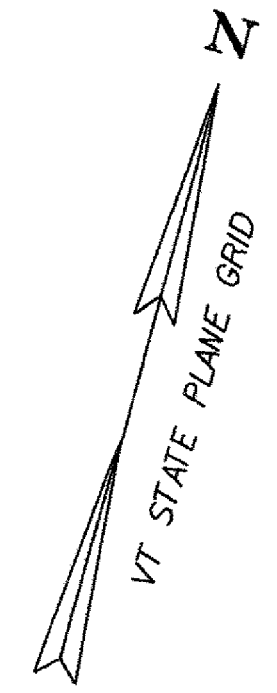

TEMPORARY 100 YELLOW LINE &
DURABLE 100 YELLOW LINE, THERMOPLASTIC
TEMPORARY 200 YELLOW LINE &
DURABLE 200 YELLOW LINE, THERMOPLASTIC
(SEE SHEET PMD-1 FOR DETAILS ON SPACING)

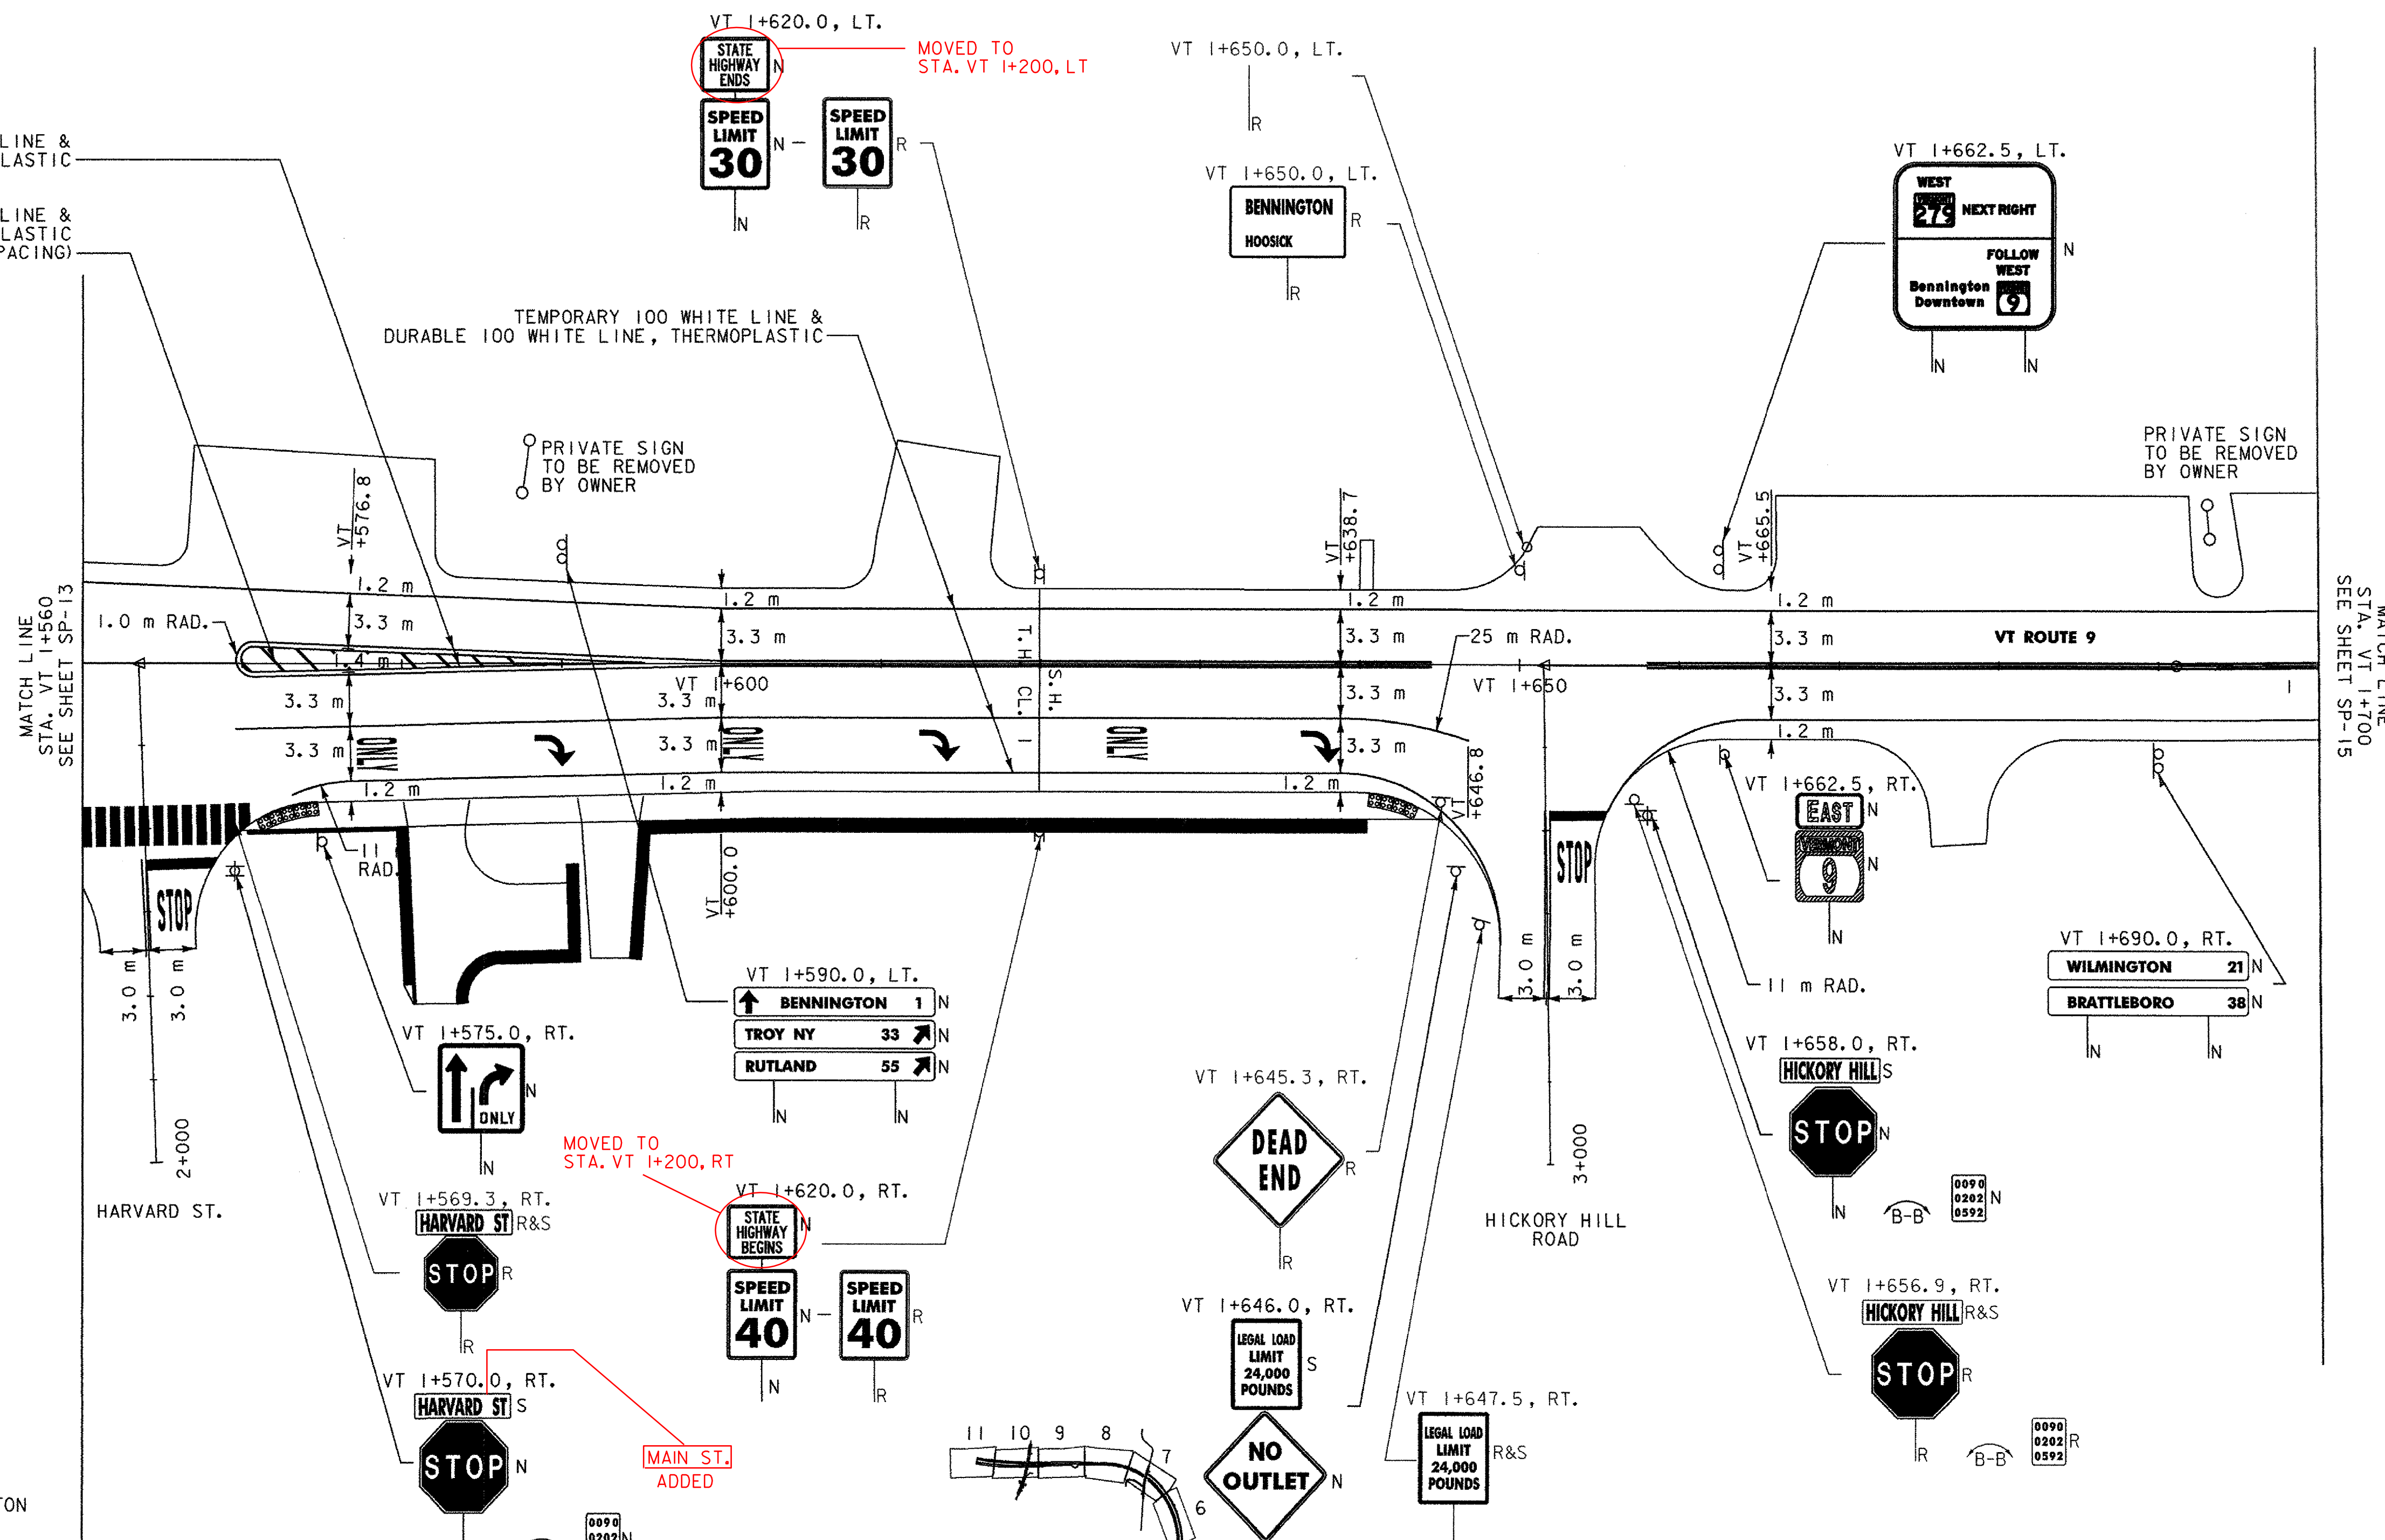

SIGN & DELINEATOR LEGEND

- N = NEW
- R = REMOVE
- R&S = REMOVE & SALVAGE
- S = SALVAGE SIGN
- RET = RETAIN
- B-B = BACK TO BACK
- ⊙ = RETURN TO TOWN OF BENNINGTON
- = TYPE I (WHITE)
- = TYPE I (AMBER)
- = TYPE I (WHITE W/REF PLAQUE)
- = TYPE II
- = TYPE III (WHITE)
- = TYPE III (AMBER)
- * = MATCH EXISTING CONDITIONS

NOTE: 1) FOR ANY TOWN HIGHWAY OR STREET
DETAILS, SEE VTRANS STANDARD E-193
2) FOR FURTHER DETAILS ON LIGHTING,
SEE LIGHTING PLAN SHEET LP-07

NOTE: ALL DIMENSIONS, NOTES, AND CALLOUTS IN MILLIMETERS (mm) EXCEPT AS NOTED

VERMONT AGENCY OF TRANSPORTATION



PROJECT NAME: BENNINGTON
PROJECT NUMBER: AC NH 019-1(51)

FILE NAME: ...plot files\zd307c\txf.sgna.ppf PLOT DATE: 1/30/2009
DESIGN SUPERVISOR: GREG EDWARDS DRAWN BY: STANTEC
DESIGNED BY: MARC FOISY CHECKED BY: GARY SANTY
SIGNS AND MARKINGS SP-14 SHEET 123 OF 367

V:\1953\active\19530002\transportation\dr\ow\qa\contract\plot_files\zd307c\txf.sgna.ppf