
 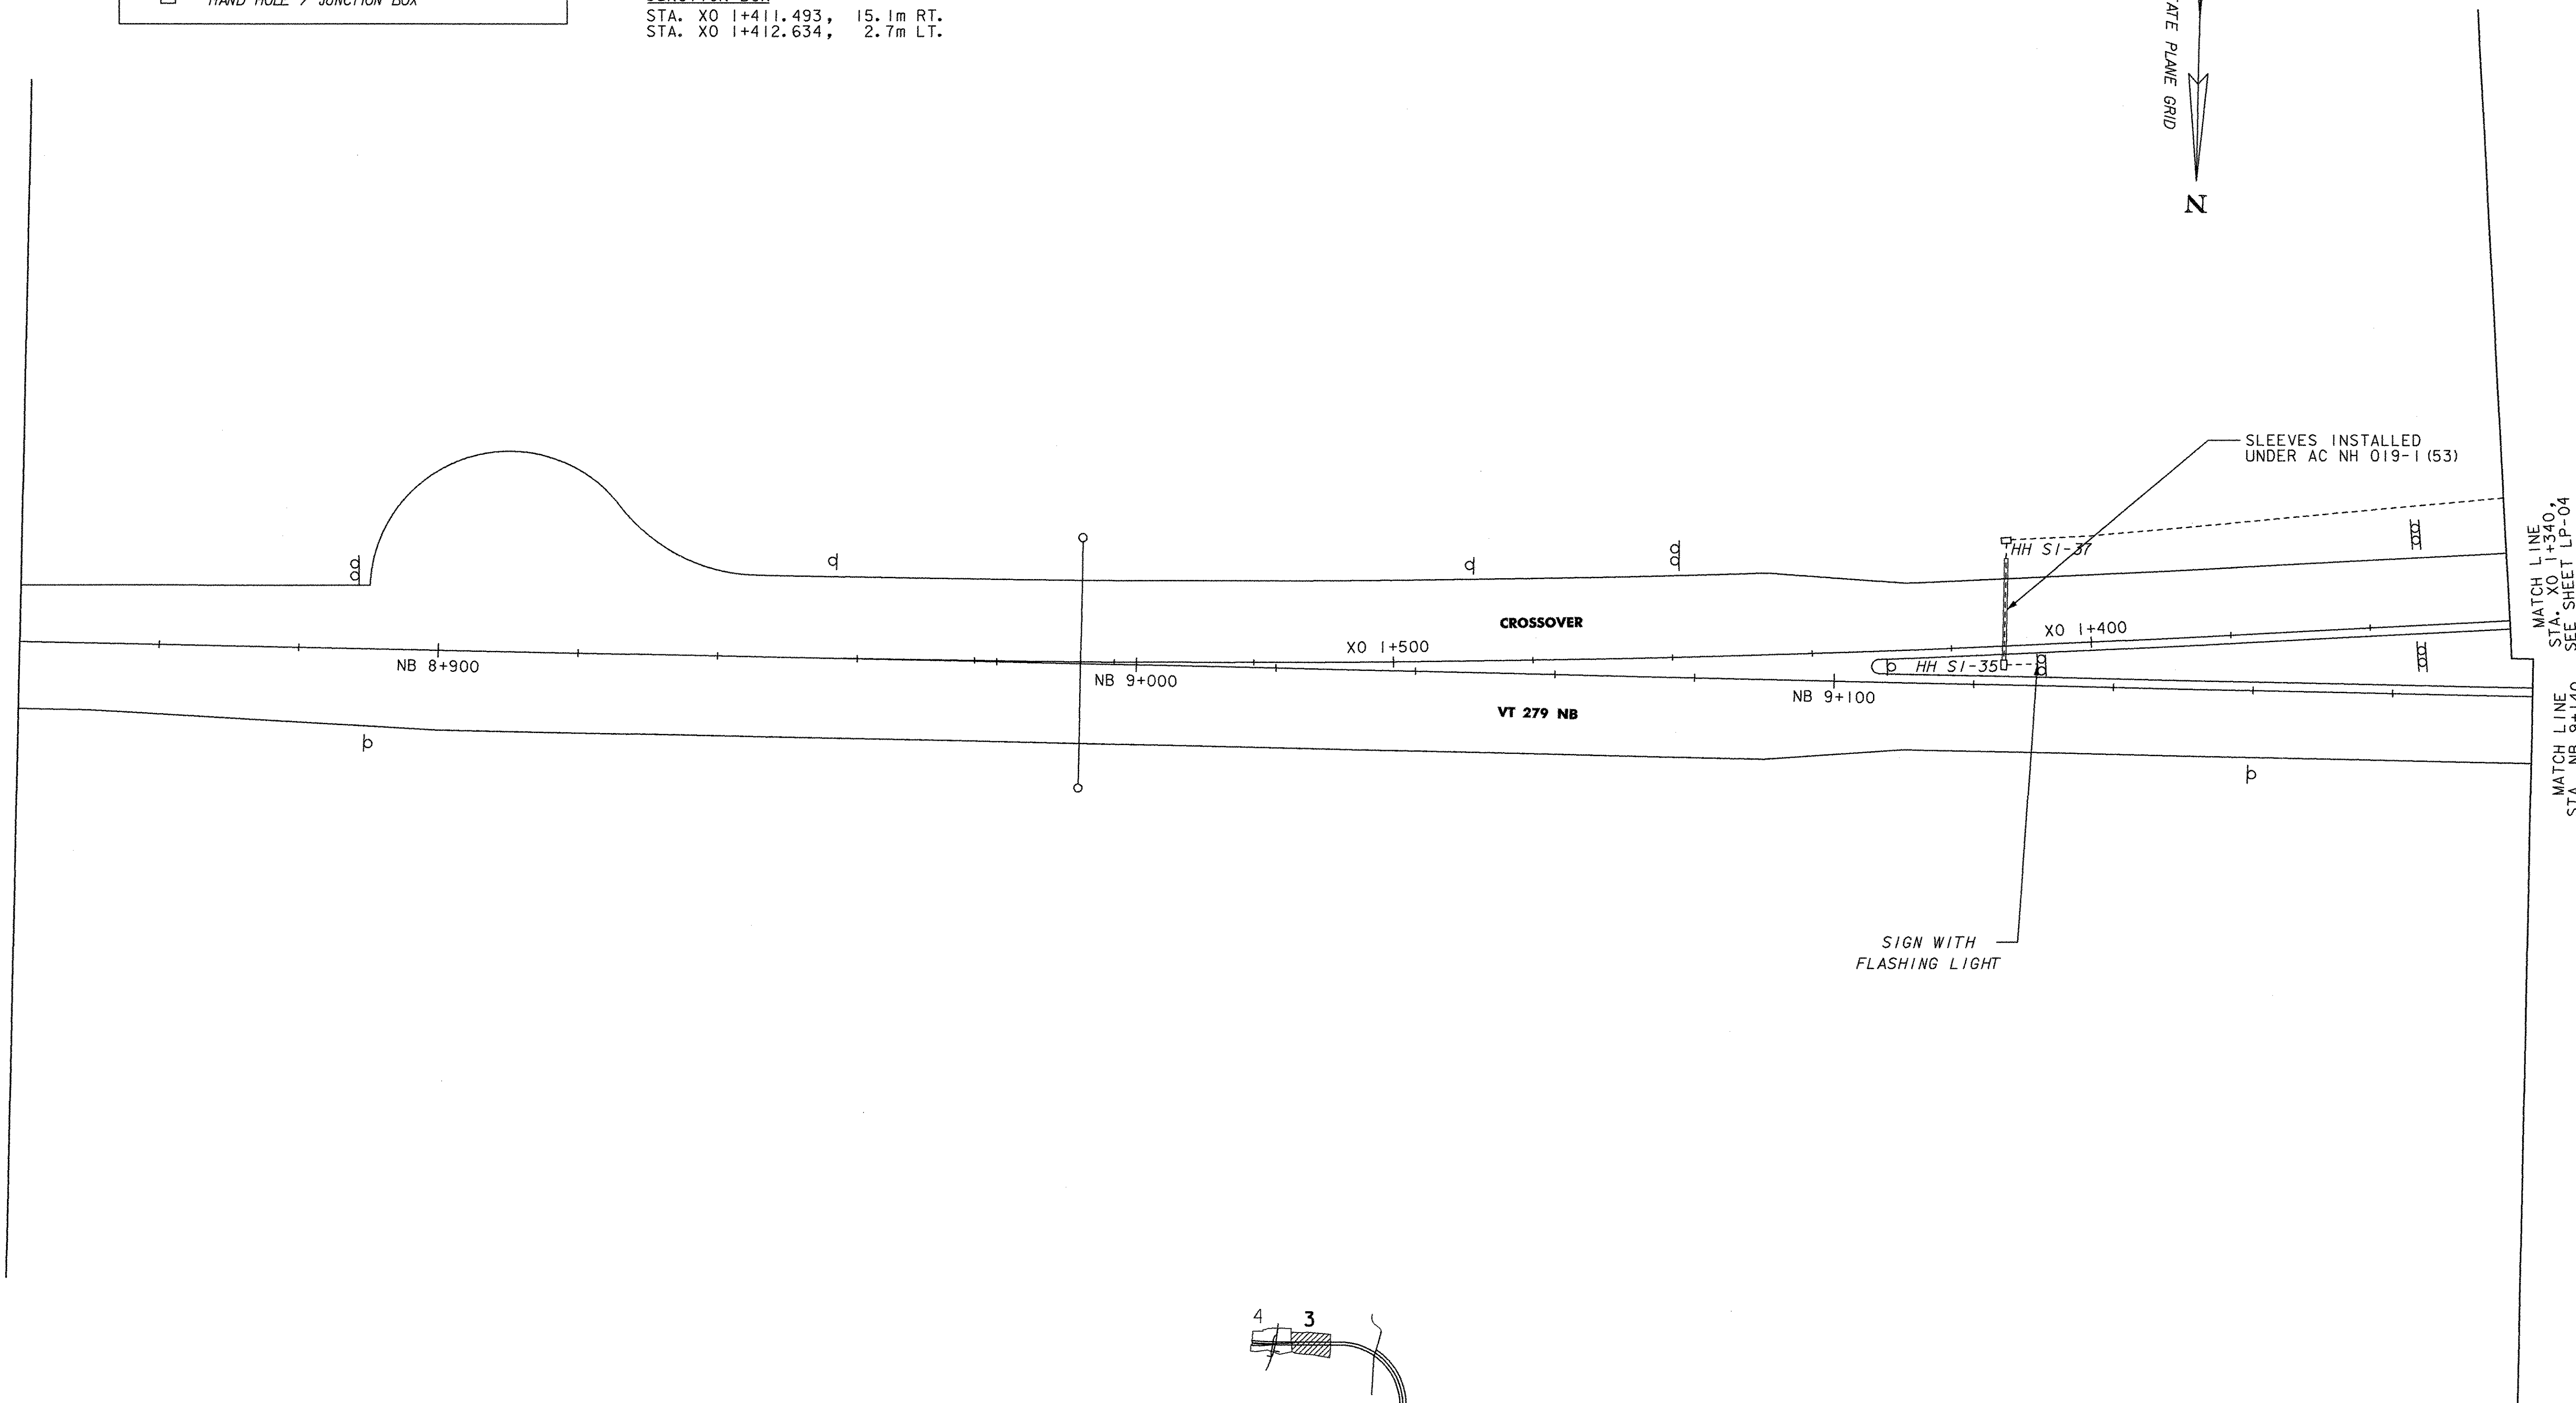


**STREET LIGHTING LEGEND**

- TYPE 'A' STREET LIGHT
- UNDERGROUND ELECTRICAL CONDUIT
- HAND HOLE / JUNCTION BOX



**ELECTRICAL CONDUIT**  
 STA. XO 1+340.000, 17.5m RT. - STA. XO 1+411.493, 15.1m RT.  
 STA. XO 1+411.493, 15.1m RT. - STA. XO 1+412.634, 2.7m LT.  
 STA. XO 1+412.634, 2.7m LT. - STA. XO 1+407.837, 2.8m LT.

**JUNCTION BOX**  
 STA. XO 1+411.493, 15.1m RT.  
 STA. XO 1+412.634, 2.7m LT.




**HAND HOLE LOCATIONS - LP-03**

HAND HOLE NO.	LOCATION	TYPE	REMARKS
HH S1-35	SCALED PER SIGNAGE PLANS	JUNCTION BOX	
HH S1-37	SCALED PER SIGNAGE PLANS	JUNCTION BOX	

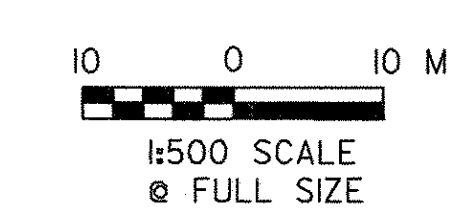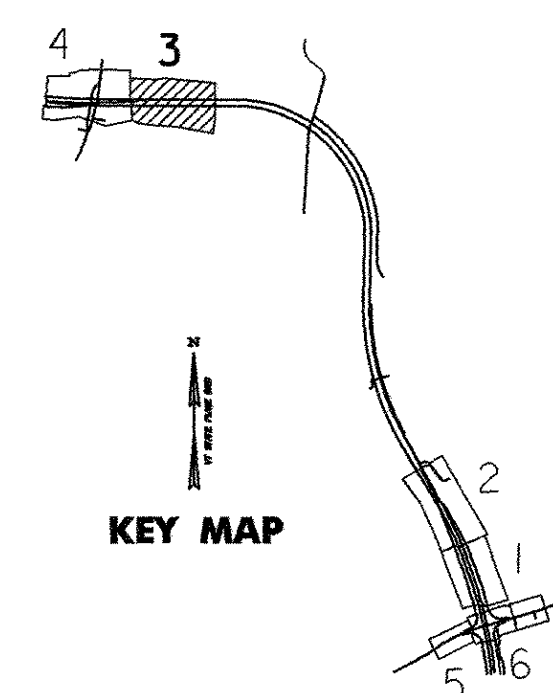

**VERMONT AGENCY OF TRANSPORTATION**



PROJECT NAME: BENNINGTON  
 PROJECT NUMBER: AC NH 019-1(51)

FILE NAME: ...zd307cilt-plans\_500.pxf PLOT DATE: 2/2/2009  
 DESIGN SUPERVISOR: GREG EDWARDS DRAWN BY: STANTEC  
 DESIGNED BY: MARC FOISY CHECKED BY: GARY SANTY  
**LIGHTING PLAN LP-03** SHEET 149 OF 367

vt:\953\active\9530002\transportation\drawing\contract\ldplot\_files\zd307cilt\_plans\_500.pxf