

STREET LIGHTING LEGEND

- TYPE 'A' STREET LIGHT
- UNDERGROUND ELECTRICAL CONDUIT
- HAND HOLE / JUNCTION BOX

ELECTRICAL CONDUIT


STA. XO 1+252.902, 39.7m RT. - STA. XO 1+262.718, 28.3m RT.
 STA. XO 1+262.718, 28.3m RT. - STA. XO 1+320.417, 18.3m RT.
 STA. XO 1+320.417, 18.3m LT. - STA. XO 1+340.000, 17.5m RT.

JUNCTION BOX

STA. XO 1+320.417, 18.3m LT.



SPECIAL PROVISION (POWER DROP STANCHION)

STA. XO 1+262.718, 28.3m RT.

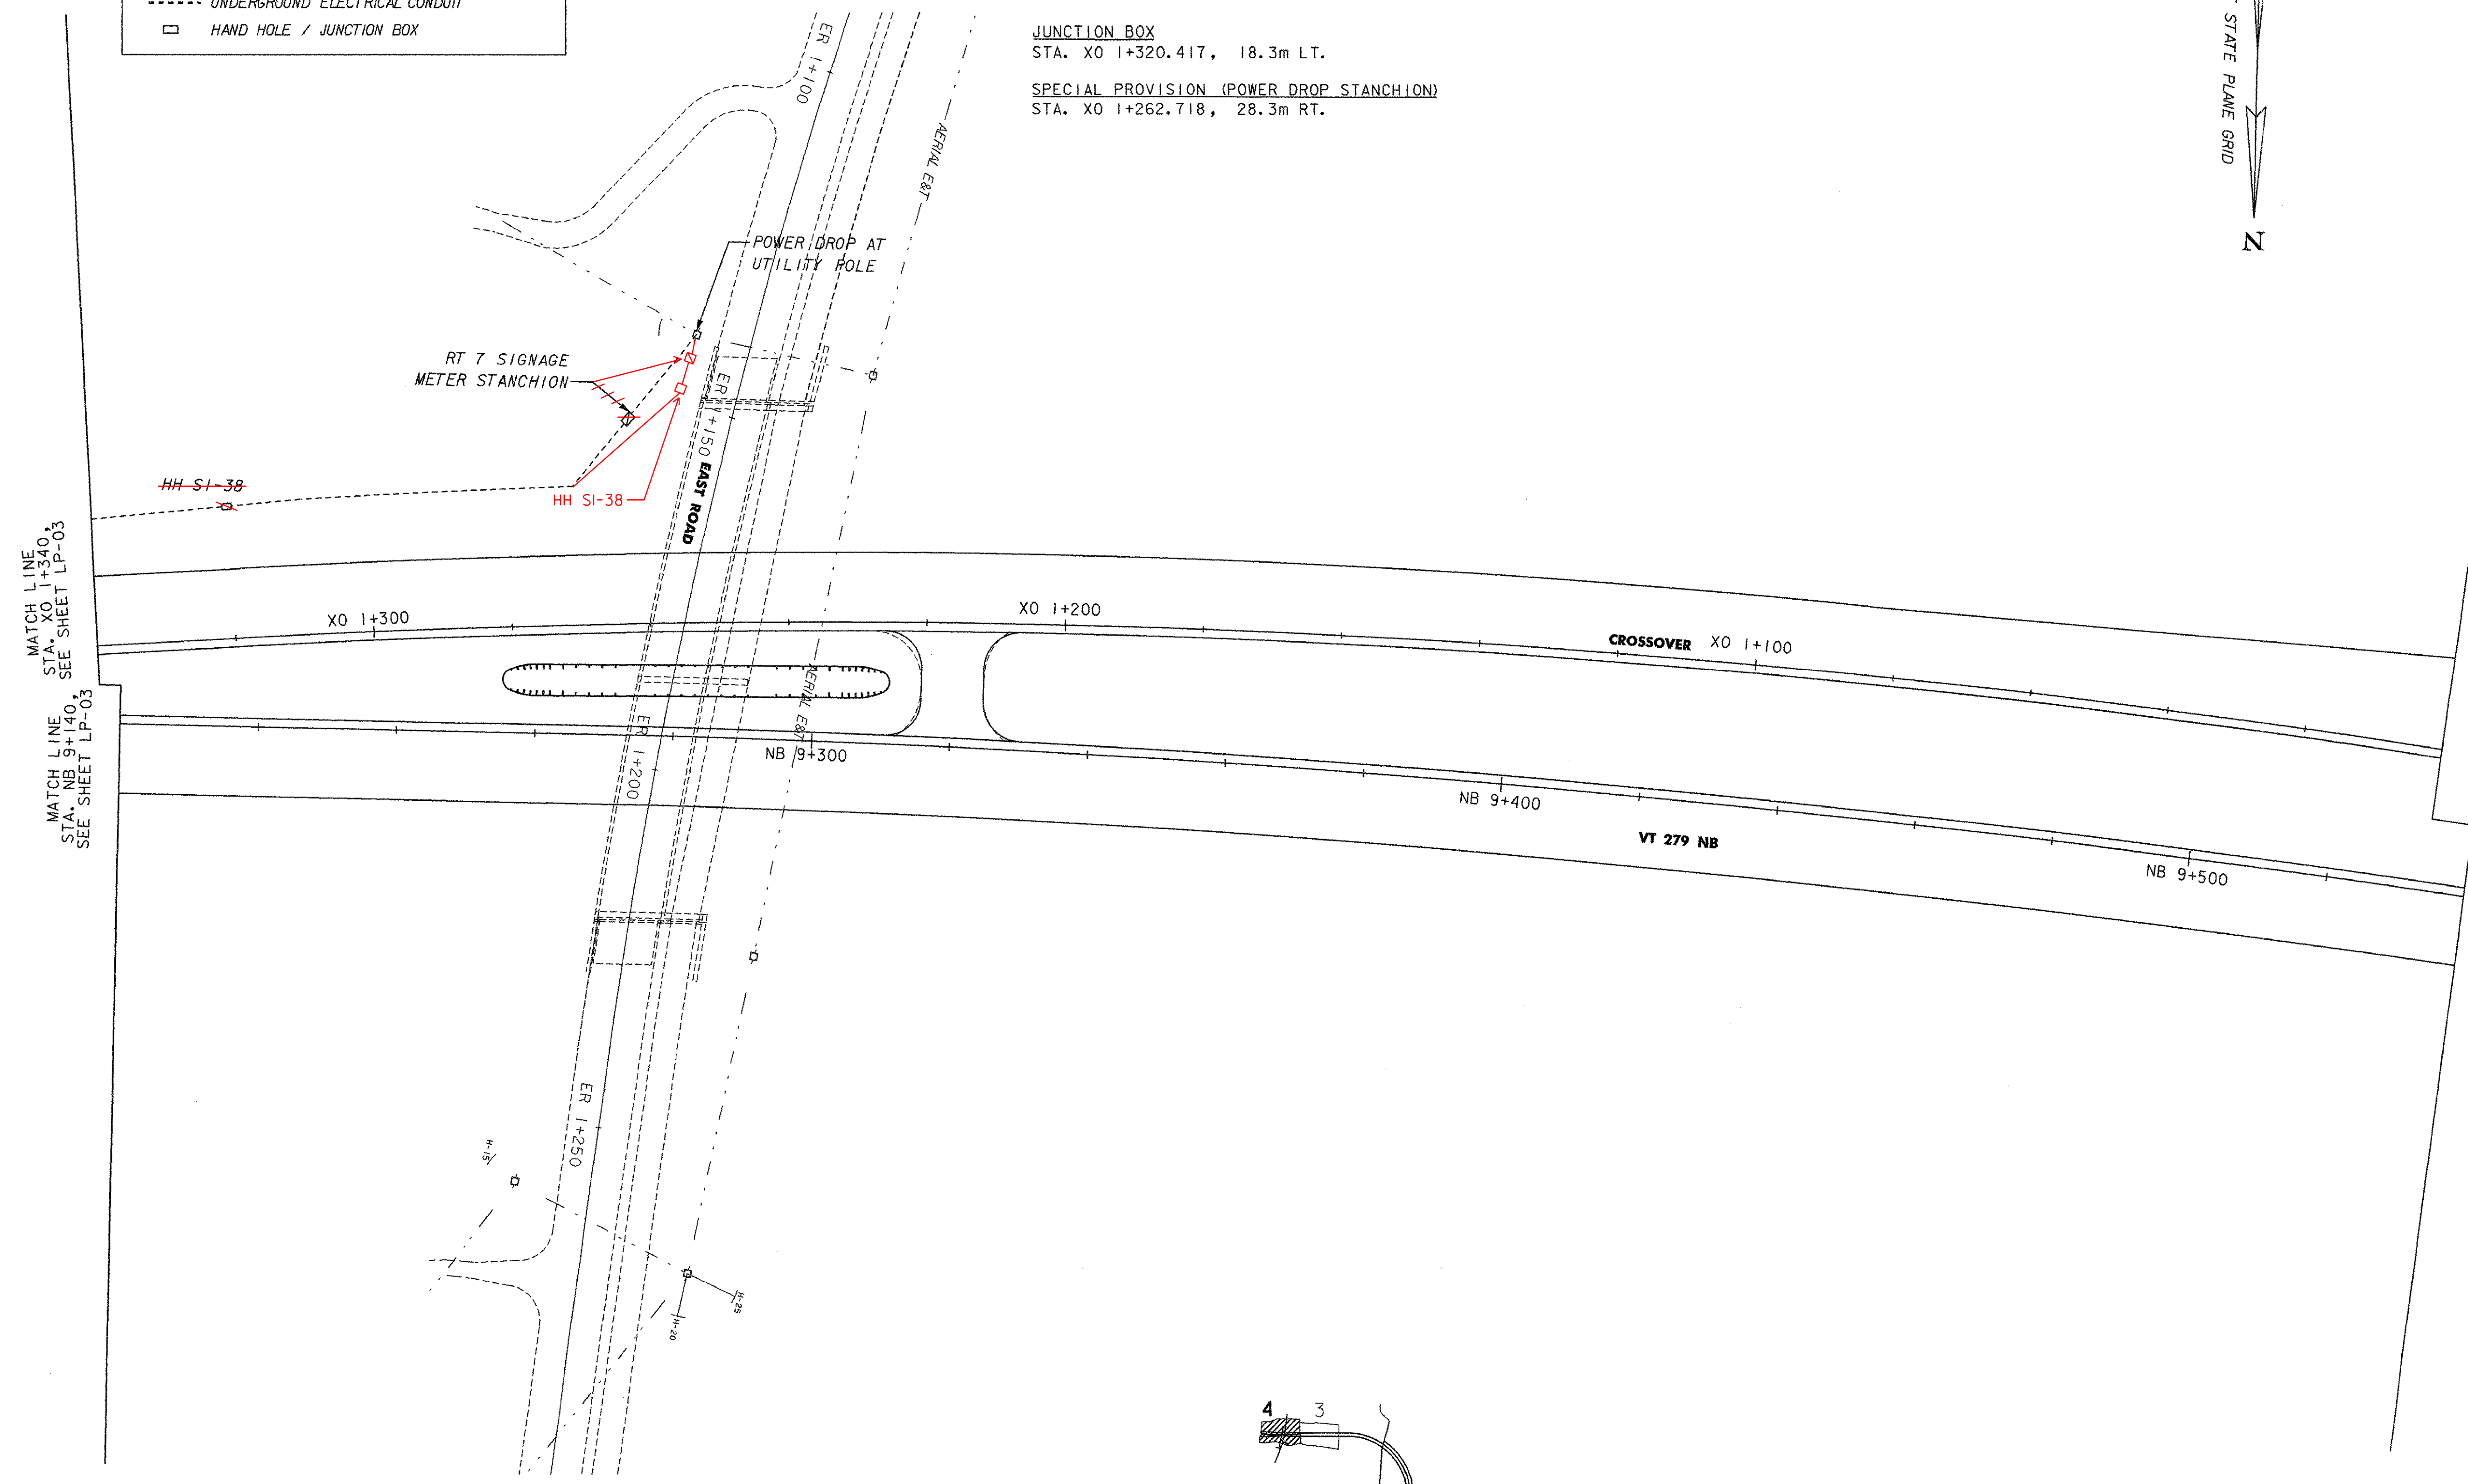


HAND HOLE LOCATIONS - LP-04

HAND HOLE NO.	LOCATION	TYPE	REMARKS
HH SI-38	SCALED PER SIGNAGE PLANS	JUNCTION BOX	

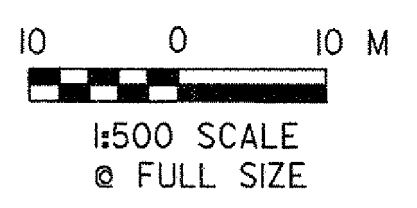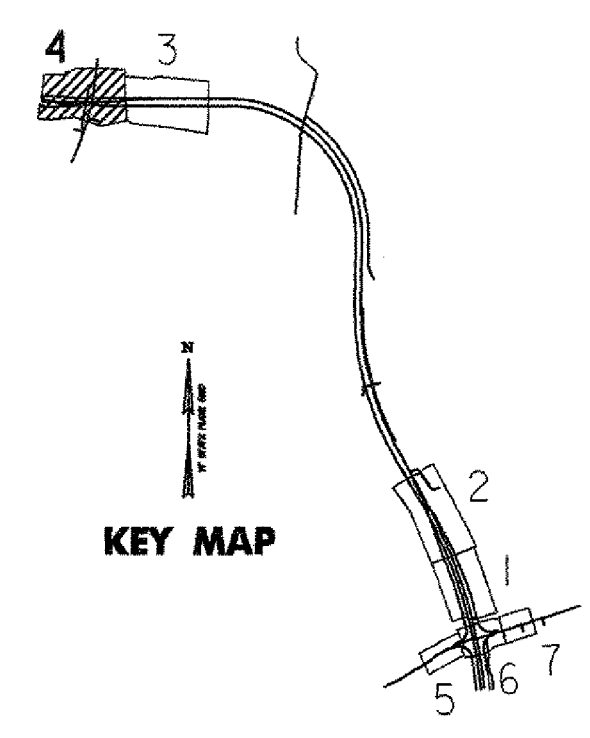

VERMONT AGENCY OF TRANSPORTATION



PROJECT NAME: BENNINGTON
 PROJECT NUMBER: AC NH 019-(151)

FILE NAME: ...zd307c1glt_plans.500.ptf
 DESIGN SUPERVISOR: GREG EDWARDS
 DESIGNED BY: MARC FOISY
LIGHTING PLAN LP-04

PLOT DATE: 2/2/2009
 DRAWN BY: STANTEC
 CHECKED BY: GARY SANTY
 SHEET 150 OF 367

v:\953\acrive\9530002\Transportation\Drawing\Contract\Nplbt\files\zd307c1glt_plans.500.ptf