

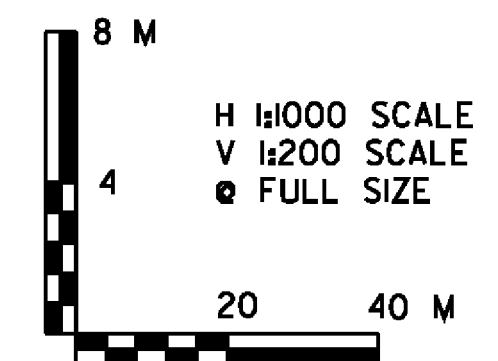
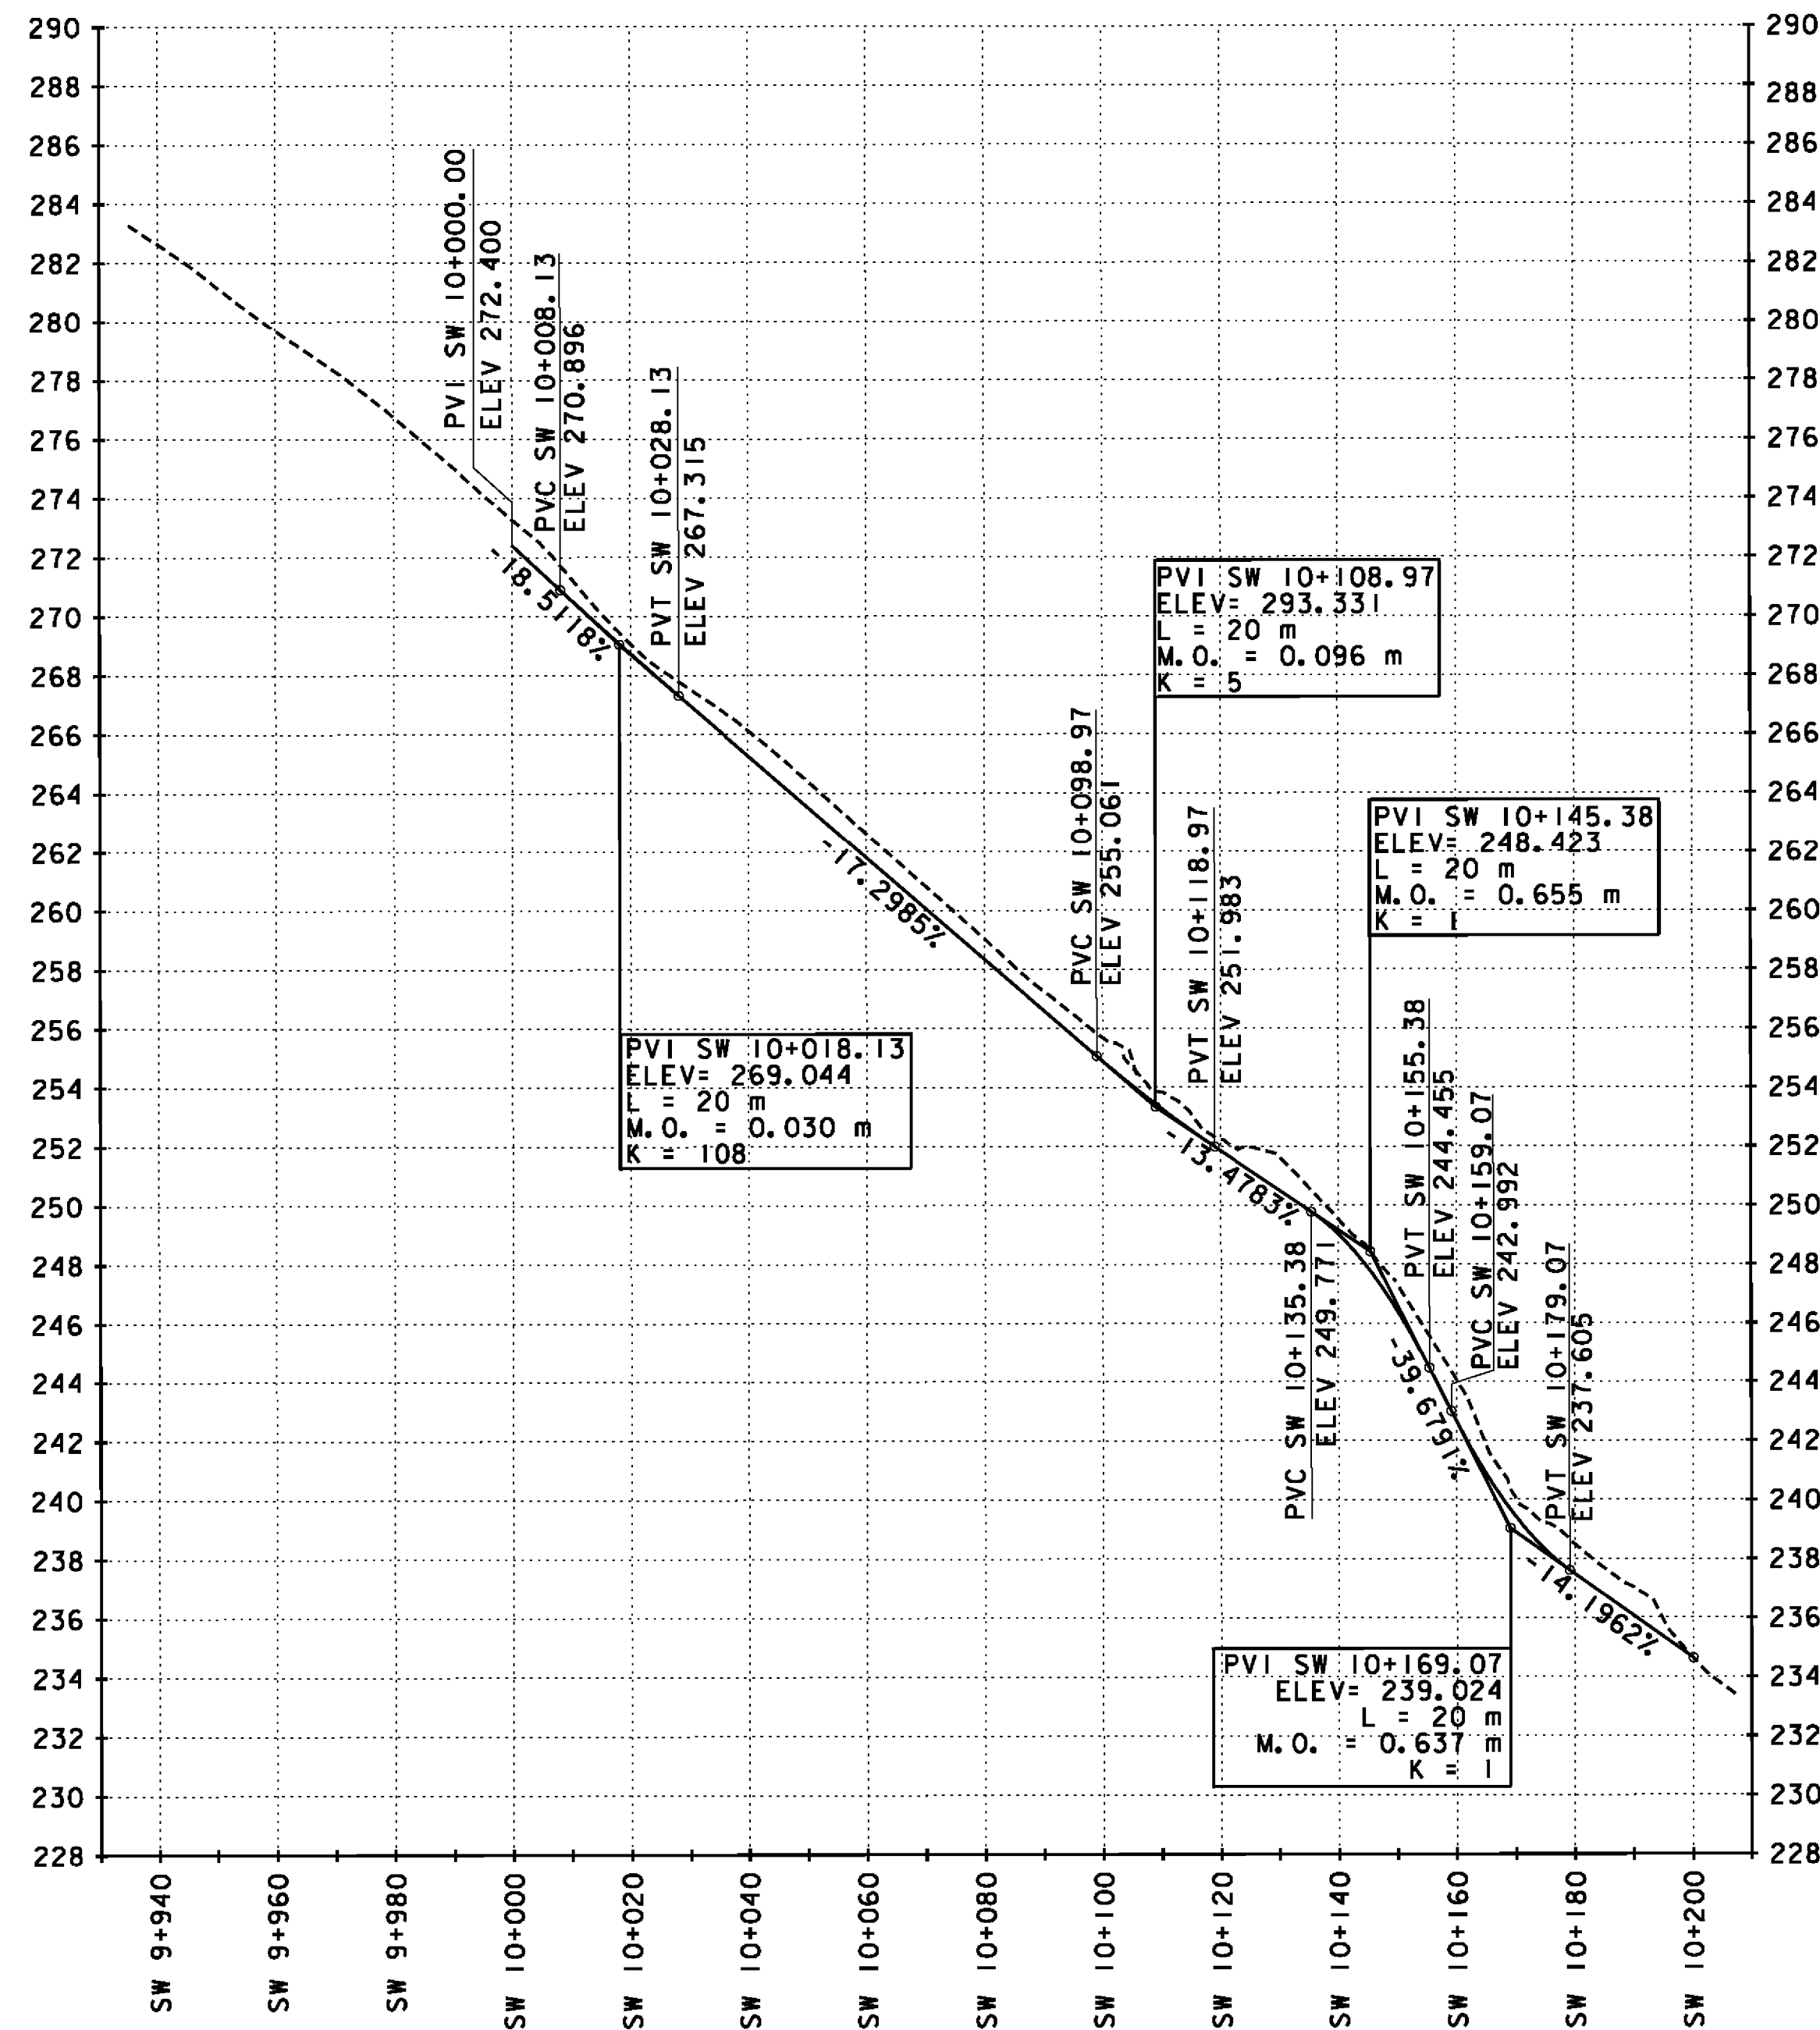


SWALE PROFILE

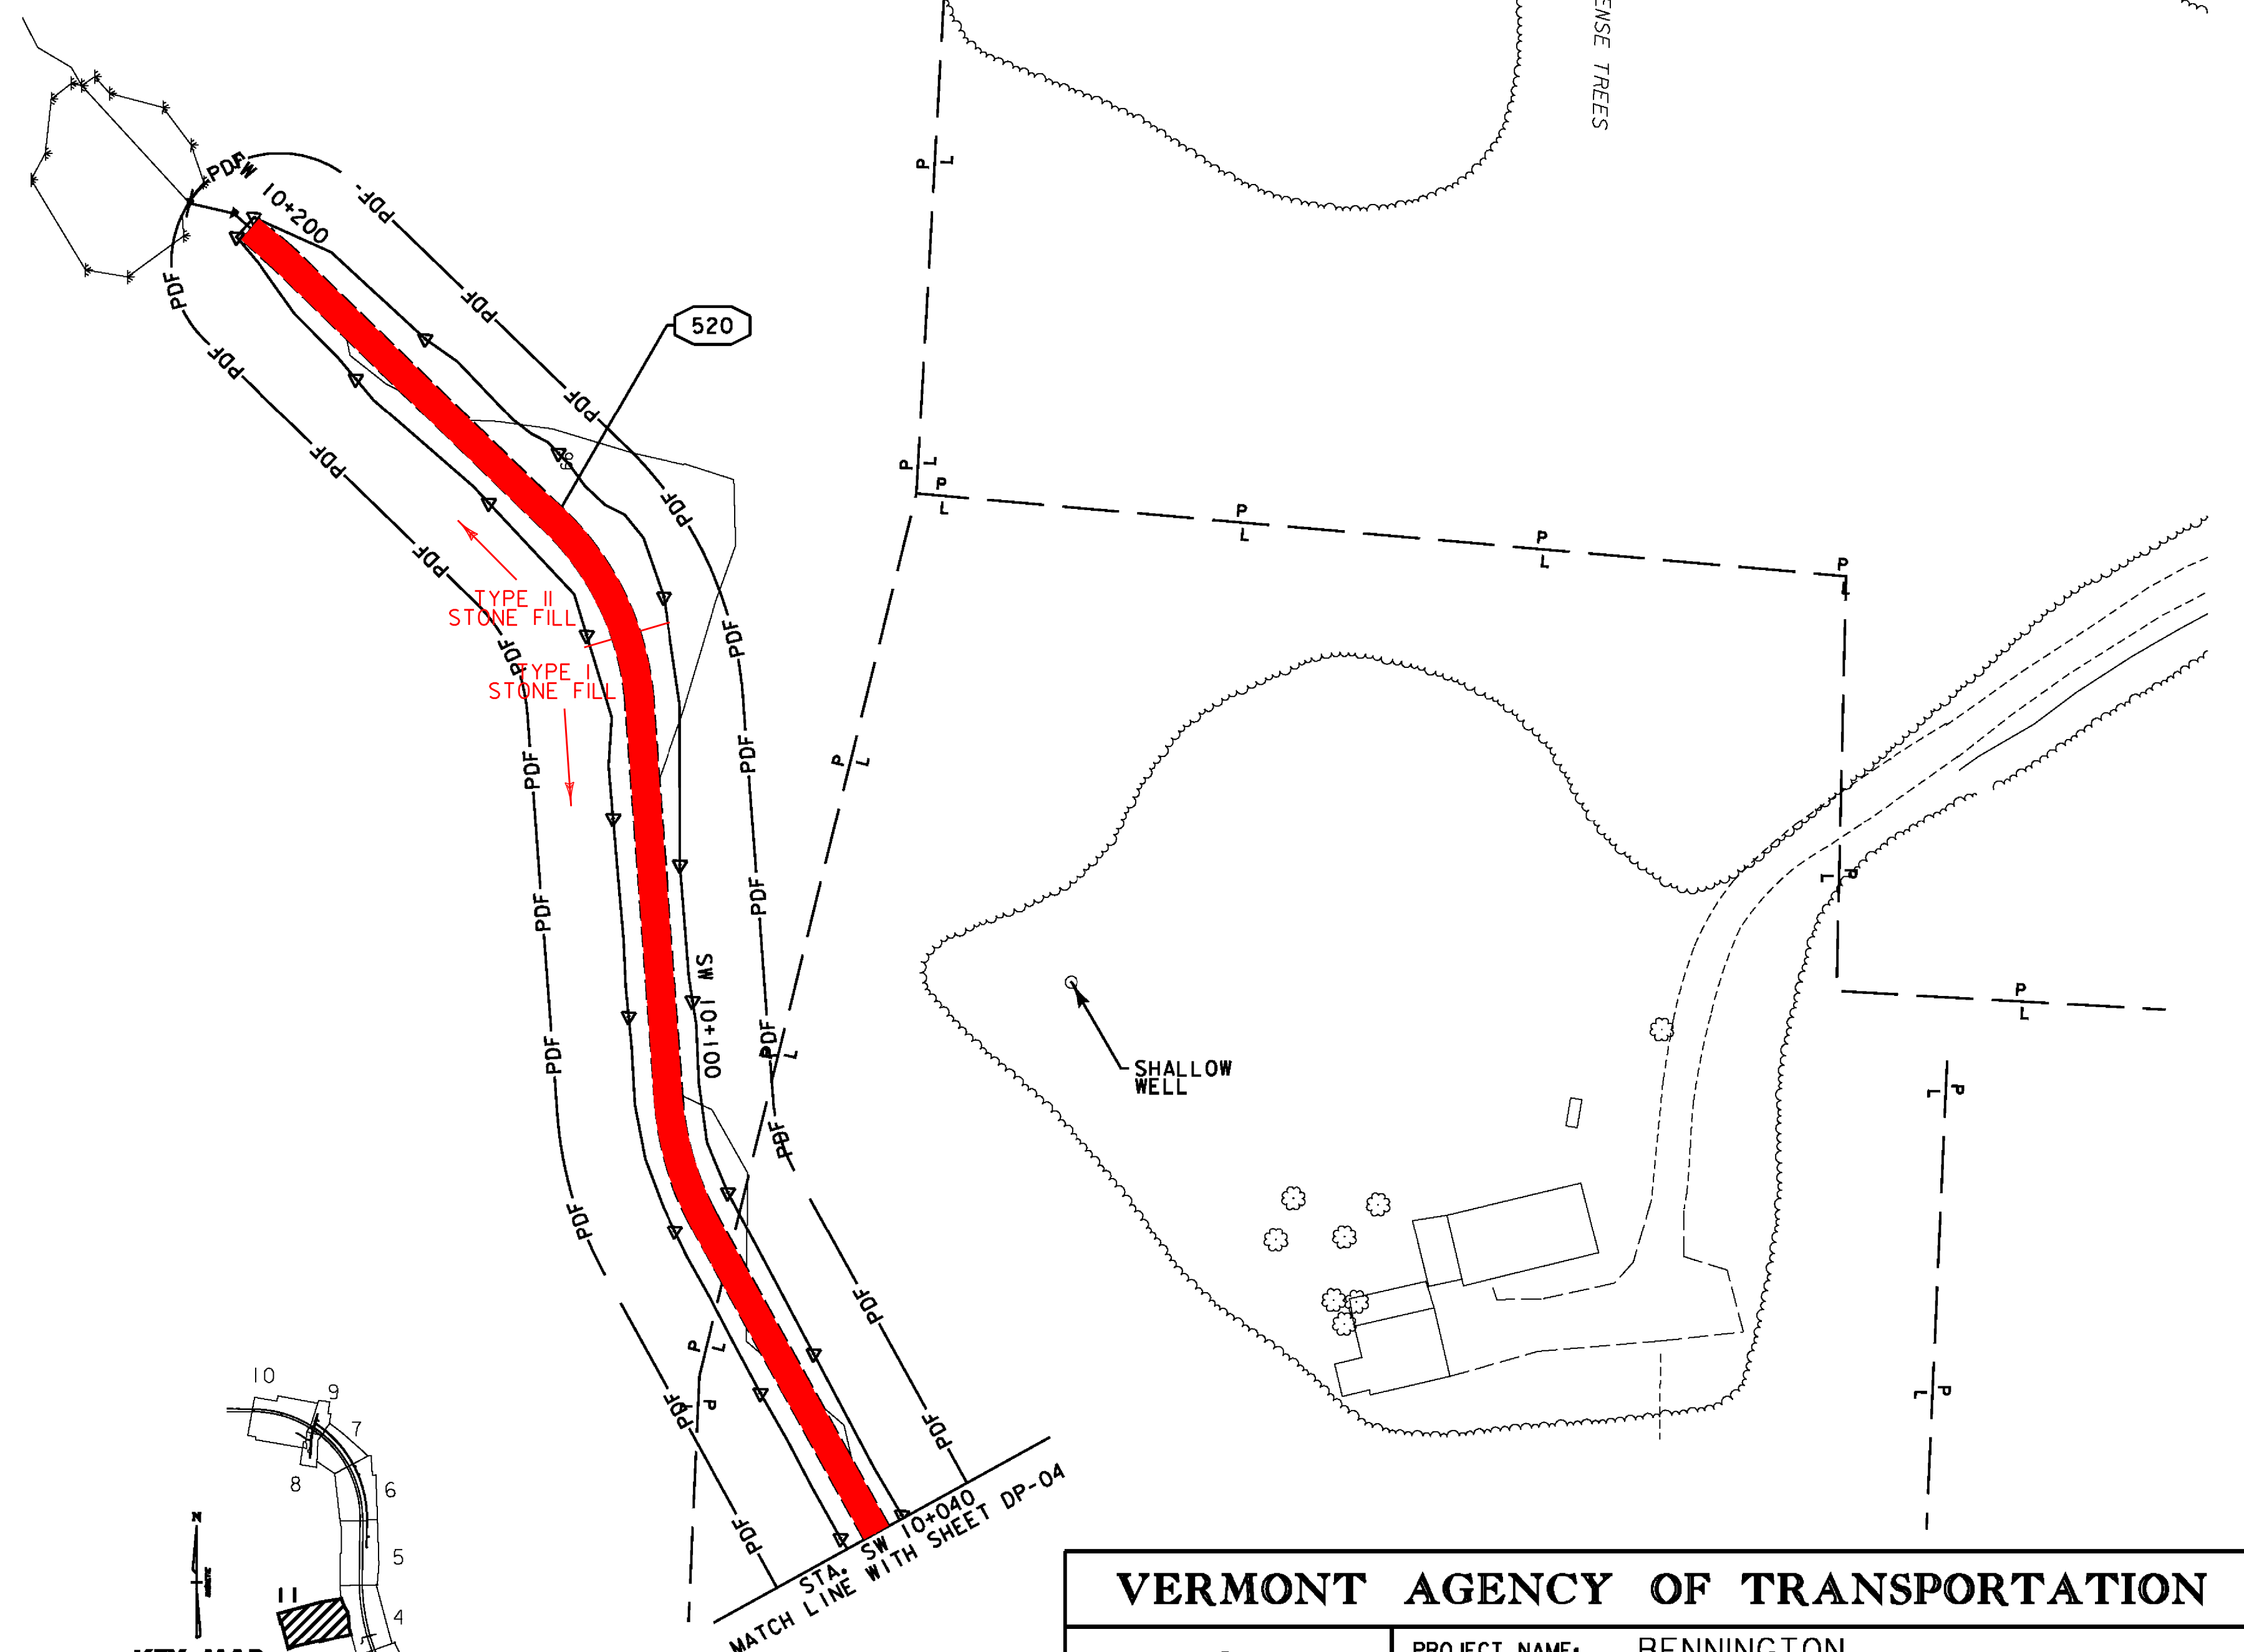

TYPICAL SWALE SECTION

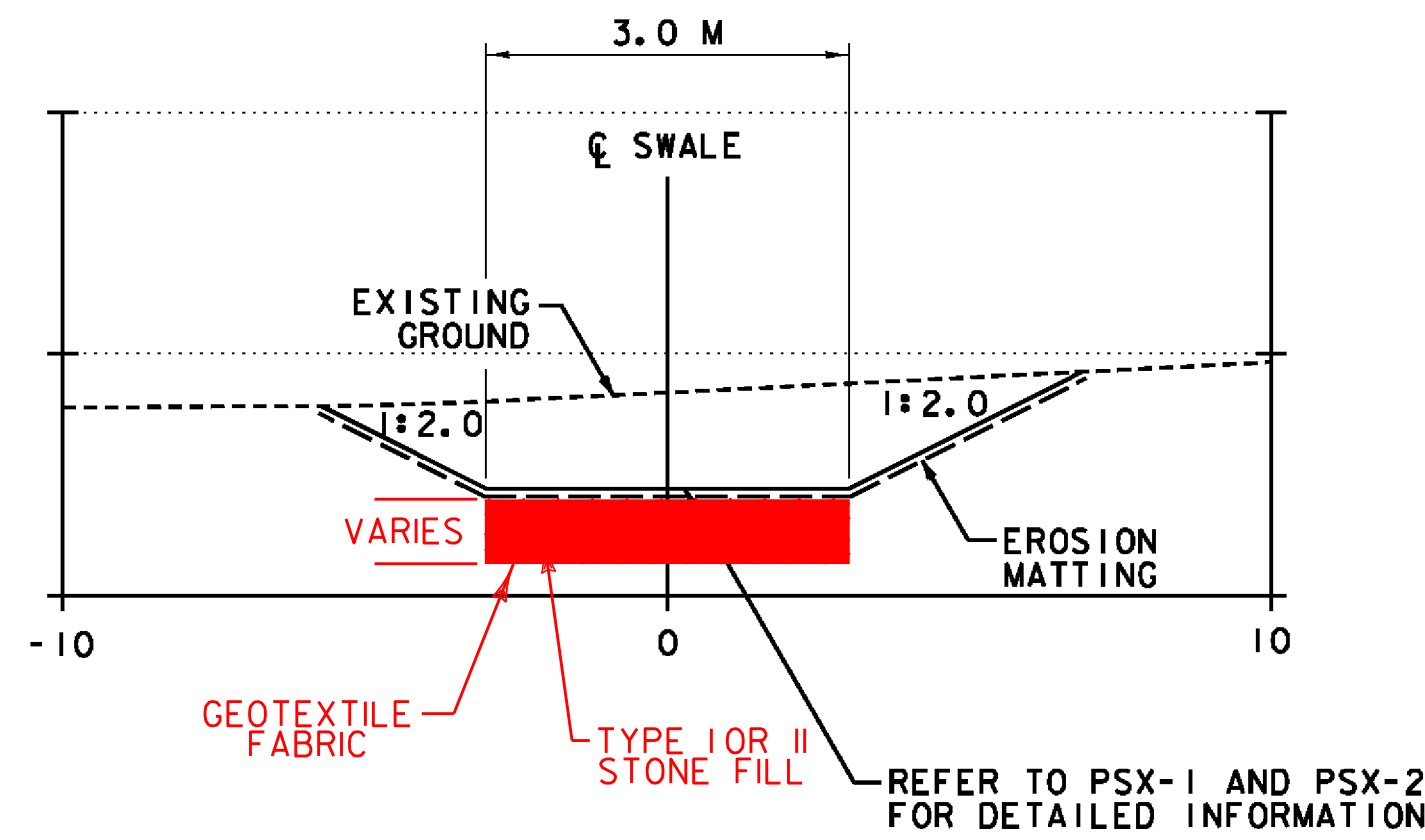

KEY MAP



VERMONT AGENCY OF TRANSPORTATION



PROJECT NAME:	BENNINGTON	PLOT DATE:	5/16/2011
PROJECT NUMBER:	AC NH 019-1(52)	DRAWN BY:	STANTEC
FILE NAME:	...plot_files\zd307c2dpl.ptf	CHECKED BY:	GARY SANTY
DESIGN SUPERVISOR:	GREG EDWARDS	SHEET	91 OF 267
DESIGNED BY:	MARC FOISY		
DRAINAGE PLAN	DP-11		