


LEGEND:
MAINLINE PREFIX:
 WB VT 279 WESTBOUND
 EB VT 279 EASTBOUND

RAMPS:
 SINGLE LETTER FOR RAMPS
 F, G, I, N, P, Q, R, S, T, U, L


SIDE ROAD PREFIX:
 NB US 7 NORTHBOUND
 SB US 7 SOUTHBOUND

→ DIRECTION OF TRAFFIC FLOW
 SB AND EB STATIONING RUNS OPPOSITE TRAFFIC DIRECTION

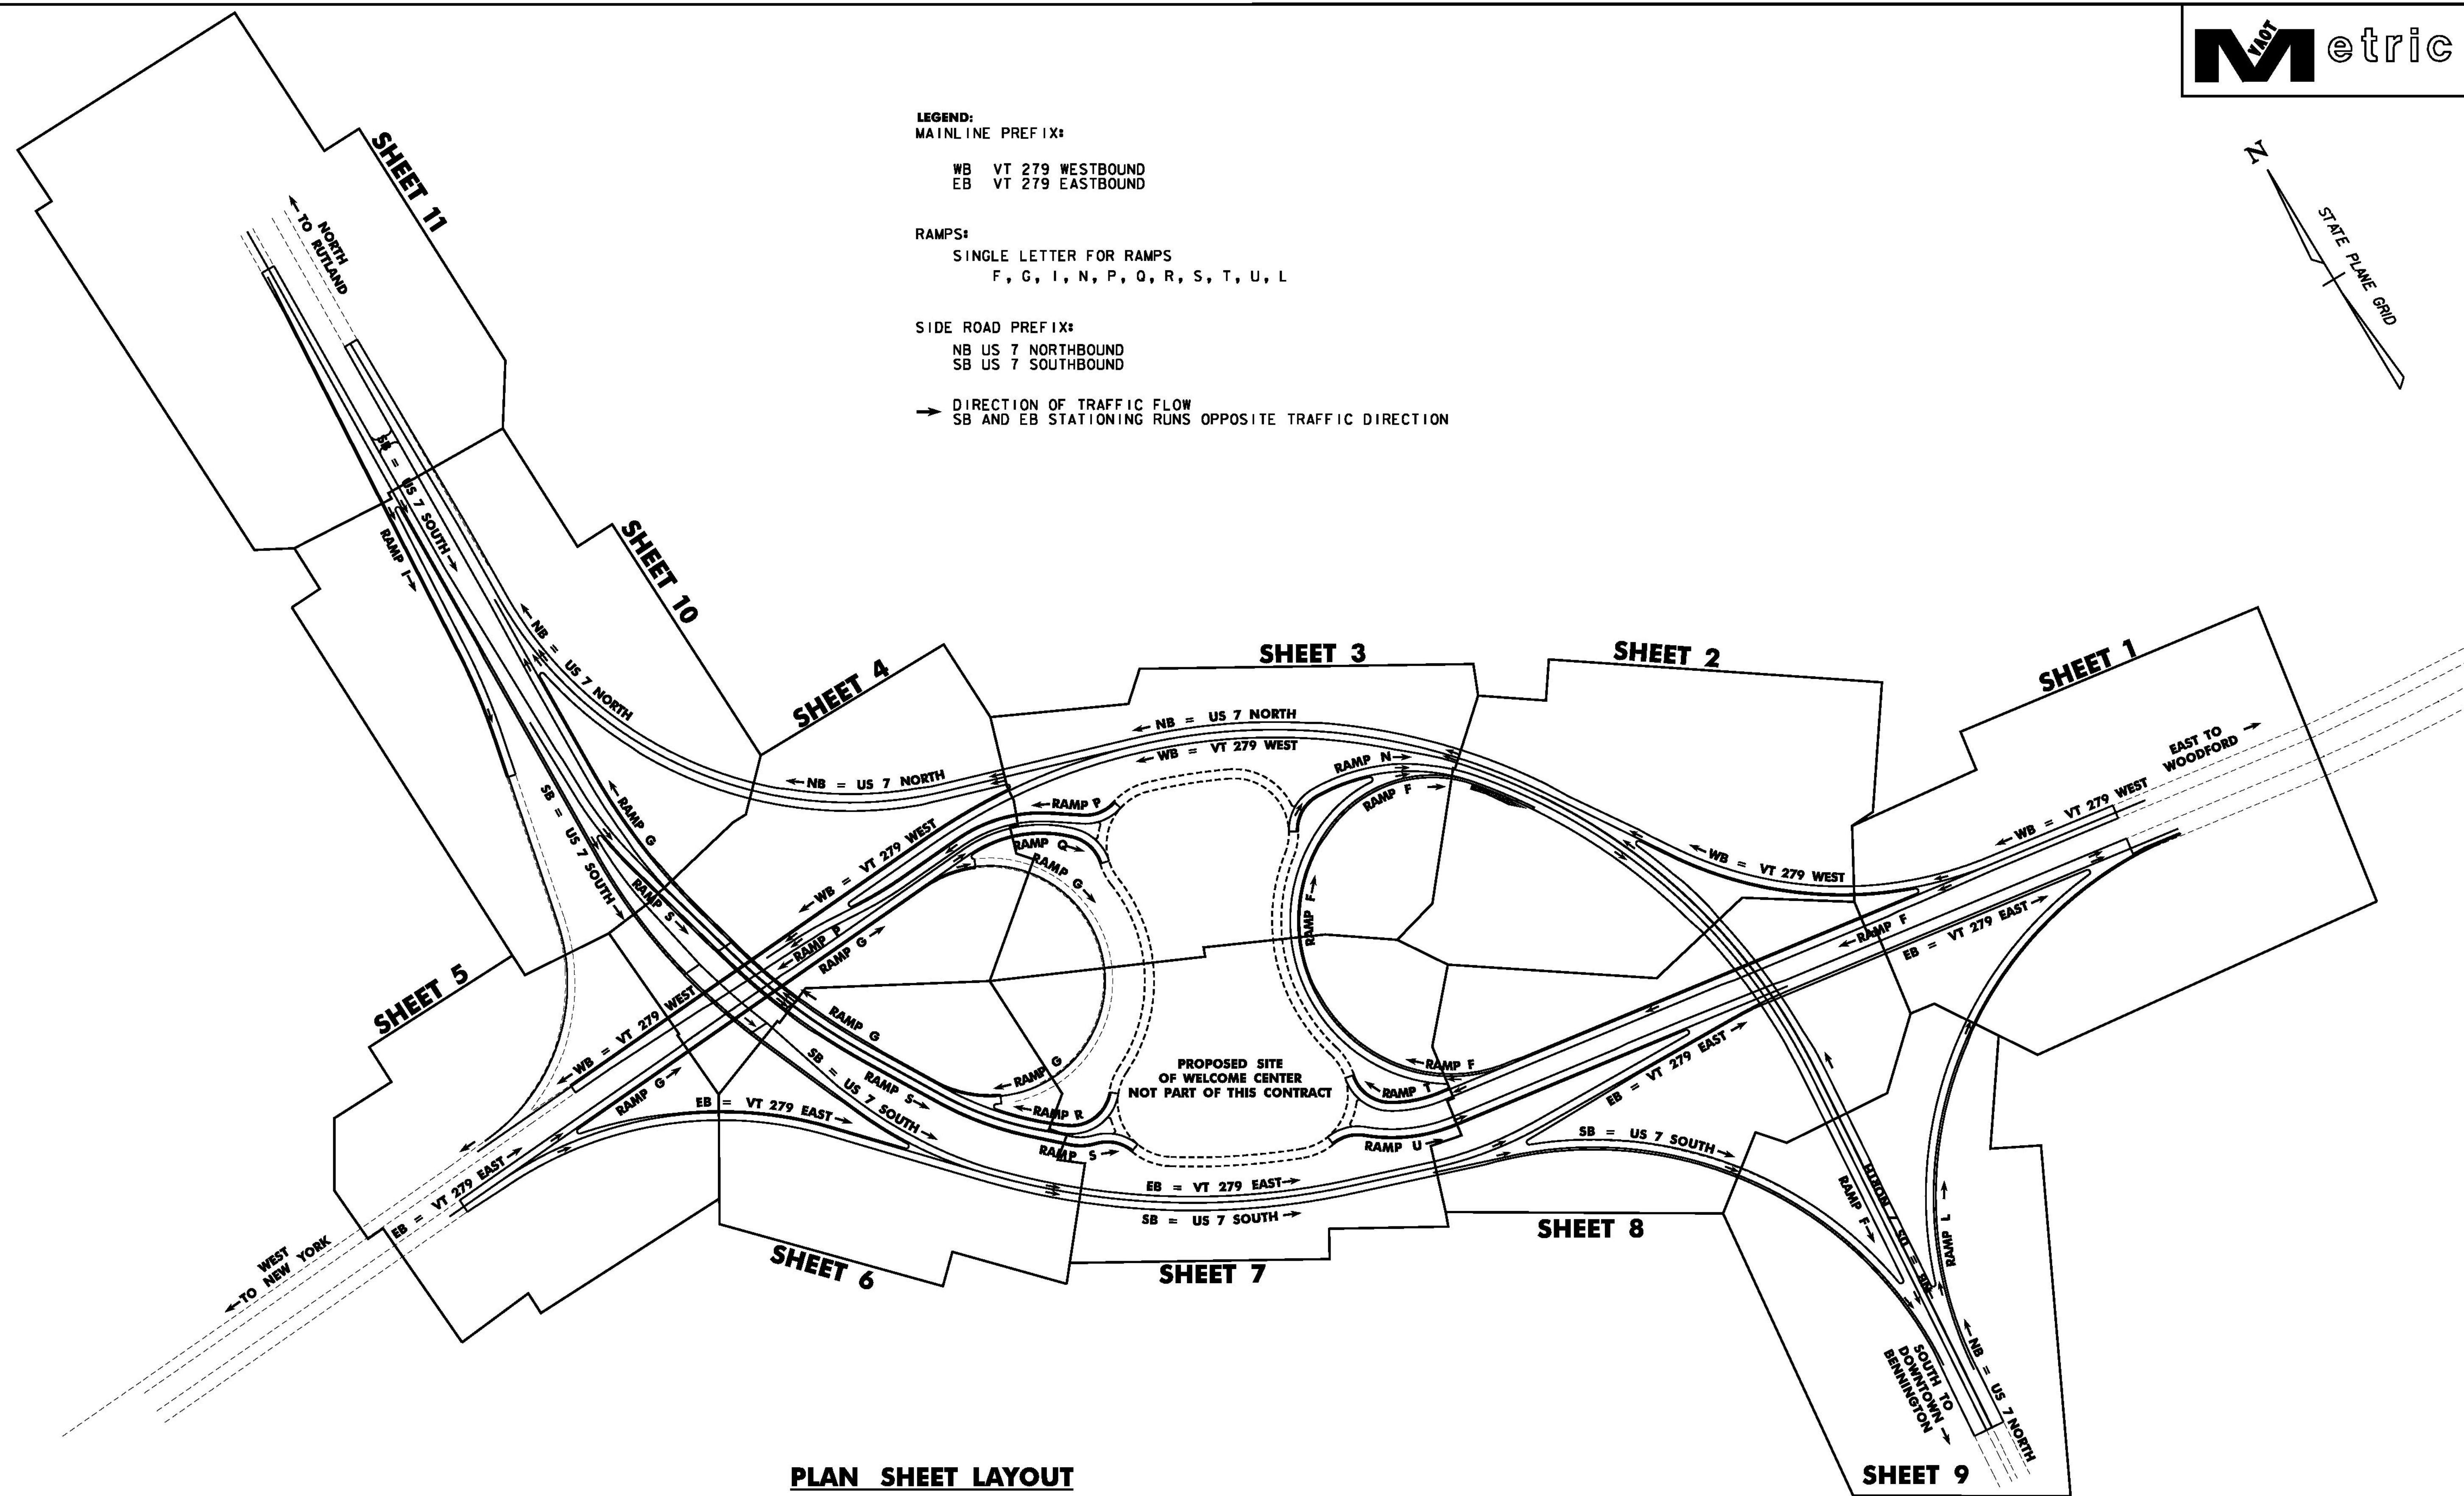

PLAN SHEET LAYOUT

SHEET LAYOUTS APPLY TO
 ALIGNMENT PLANS, GENERAL PLANS, DRAINAGE PLANS,
 EROSION CONTROL PLANS AND LIGHTING PLANS.

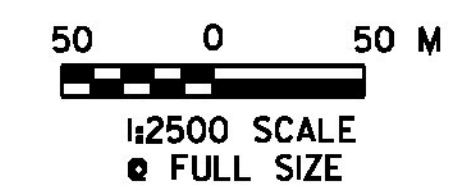

PROJECT NAME:	BENNINGTON	PLOT DATE:	1/26/2010
PROJECT NUMBER:	NH 019-1(54)	DRAWN BY:	STANTEC
FILE NAME:	...\\plot_files\zd307c4key.ptf	CHECKED BY:	GARY SANTY
DESIGN SUPERVISOR:	GREG EDWARDS	PLAN SHEET KEY:	PSK-01
DESIGNED BY:	MARC FOISY	SHEET	63 OF 468

1/26/2010 4:45:41 PM v:\953\active\95310022\transportation\drawing\contract_4\plot_files\zd307c4key.ptf