
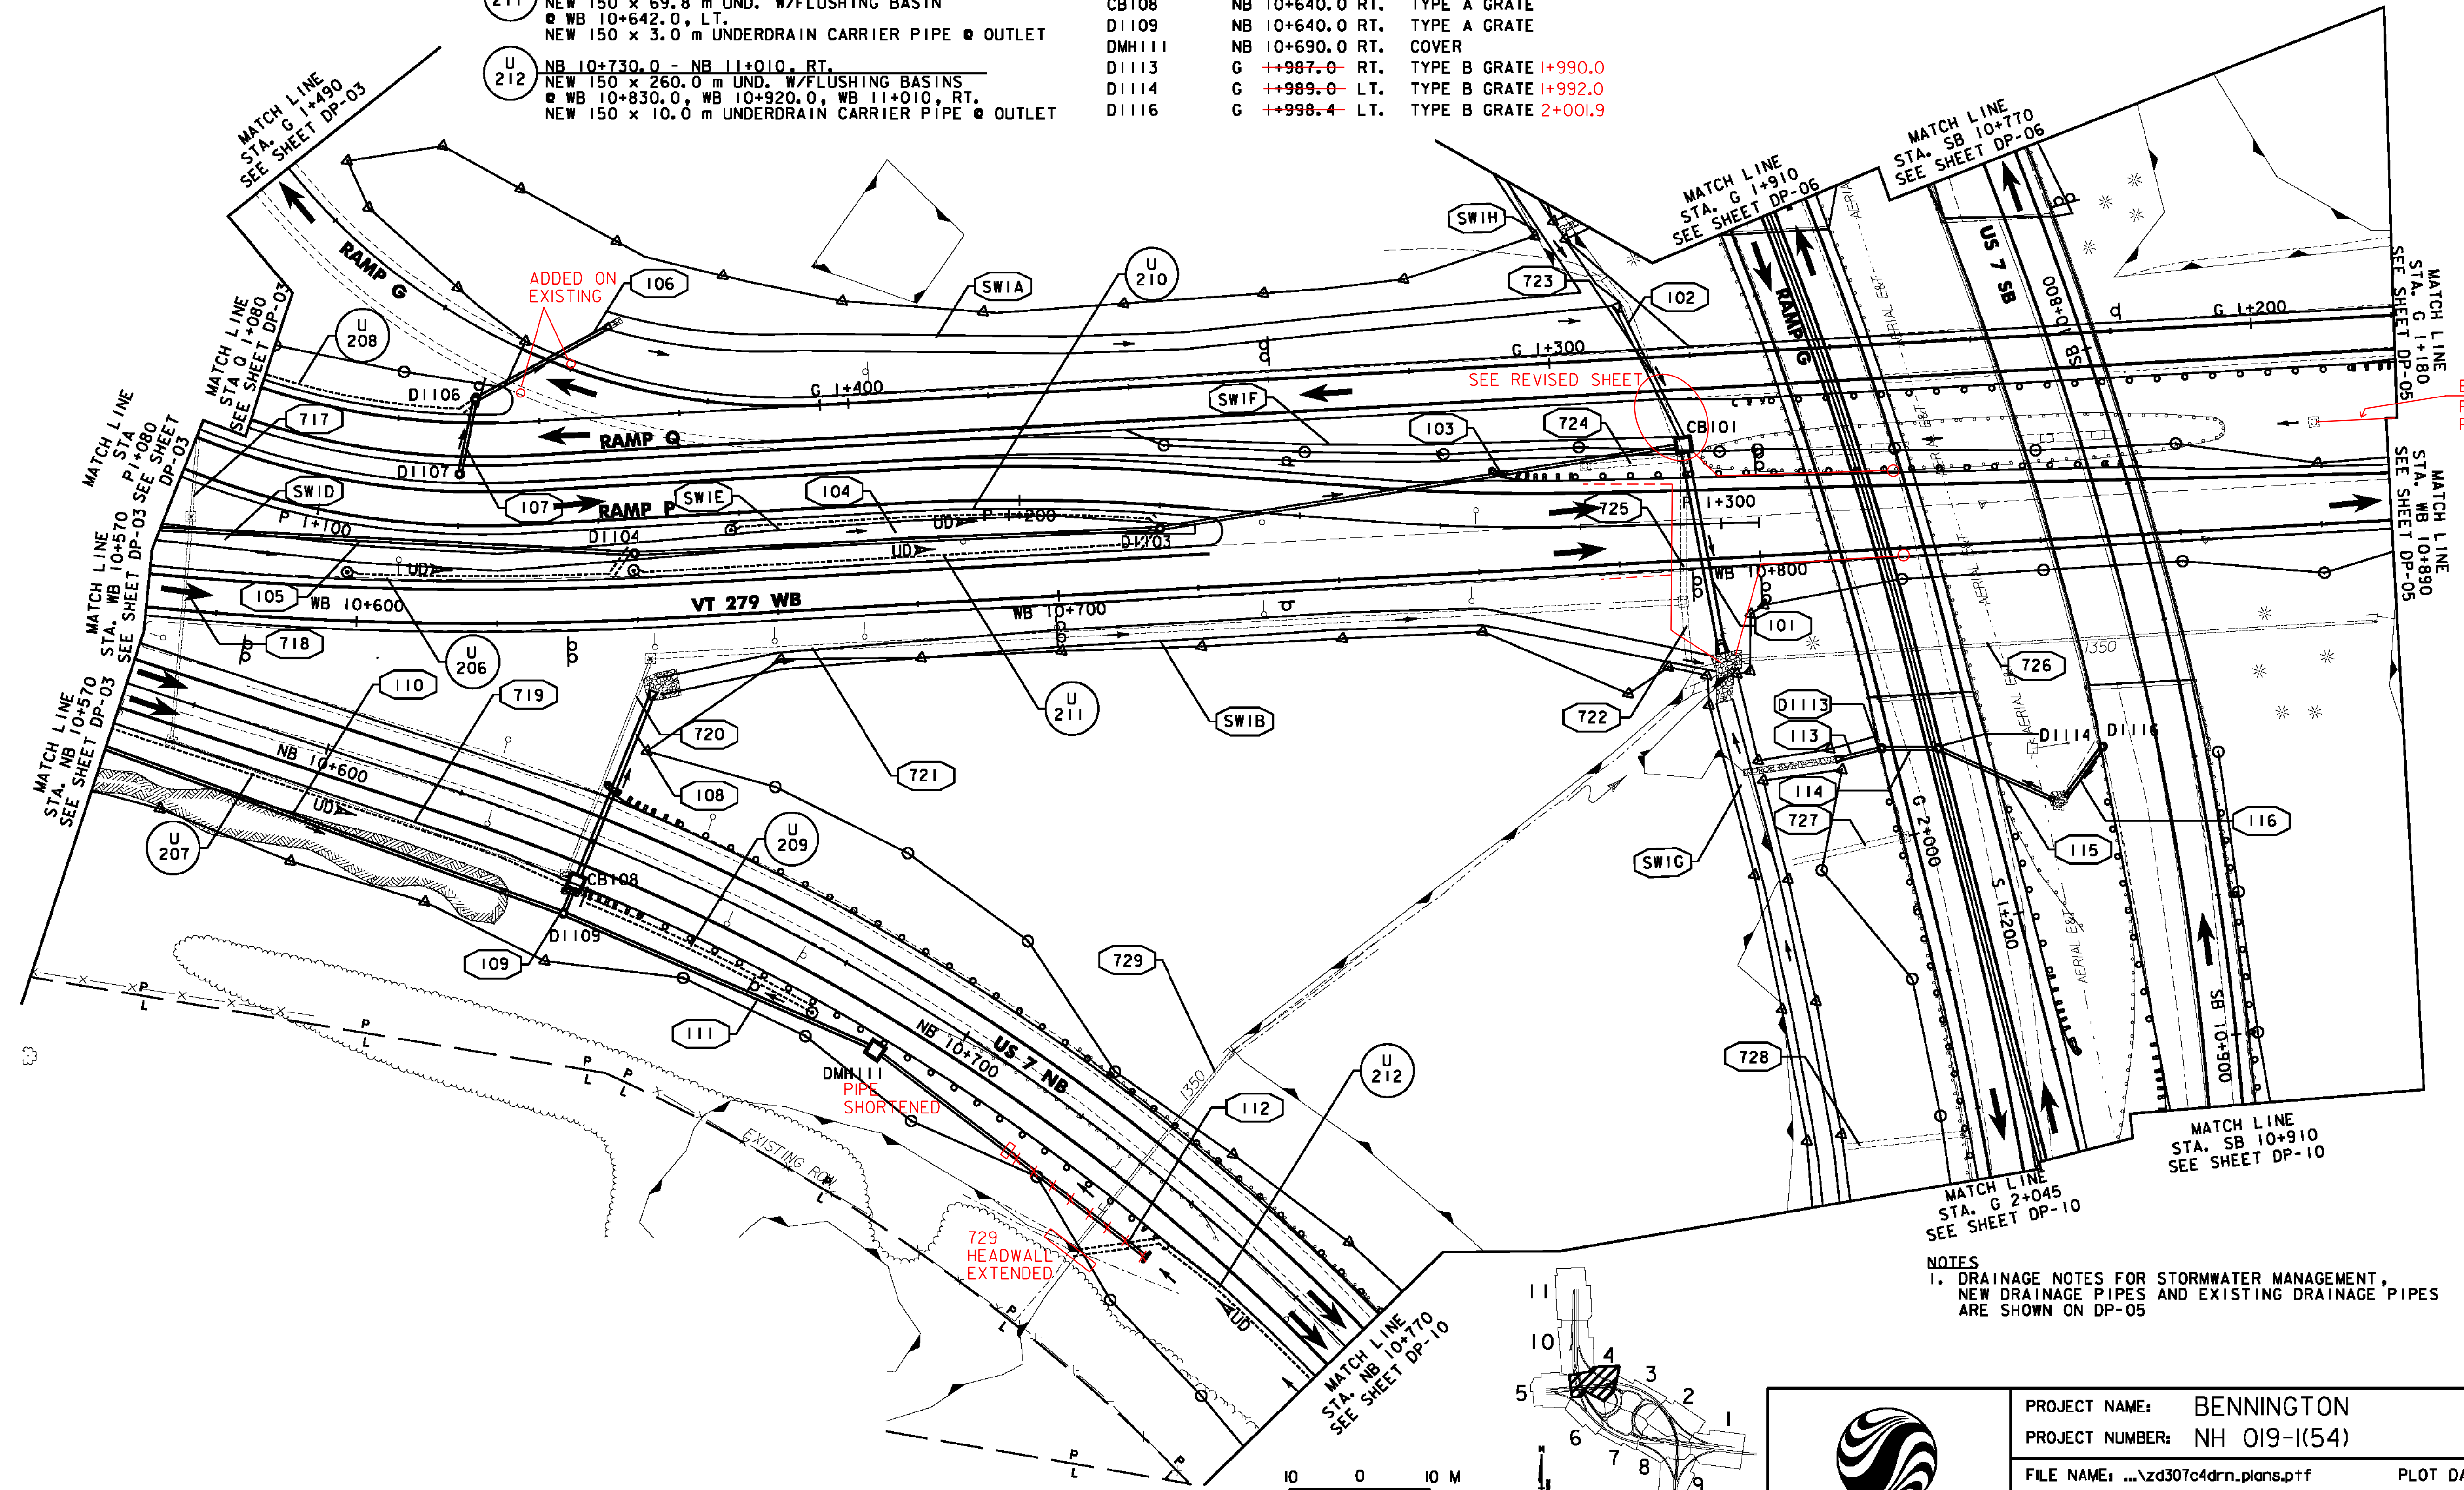


- UNDERDRAIN**
- U 206 WB 10+600.0 - WB 10+640.0, LT.
NEW 150 x 37.0 m UND. W/FLUSHING BASIN
WB 10+600.0, LT.
NEW 150 x 3.0 m UNDERDRAIN CARRIER PIPE @ OUTLET
 - U 209 NB 10+640.0 - NB 10+680.0, RT.
NEW 150 x 37.0 m UND. W/FLUSHING BASIN
NB 10+680.0, RT.
 - U 210 P 1+160.0 - P 1+220.0, RT.
NEW 150 x 57.0 m UND. W/FLUSHING BASIN
P 1+160.0
NEW 150 x 3.0 m UNDERDRAIN CARRIER PIPE
 - U 211 WB 10+642.0 - WB 10+714.8, LT.
NEW 150 x 69.8 m UND. W/FLUSHING BASIN
WB 10+642.0, LT.
NEW 150 x 3.0 m UNDERDRAIN CARRIER PIPE @ OUTLET
 - U 212 NB 10+730.0 - NB 11+010, RT.
NEW 150 x 260.0 m UND. W/FLUSHING BASINS
WB 10+830.0, WB 10+920.0, WB 11+010, RT.
NEW 150 x 10.0 m UNDERDRAIN CARRIER PIPE @ OUTLET

NEW DRAINAGE STRUCTURES

STRUCTURE #	LOCATION	COMMENTS
CB101	WB 10+790.0 LT.	TYPE A GRATE
D1103	P 1+220.0 RT.	TYPE B GRATE
D1104	WB 10+640.0 LT.	TYPE B GRATE
D1106	O 1+049.1 RT.	TYPE B GRATE
D1107	P 1+120.0 LT.	TYPE B GRATE
CB108	NB 10+640.0 RT.	TYPE A GRATE
D1109	NB 10+640.0 RT.	TYPE A GRATE
DM1111	NB 10+690.0 RT.	COVER
D1113	G ++987.0 RT.	TYPE B GRATE 1+990.0
D1114	G ++989.0 LT.	TYPE B GRATE 1+992.0
D1116	G ++998.4 LT.	TYPE B GRATE 2+001.9

--- EXISTING UNDERDRAIN
 --- NEW/ADDED UNDERDRAIN
 O NEW FLUSHING BASIN

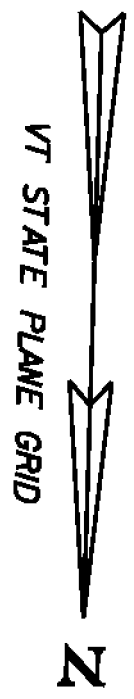

EXISTING PIPE FILLED WITH FLOWABLE FILL



ADDED ON EXISTING

SEE REVISED SHEET

DM1111 PIPE SHORTENED

729 HEADWALL EXTENDED

NOTES
 1. DRAINAGE NOTES FOR STORMWATER MANAGEMENT, NEW DRAINAGE PIPES AND EXISTING DRAINAGE PIPES ARE SHOWN ON DP-05

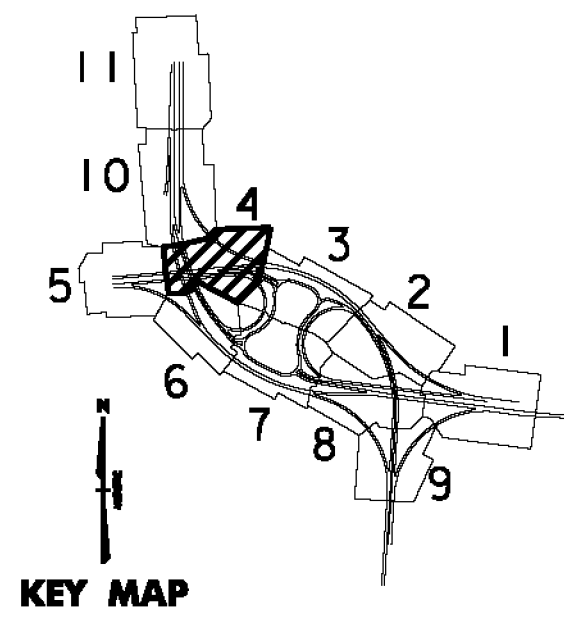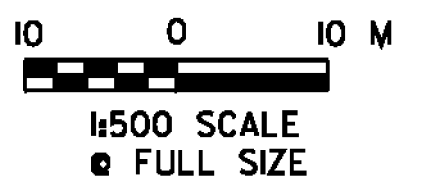

PROJECT NAME: BENNINGTON
 PROJECT NUMBER: NH 019-(K54)
 FILE NAME: ...zd307c4drn_plans.ptf
 DESIGN SUPERVISOR: GREG EDWARDS
 DESIGNED BY: MARC FOISY
 DRAINAGE PLANS DP-04

PLOT DATE: 1/26/2010
 DRAWN BY: STANTEC
 CHECKED BY: GARY SANTY
 SHEET 130 OF 468

1/26/2010 4:48:38 PM v:\1953\getlive\19530002\tramsport\ref\ion\dr\awing\com\tr\cst\4\p\st- files\z6307\c4drn_plans.ppt