


DR-315 + DR-316 REVISIONS

PIPE #	LOCATION	NEW DRAINAGE PIPES	COMMENTS
309	STA. SB 9+915.0 LT.		300 x 5.6 m PCCSP END SECTION AT OUTLET STONE FILL TYPE II OUTLET PROTECTION
310	STA. SB 9+840.0 LT.		300 x 5.5 m PCCSP END SECTION AT OUTLET STONE FILL TYPE II OUTLET PROTECTION
311	STA. SB 9+765.0 LT.		450 x 8.9 m PCCSP END SECTION AT OUTLET STONE FILL TYPE II OUTLET PROTECTION
312	STA. SB 9+765.0 RT. - LT.		450 x 11.6 m OPTION 3
313	STA. NB 9+760.0 RT.		450 x 8.1 m OPTION 3 END SECTION AT OUTLET STONE FILL TYPE I OUTLET PROTECTION
314	STA. NB 9+760.0 LT. - RT.		450 x 7.6 m OPTION 1
315	STA. L 1+110.0 RT. - LT.		450 x 14.8 m OPTION 1 END SECTION AT OUTLET STONE FILL TYPE I OUTLET PROTECTION
316	STA. L 1+185.0 RT. - LT.		450 x 13.7 m OPTION 1 END SECTION AT OUTLET STONE FILL TYPE I OUTLET PROTECTION


STRUCTURE #	LOCATION	STORMWATER MANAGEMENT	COMMENTS
SW3C	SB 9+800.0 - SB 10+140.0 LT.		CONST. VEGETATED TREATMENT SWALE (SEE SHEET SWM-1 FOR DETAILS)

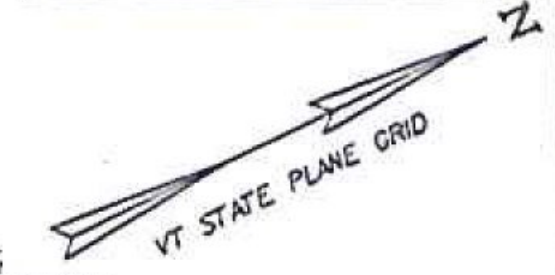

PIPE #	LOCATION	EXISTING DRAINAGE PIPES	COMMENTS
348	STA. L 1+178 RT. - LT.		RETAIN EXISTING PIPE AND INLET
752	STA. SB 9+916 LT.		REMOVE EXISTING PIPE AND INLET
753	STA. SB 9+824 LT.		REMOVE EXISTING PIPE AND INLET
754	STA. L 1+149 - SB 9+813 RT. - LT.		RETAIN EXISTING CULVERT
755	STA. NB 9+689 RT.		REMOVE EXISTING PIPE AND INLET
756	STA. NB 9+598 LT.		REMOVE EXISTING PIPE AND INLET
757	STA. SB 9+765 LT.		REMOVE EXISTING PIPE AND INLET
758	STA. NB 9+522 RT. - LT.		RETAIN EXISTING PIPE AND INLET
759	STA. NB 9+522 LT.		RETAIN EXISTING PIPE AND INLET

STRUCTURE #	LOCATION	NEW DRAINAGE STRUCTURES	COMMENTS
PRCCD1309	SB 9+915.0 LT.		PRCCD I
PRCCD1310	SB 9+840.0 LT.		PRCCD I
D1311	SB 9+765.0 LT.		TYPE B GRATE
D1312	SB 9+765.0 RT.		TYPE B GRATE
D1313	NB 9+760.0 RT.		TYPE B GRATE
D1314	NB 9+760.0 LT.		TYPE B GRATE
D1315	L 1+110.0 RT.		TYPE B GRATE
D1316	L 1+185.0 RT.		TYPE B GRATE

DR 315 & 316 REVISIONS

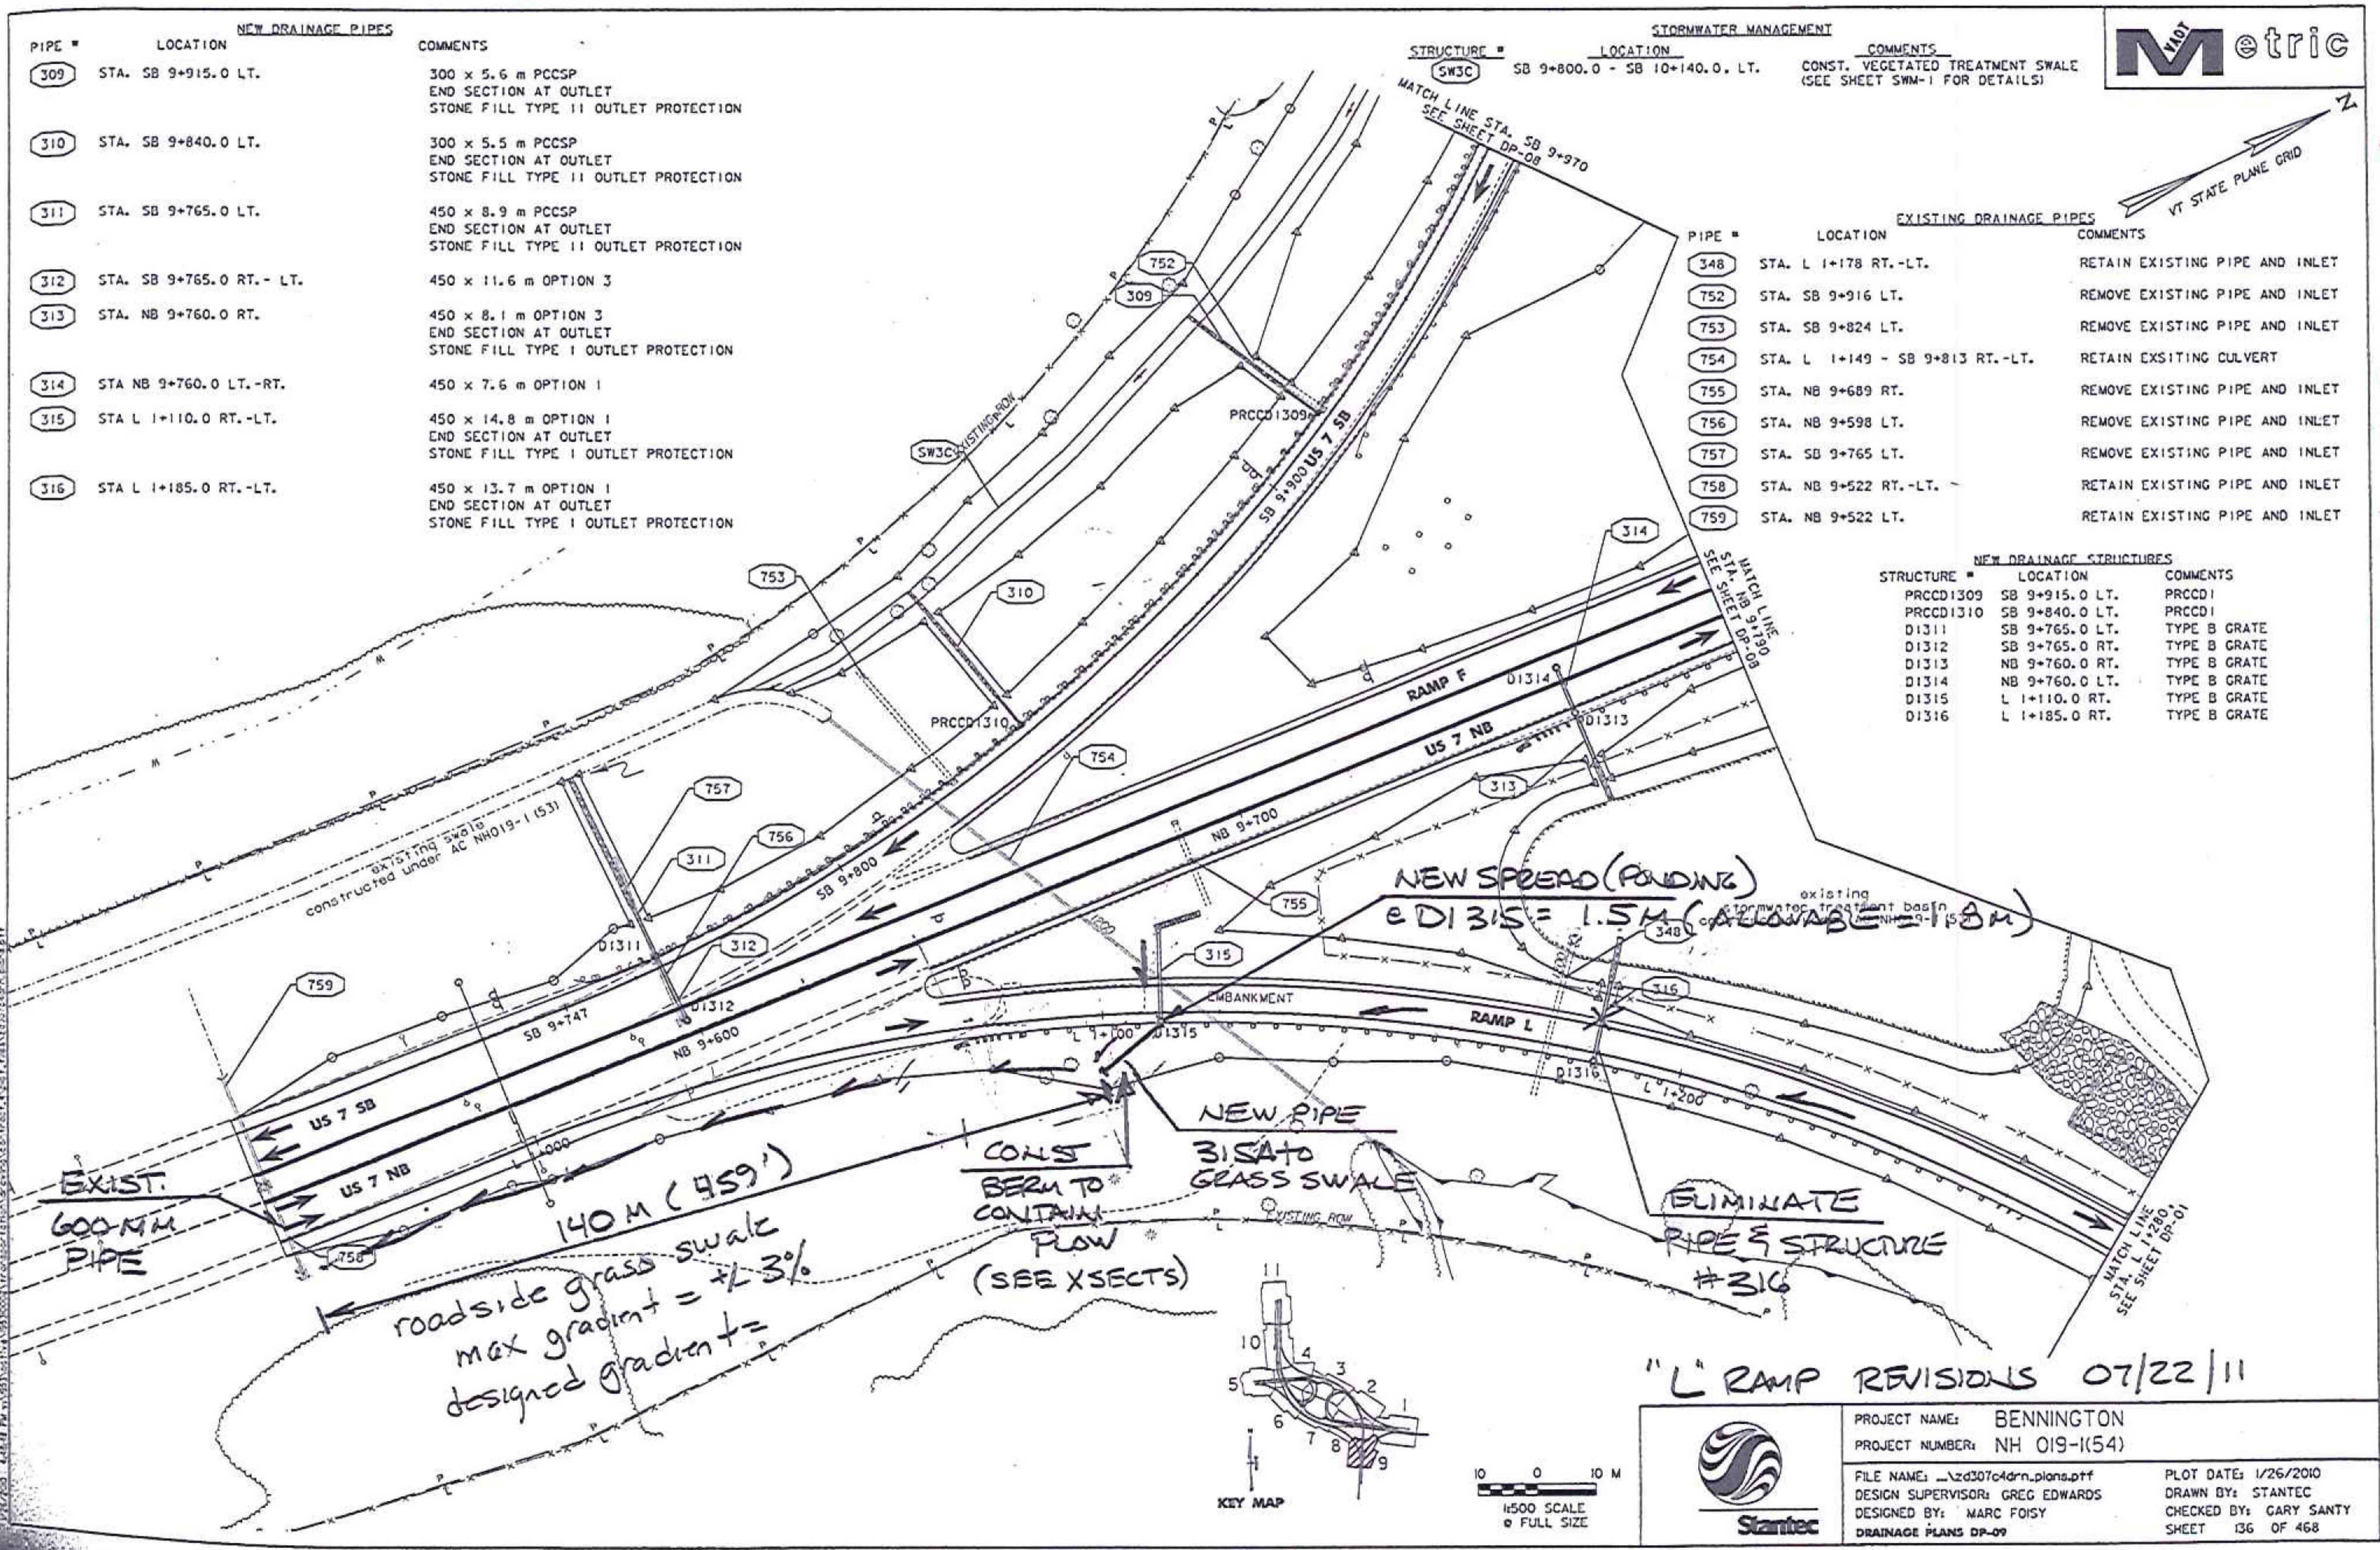

"L" RAMP REVISIONS 07/22/11

	PROJECT NAME: BENNINGTON	PLOT DATE: 1/26/2010
	PROJECT NUMBER: NH 019-1(54)	DRAWN BY: STANTEC
FILE NAME: _\zd307\adm\plans.pff	DESIGN SUPERVISOR: GREG EDWARDS	CHECKED BY: GARY SANTY
DESIGNED BY: MARC FOISY	DRAINAGE PLANS DP-09	SHEET 136 OF 468