

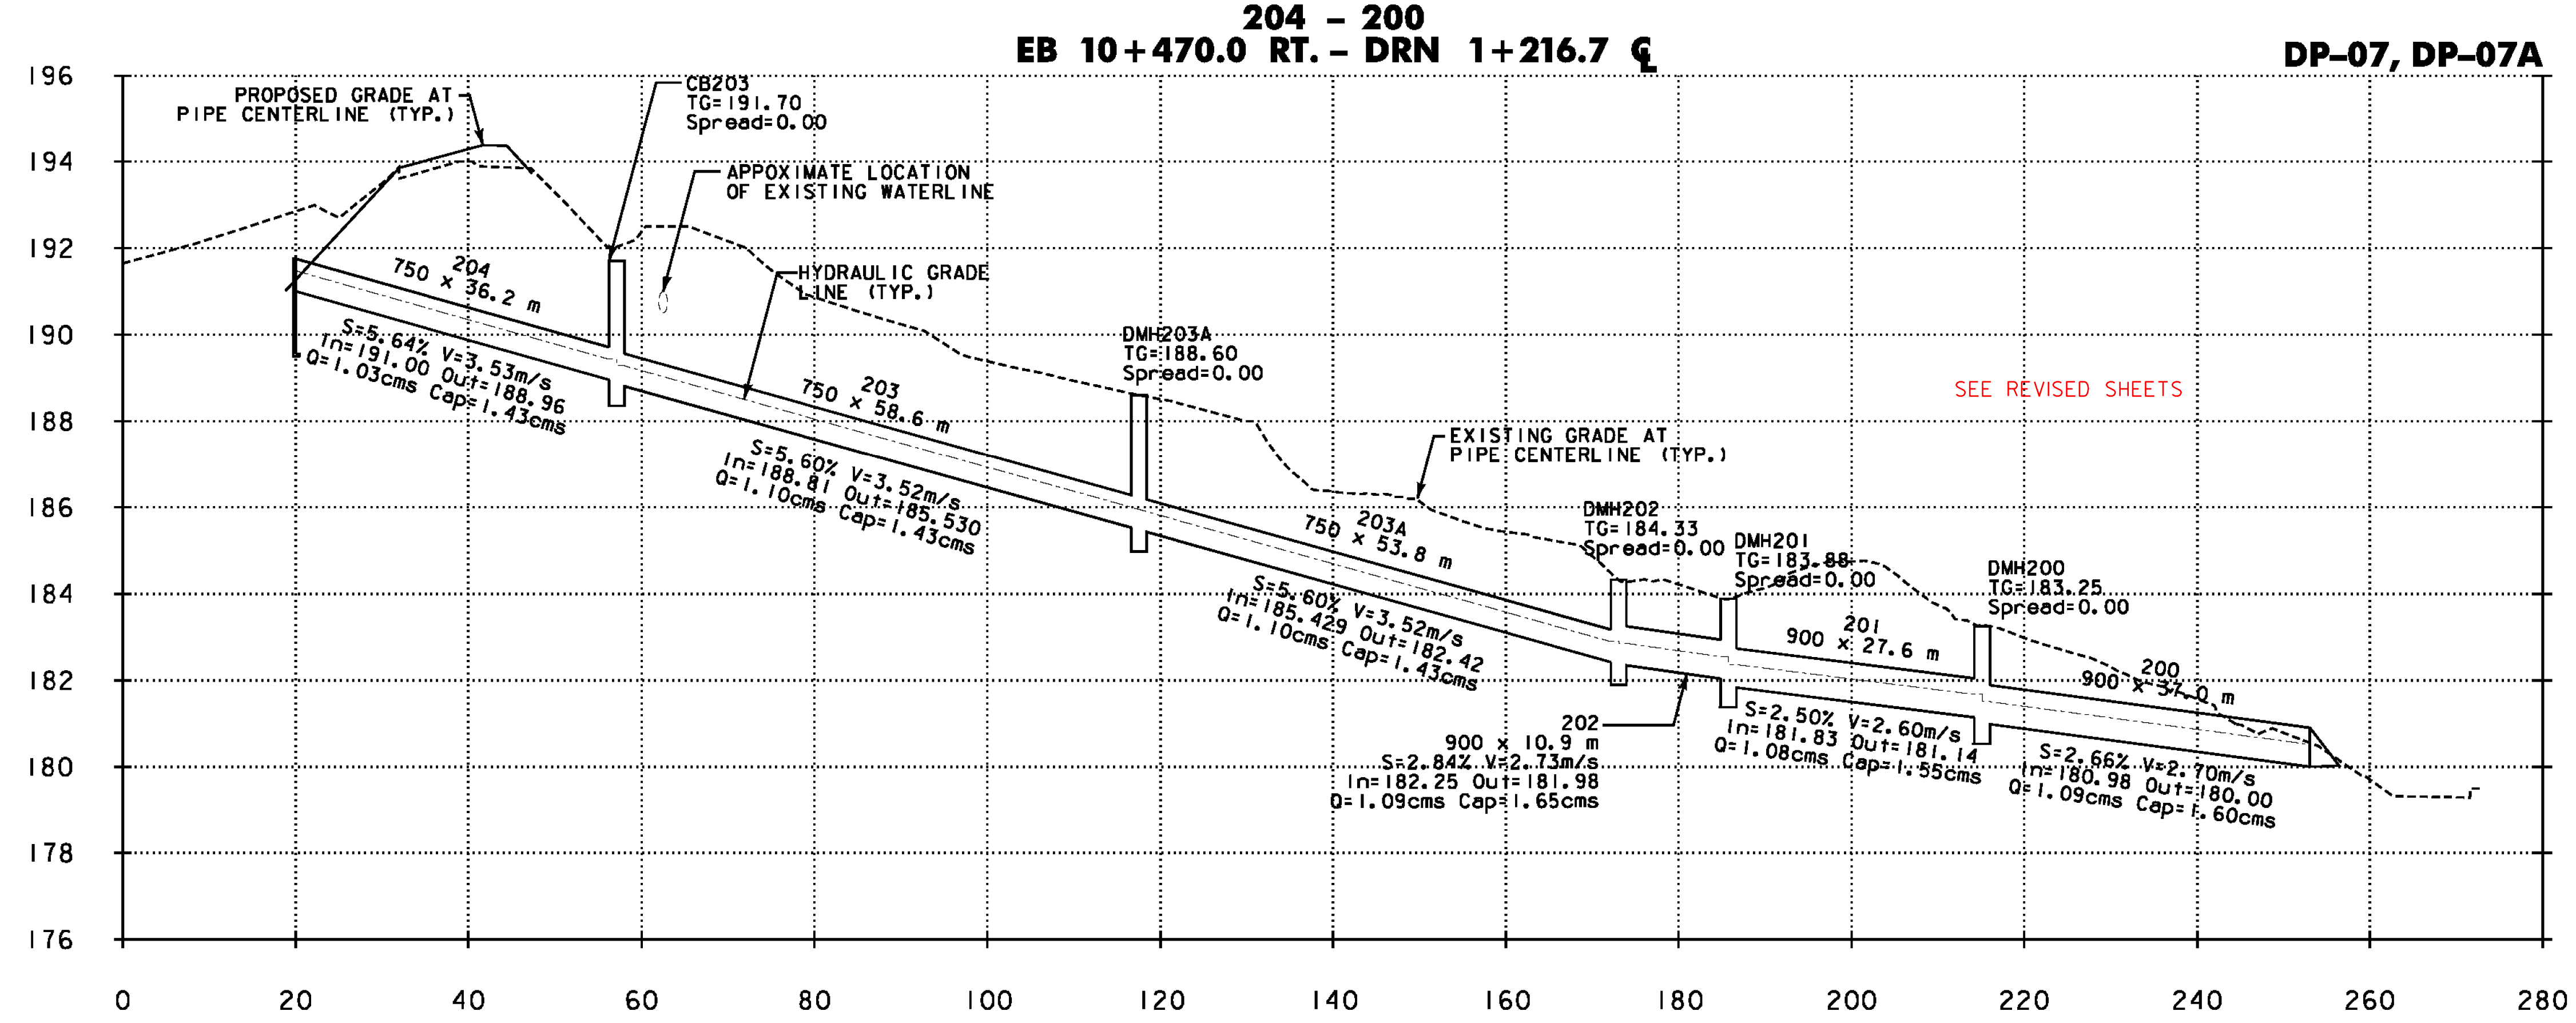
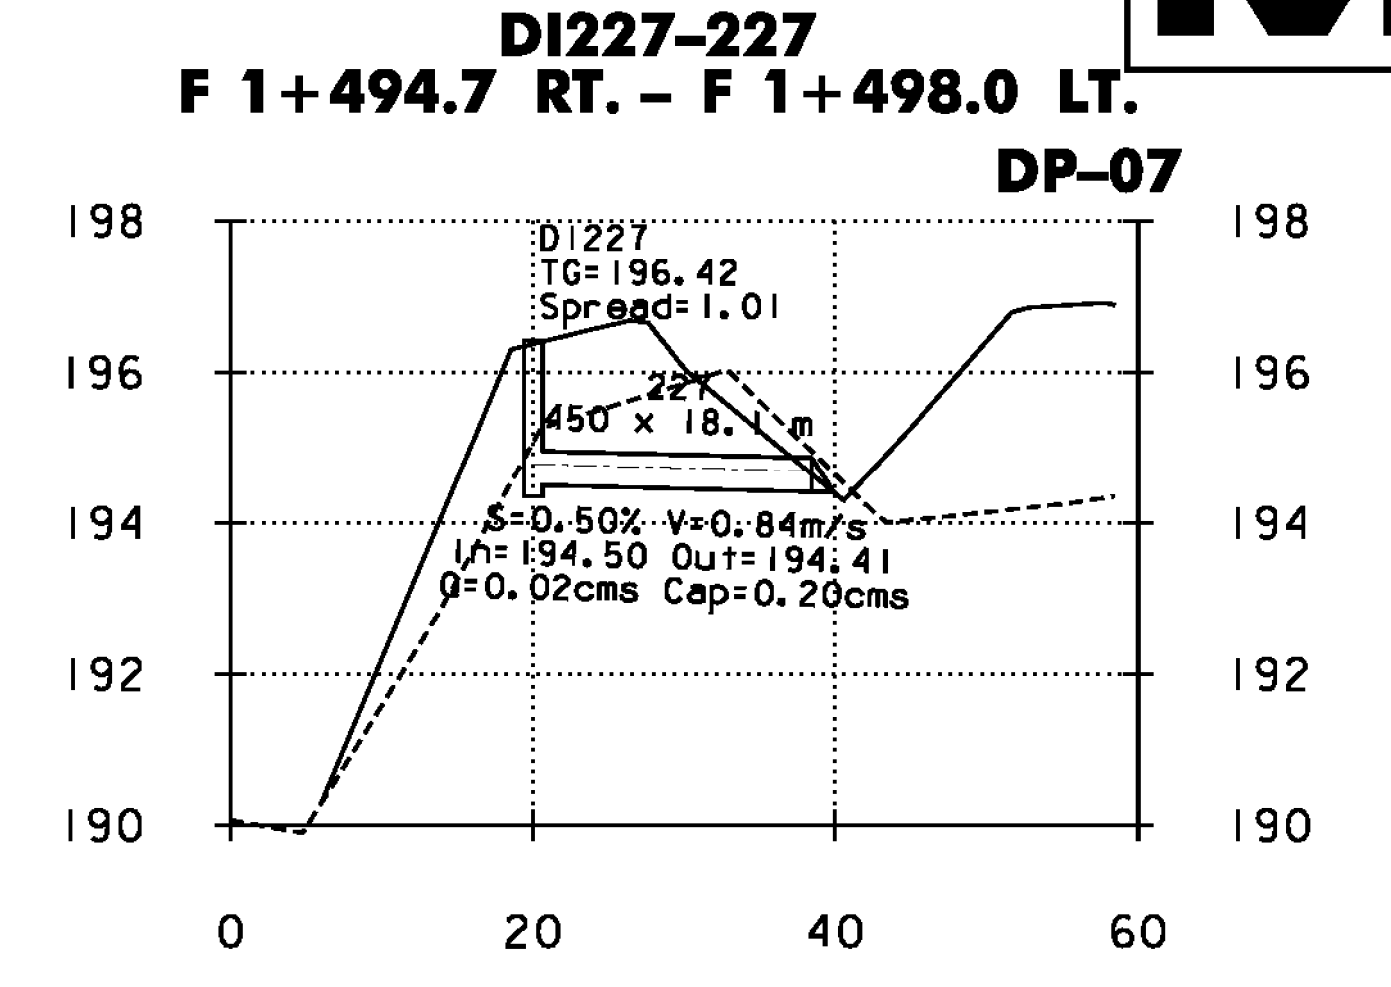


DP-XX = REFERENCE TO CORRESPONDING DRAINAGE PLAN SHEET



DI229 - 229
S 2+060.0 LT. - S 2+060.0 RT.

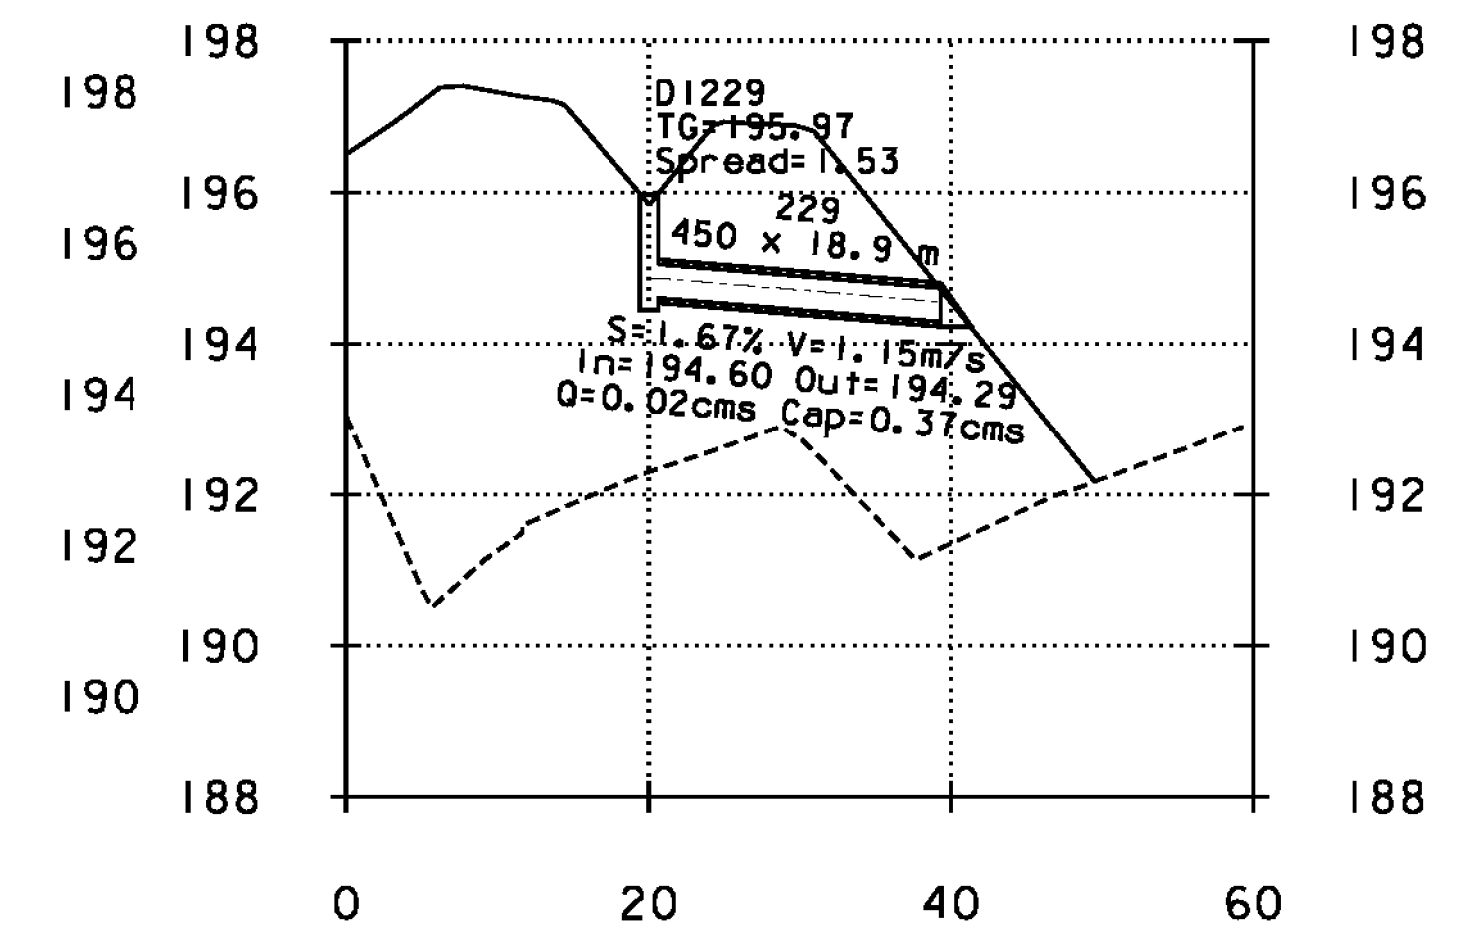

DI239 - 239
R 1+140.0 LT. - R 1+140.0 LT. DP-06

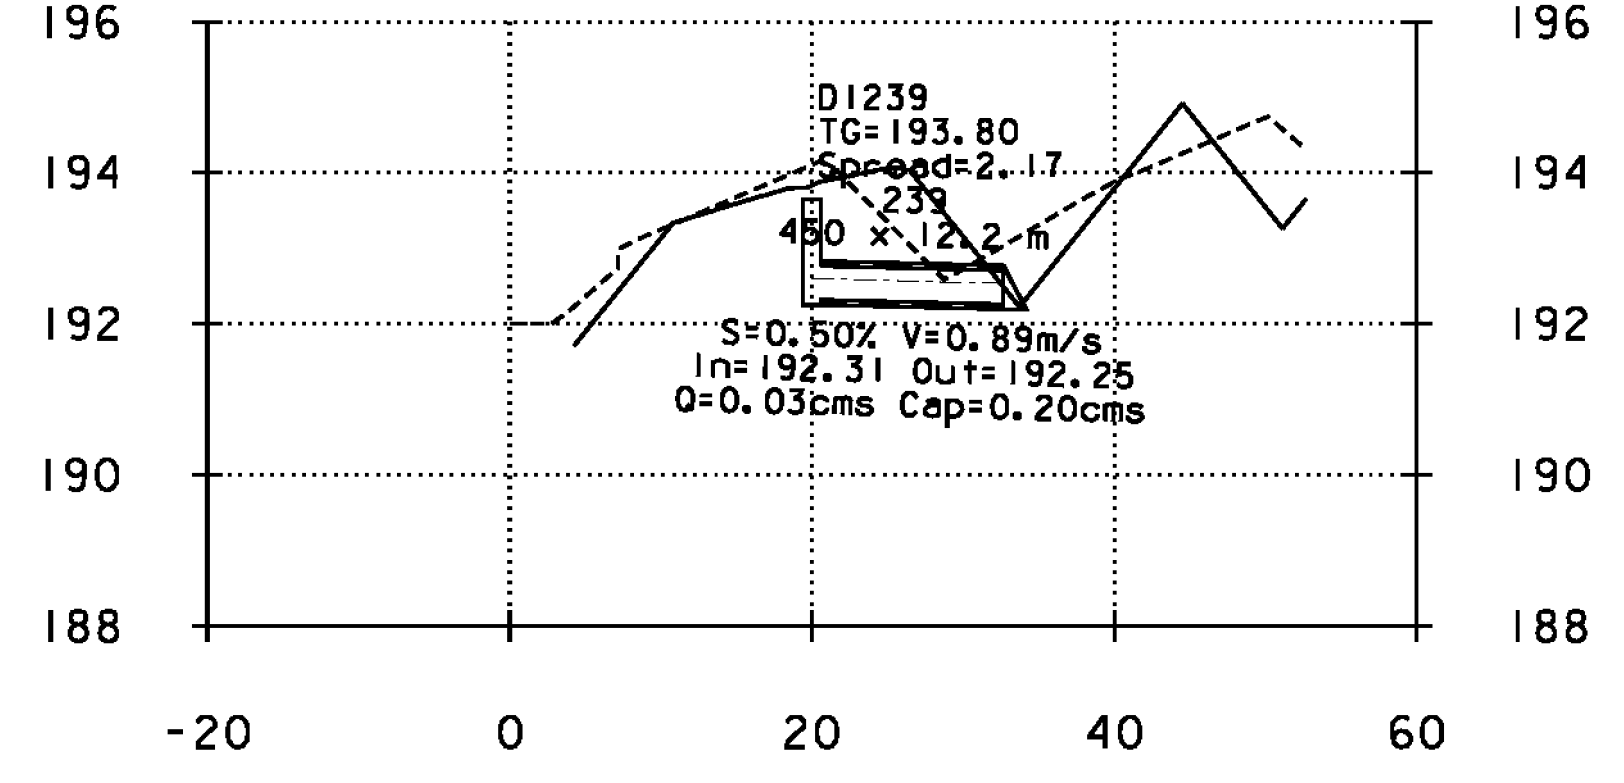

DI238 - 238
G 1+840.0 LT. - G 1+840.0 LT. DP-06

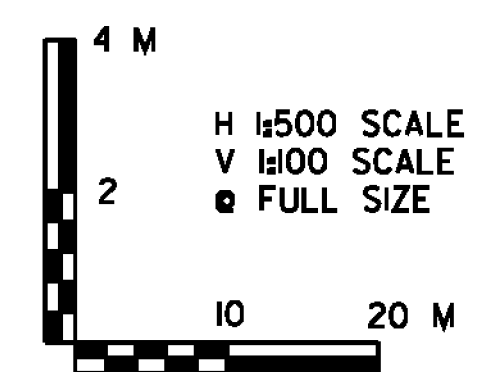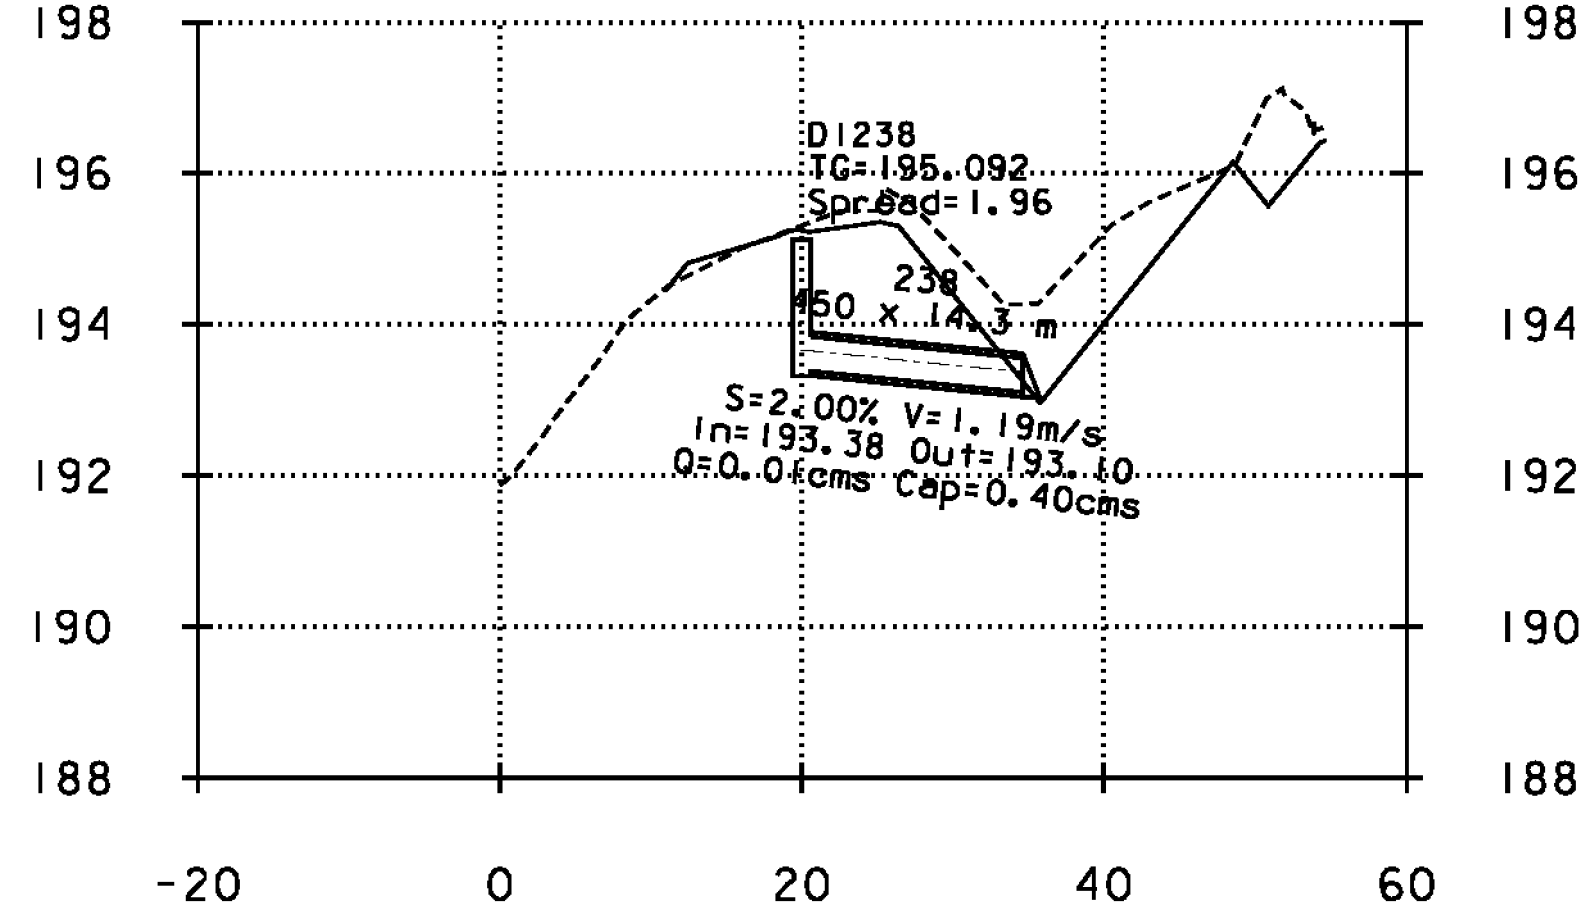

SYSTEM 2



PROJECT NAME:	BENNINGTON
PROJECT NUMBER:	NH 019-(154)
FILE NAME:	...plot_files\zd307c4drn.pro.ptf
DESIGN SUPERVISOR:	GREG EDWARDS
DESIGNED BY:	MARC FOISY
DRAINAGE PROFILE SHEET	DPRO-06
PLOT DATE:	3/16/2010
DRAWN BY:	STANTEC
CHECKED BY:	GARY SANTY
SHEET	144 OF 468

3/16/2010 5:08:06 PM V:\1953\getlive\19530002\tr\anspor\ref\ion\dr\c\w\ng\com\tr\cap\4\p\01 - Files\z307c4drn.pro.ptf