
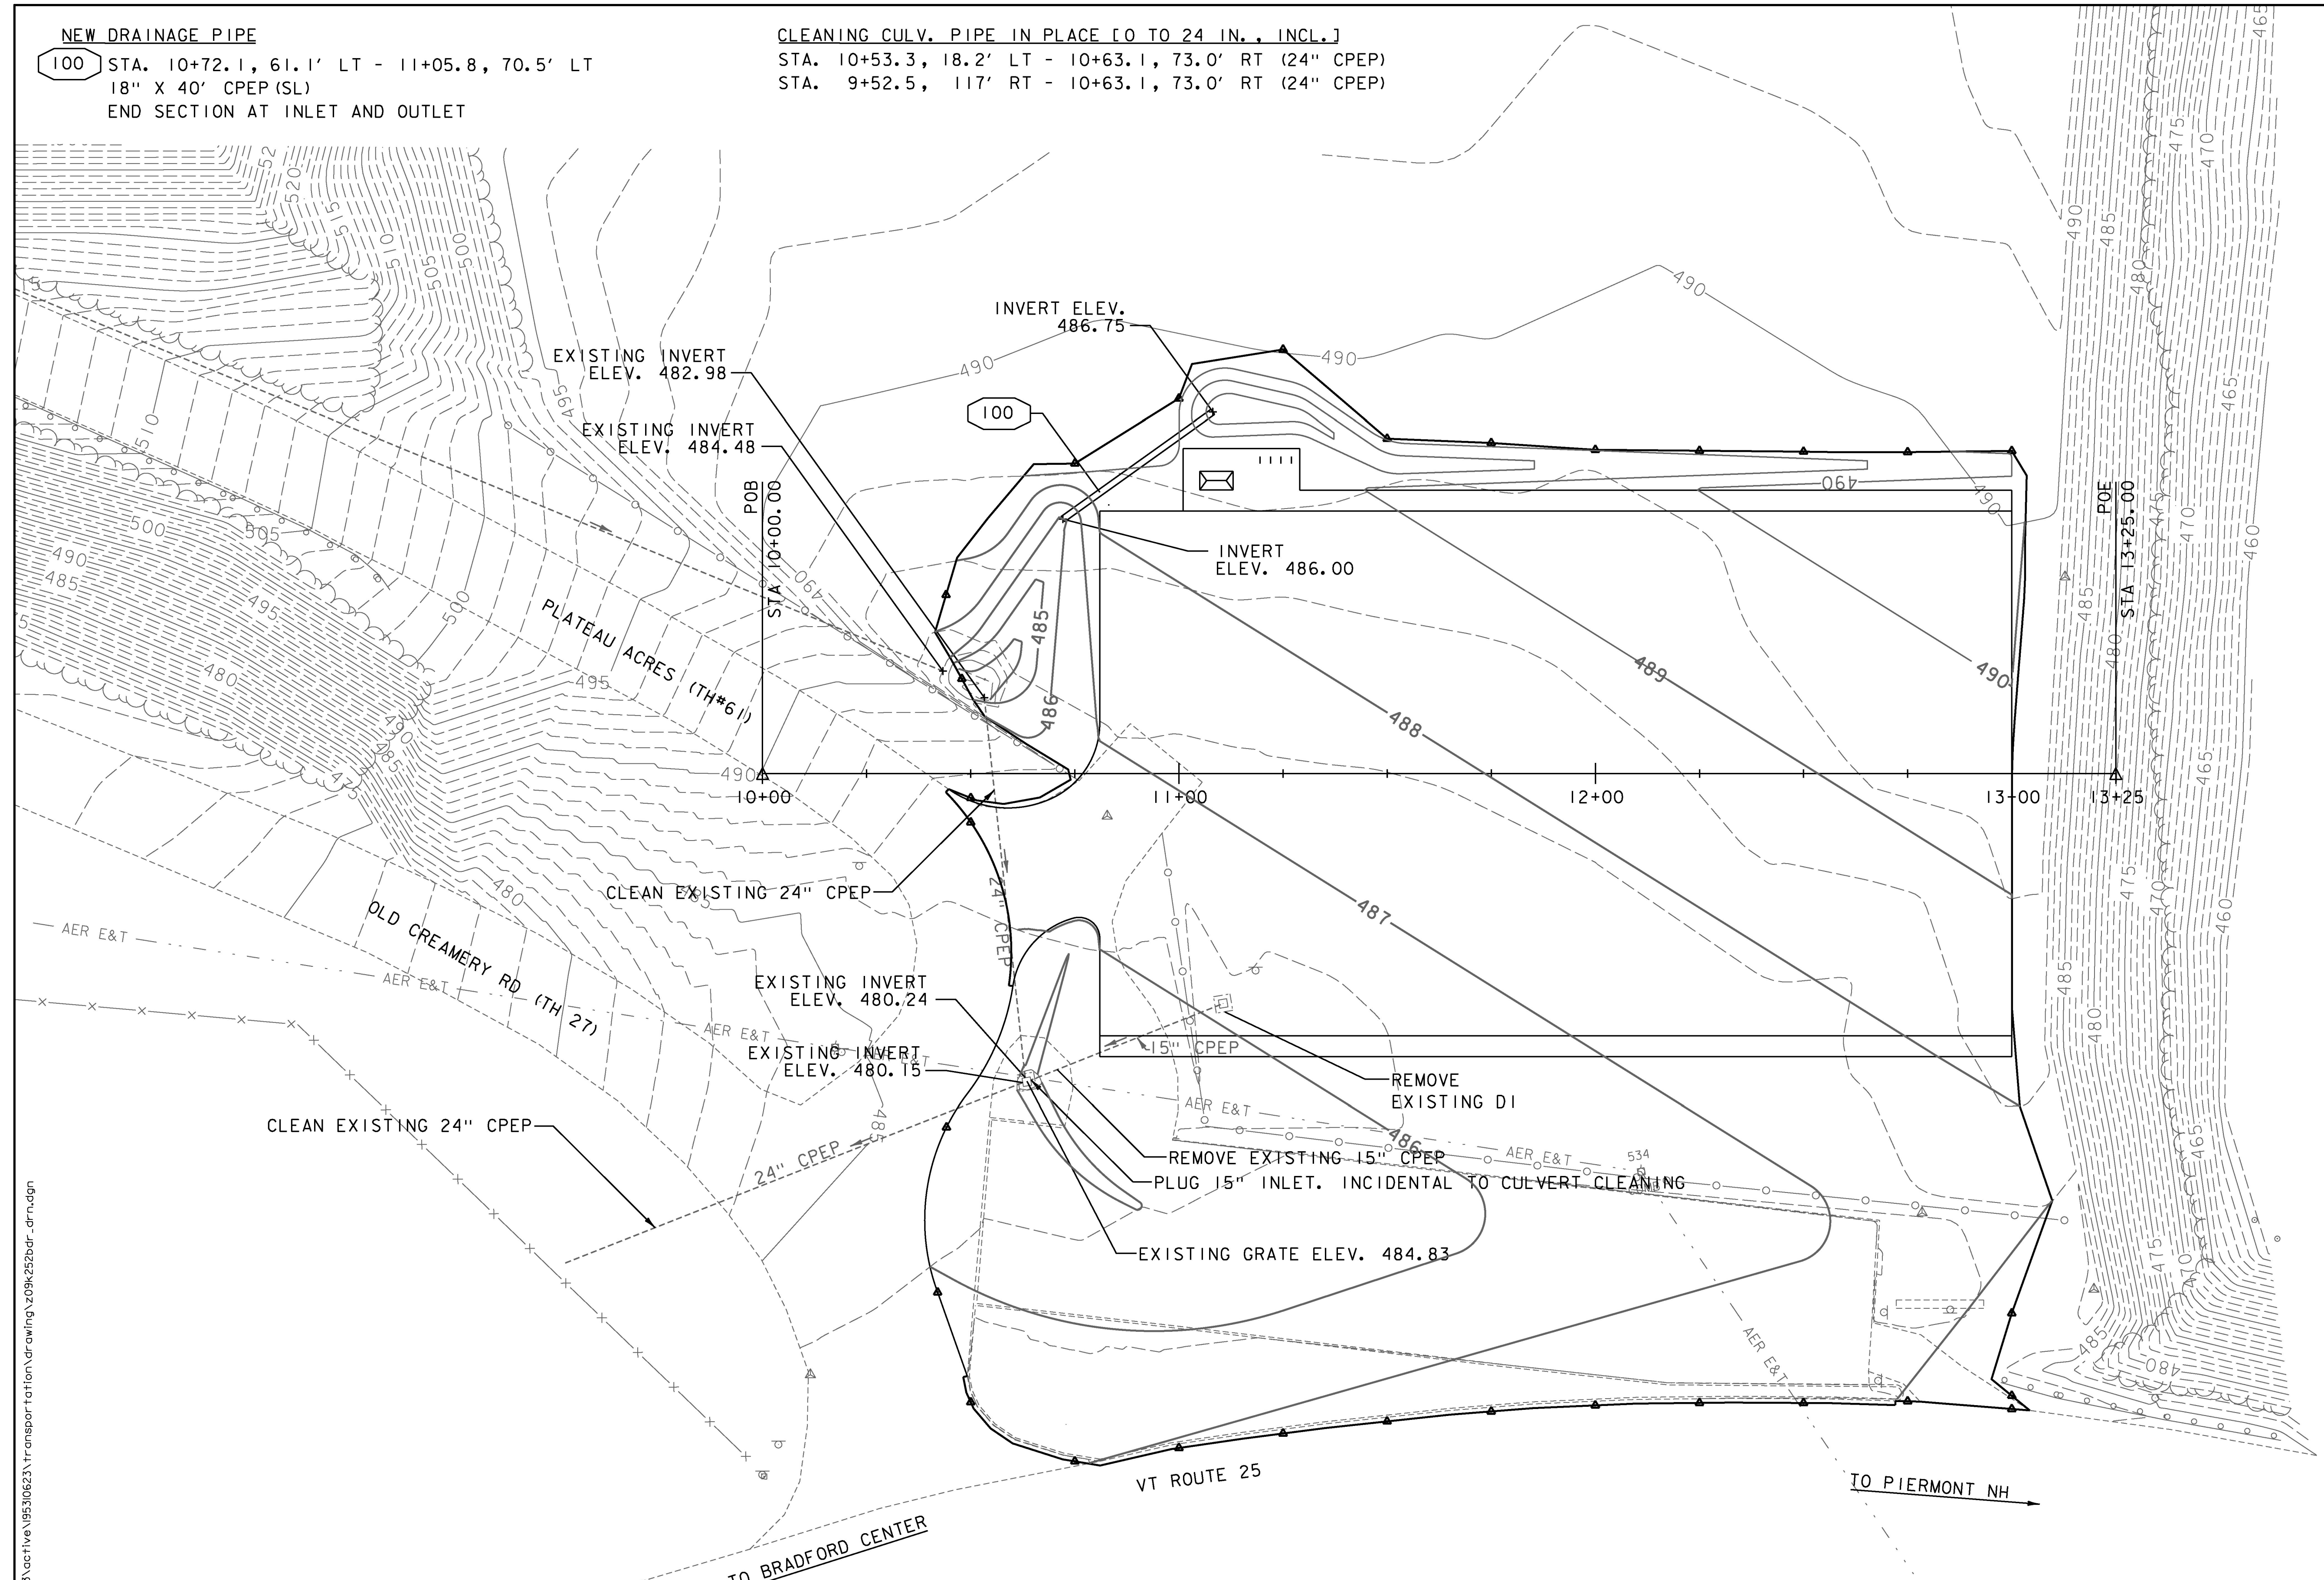


NEW DRAINAGE PIPE
 100 STA. 10+72.1, 61.1' LT - 11+05.8, 70.5' LT
 18" X 40' CPEP (SL)
 END SECTION AT INLET AND OUTLET

CLEANING CULV. PIPE IN PLACE [O TO 24 IN., INCL.]
 STA. 10+53.3, 18.2' LT - 10+63.1, 73.0' RT (24" CPEP)
 STA. 9+52.5, 117' RT - 10+63.1, 73.0' RT (24" CPEP)

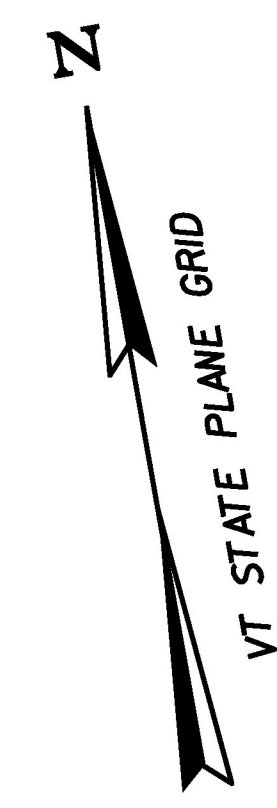

5/22/2014 4:49:25 PM W:\953\active\9530623\transport\ton\drawing\z09k252bdr_drn.dgn

0 20 40
 SCALE
 1"=20' @ FULL SIZE

PROJECT NAME: BRADFORD	PLOT DATE: 5/22/2014
PROJECT NUMBER: CMG PARK (33)	DRAWN BY: P. ARMATA
FILE NAME: z09k252bdr_drn.dgn	DESIGNED BY: I. MAYNARD
PROJECT LEADER: M. FOISY	CHECKED BY: G. SANTY
GRADING AND DRAINAGE PLAN	SHEET 12 OF 33