



PANEL STYLE: STREET NAME 12IN TALL 6IN LETTERS, SSI  
M. U. T. C. D.: 2009 EDITION

**D3-1**

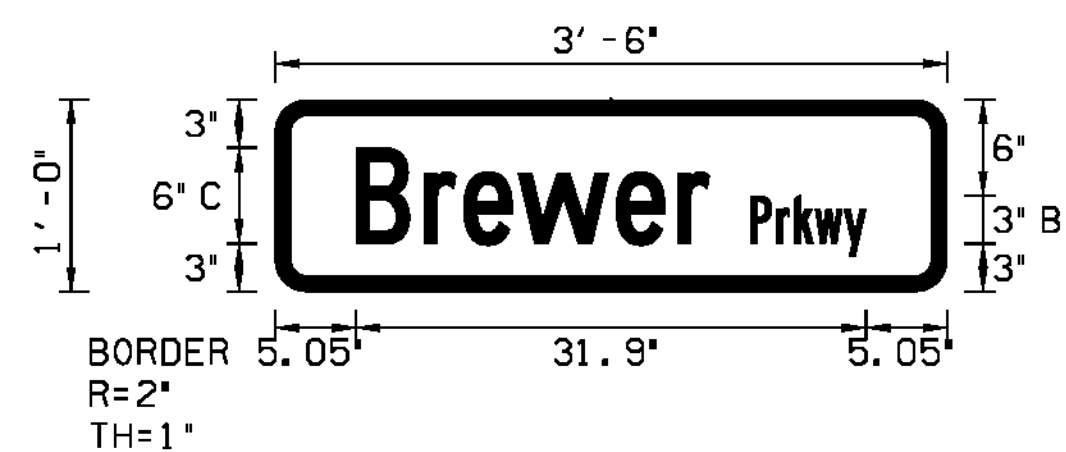


PANEL STYLE: STREET NAME 12IN TALL 6IN LETTERS, SSI  
M. U. T. C. D.: 2009 EDITION

**D3-1**

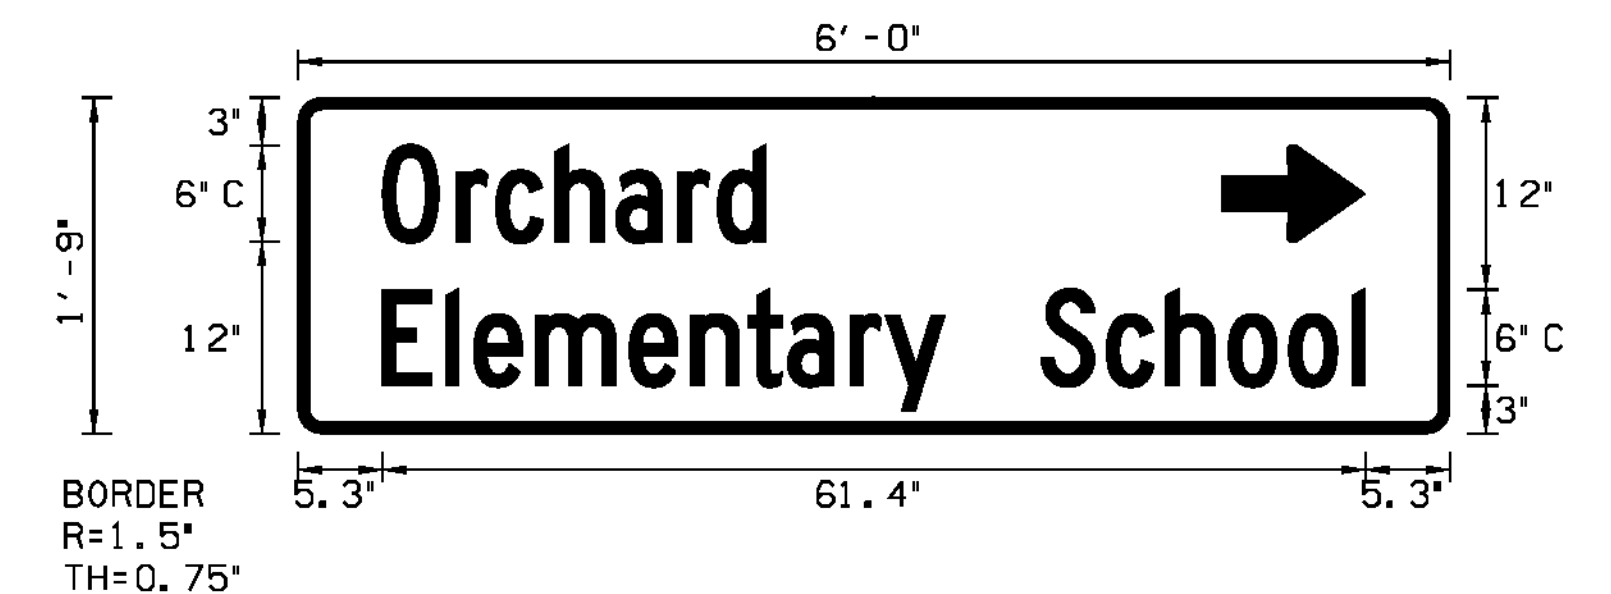


PANEL STYLE: GUIDE SIGN W-ARROW, SSI  
M. U. T. C. D.: 2009 EDITION

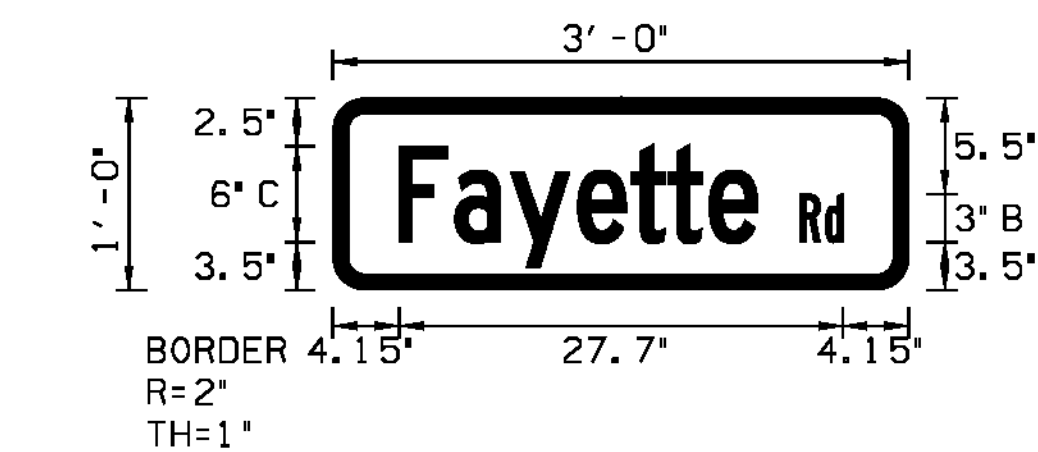


PANEL STYLE: STREET NAME 12IN TALL 6IN LETTERS, SSI  
M. U. T. C. D.: 2009 EDITION

**D3-1**

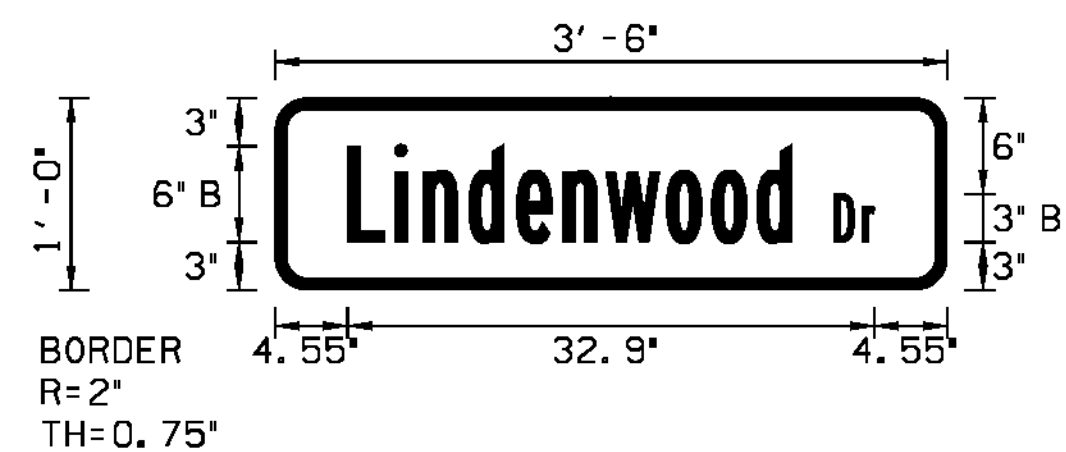


PANEL STYLE: STREET NAME 12IN TALL 6IN LETTERS, SSI  
M. U. T. C. D.: 2009 EDITION

**D3-1**

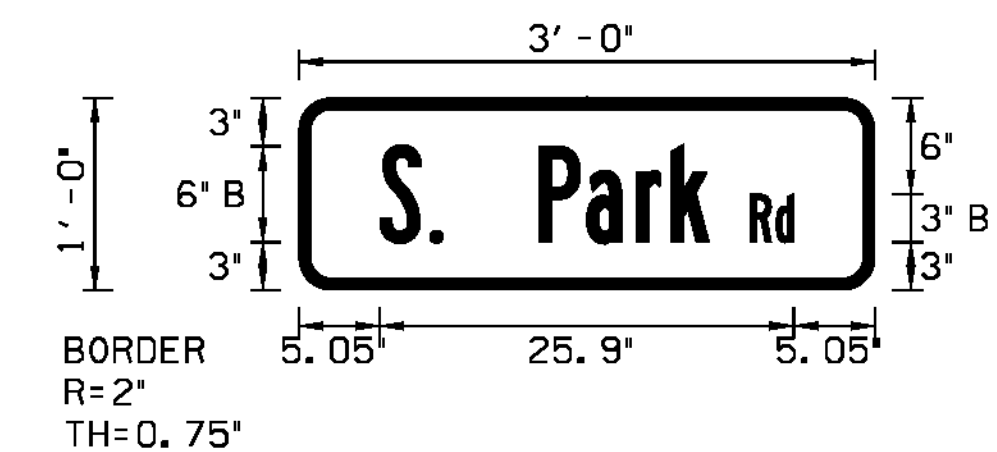


PANEL STYLE: STREET SIGN 12 - 6 IN LETTERS, SSI  
M. U. T. C. D.: 2009 EDITION

**D3-1**

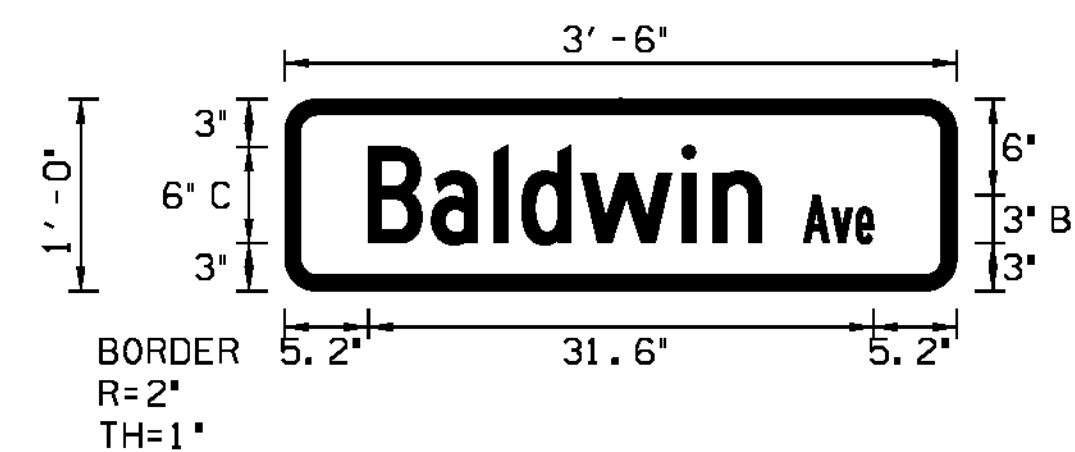


PANEL STYLE: STREET NAME 12IN TALL 6IN LETTERS, SSI  
M. U. T. C. D.: 2009 EDITION

**D3-1**

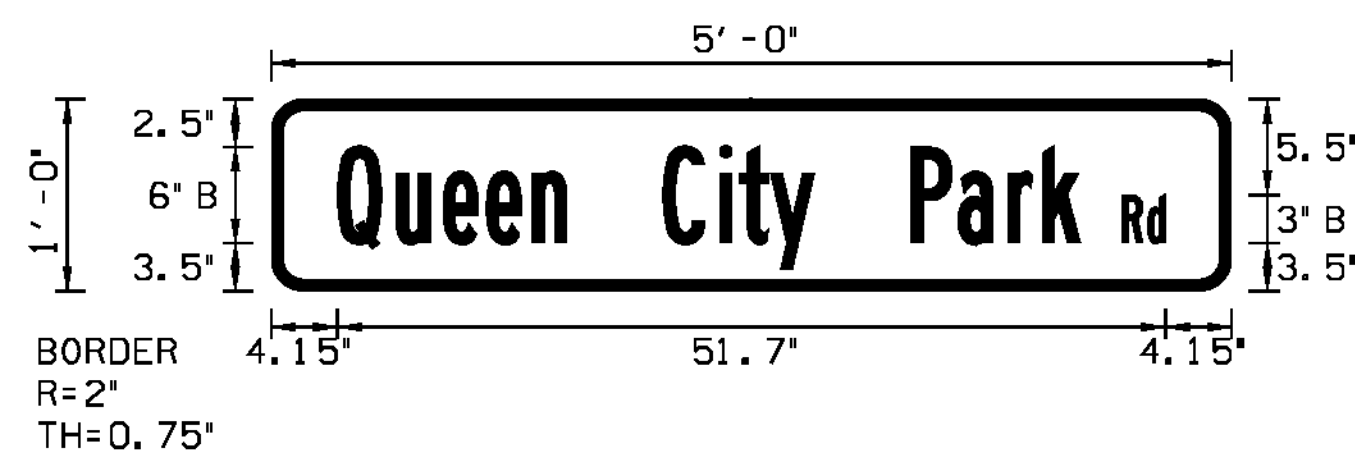


PANEL STYLE: STREET NAME 12IN TALL 6IN LETTERS, SSI  
M. U. T. C. D.: 2009 EDITION

**D3-1**

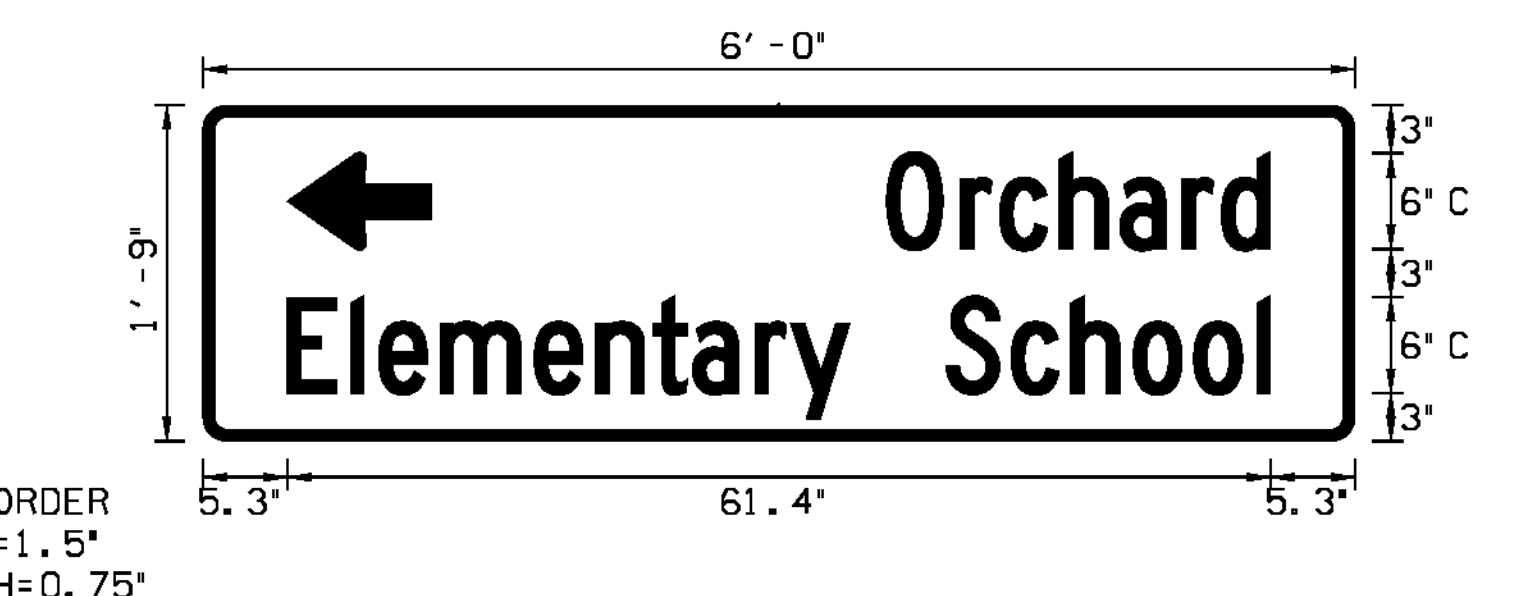


PANEL STYLE: GUIDE SIGN W-ARROW, SSI  
M. U. T. C. D.: 2009 EDITION

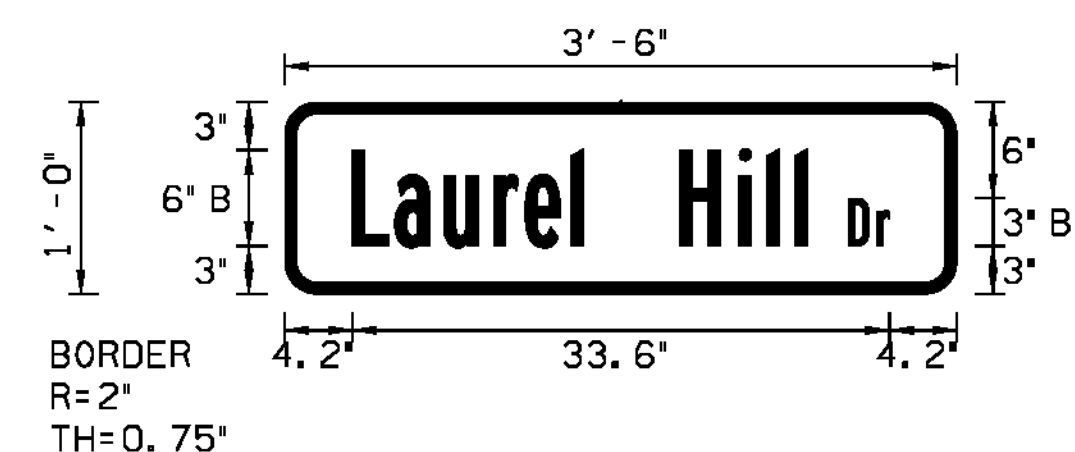

PANEL STYLE: STREET NAME 12IN TALL 6IN LETTERS, SSI  
M. U. T. C. D.: 2009 EDITION

**D3-1**

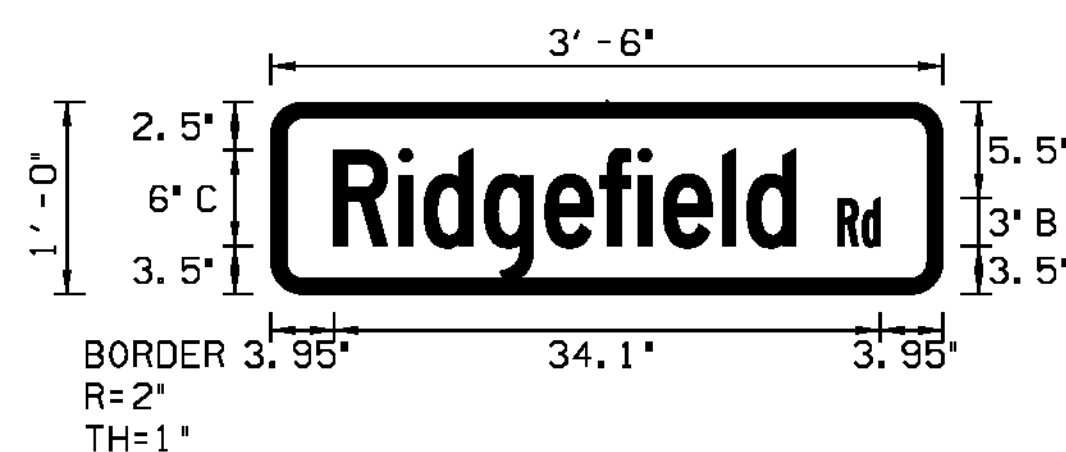

PANEL STYLE: STREET NAME 12IN TALL 6IN LETTERS, SSI  
M. U. T. C. D.: 2009 EDITION

**D3-1**

1.) THE DESTINATION SIGN SHOWN ON THIS SHEET SHALL HAVE WHITE RETROREFLECTIVE ASTM TYPE IIIIS OR IV TEXT, ARROWS AND BORDERS ON A GREEN RETROREFLECTIVE ASTM TYPE IIIIS OR IV BACKGROUND.

1.) IN THE CITY OF SOUTH BURLINGTON STREET SIGNS SHALL BE WHITE LETTERS ON A BLUE BACKGROUND. STREET SIGNS IN THE TOWNS OF CHARLOTTE AND SHELBURNE SHALL BE WHITE LETTERS ON A GREEN BACKGROUND. ALL STREET SIGNS ON THIS SHEET ARE IN THE THE CITY OF SOUTH BURLINGTON.

**NOT TO SCALE**

<b>TRAFFIC SIGN DETAIL SHEET 3</b>	PROJECT NAME: CHARLOTTE - SOUTH BURLINGTON	
	PROJECT NUMBER: NH 2907(I)	
	FILE NAME: p10B206.dgn	PLOT DATE: 4/19/12
	PROJECT LEADER: CDL	DRAWN BY: BMB
	DESIGNED BY: BMB	CHECKED BY: EPD
	PLOT FILE: p10B206_96.f	SHEET 96 OF 107