


STONE FILL, TYPE I
 STA. 113+78.95 - STA. 113+78.95 LT (6.5' X 3.25')
 STA. 114+27.63 - STA. 114+32.89 RT (4.5' X 3.25')
 STA. 115+02.91 - STA. 115+14.10 LT (3.0' WIDE)
 STA. 115+59.30 - STA. 115+95.08 LT (4.5' WIDE)

⑥ NEW 18 INCH DIA. CPEP(SL) PIPE
 FROM STA. 113+83.05 OFFSET 32.00' LT
 TO STA. 114+29.88 OFFSET 35.42' RT
 LENGTH 78'-7"

⑦ NEW 18 INCH DIA. CPEP(SL) PIPE
 FROM STA. 115+12.59 OFFSET 31.00' LT
 TO STA. 115+60.86 OFFSET 31.58' LT
 LENGTH 48'-4"

④ REMOVE EXISTING 18" CGMP
 FROM STA. 114+02.54 OFFSET 27.25' LT
 TO STA. 114+25.12 OFFSET 23.00' RT
 LENGTH 55'-0"

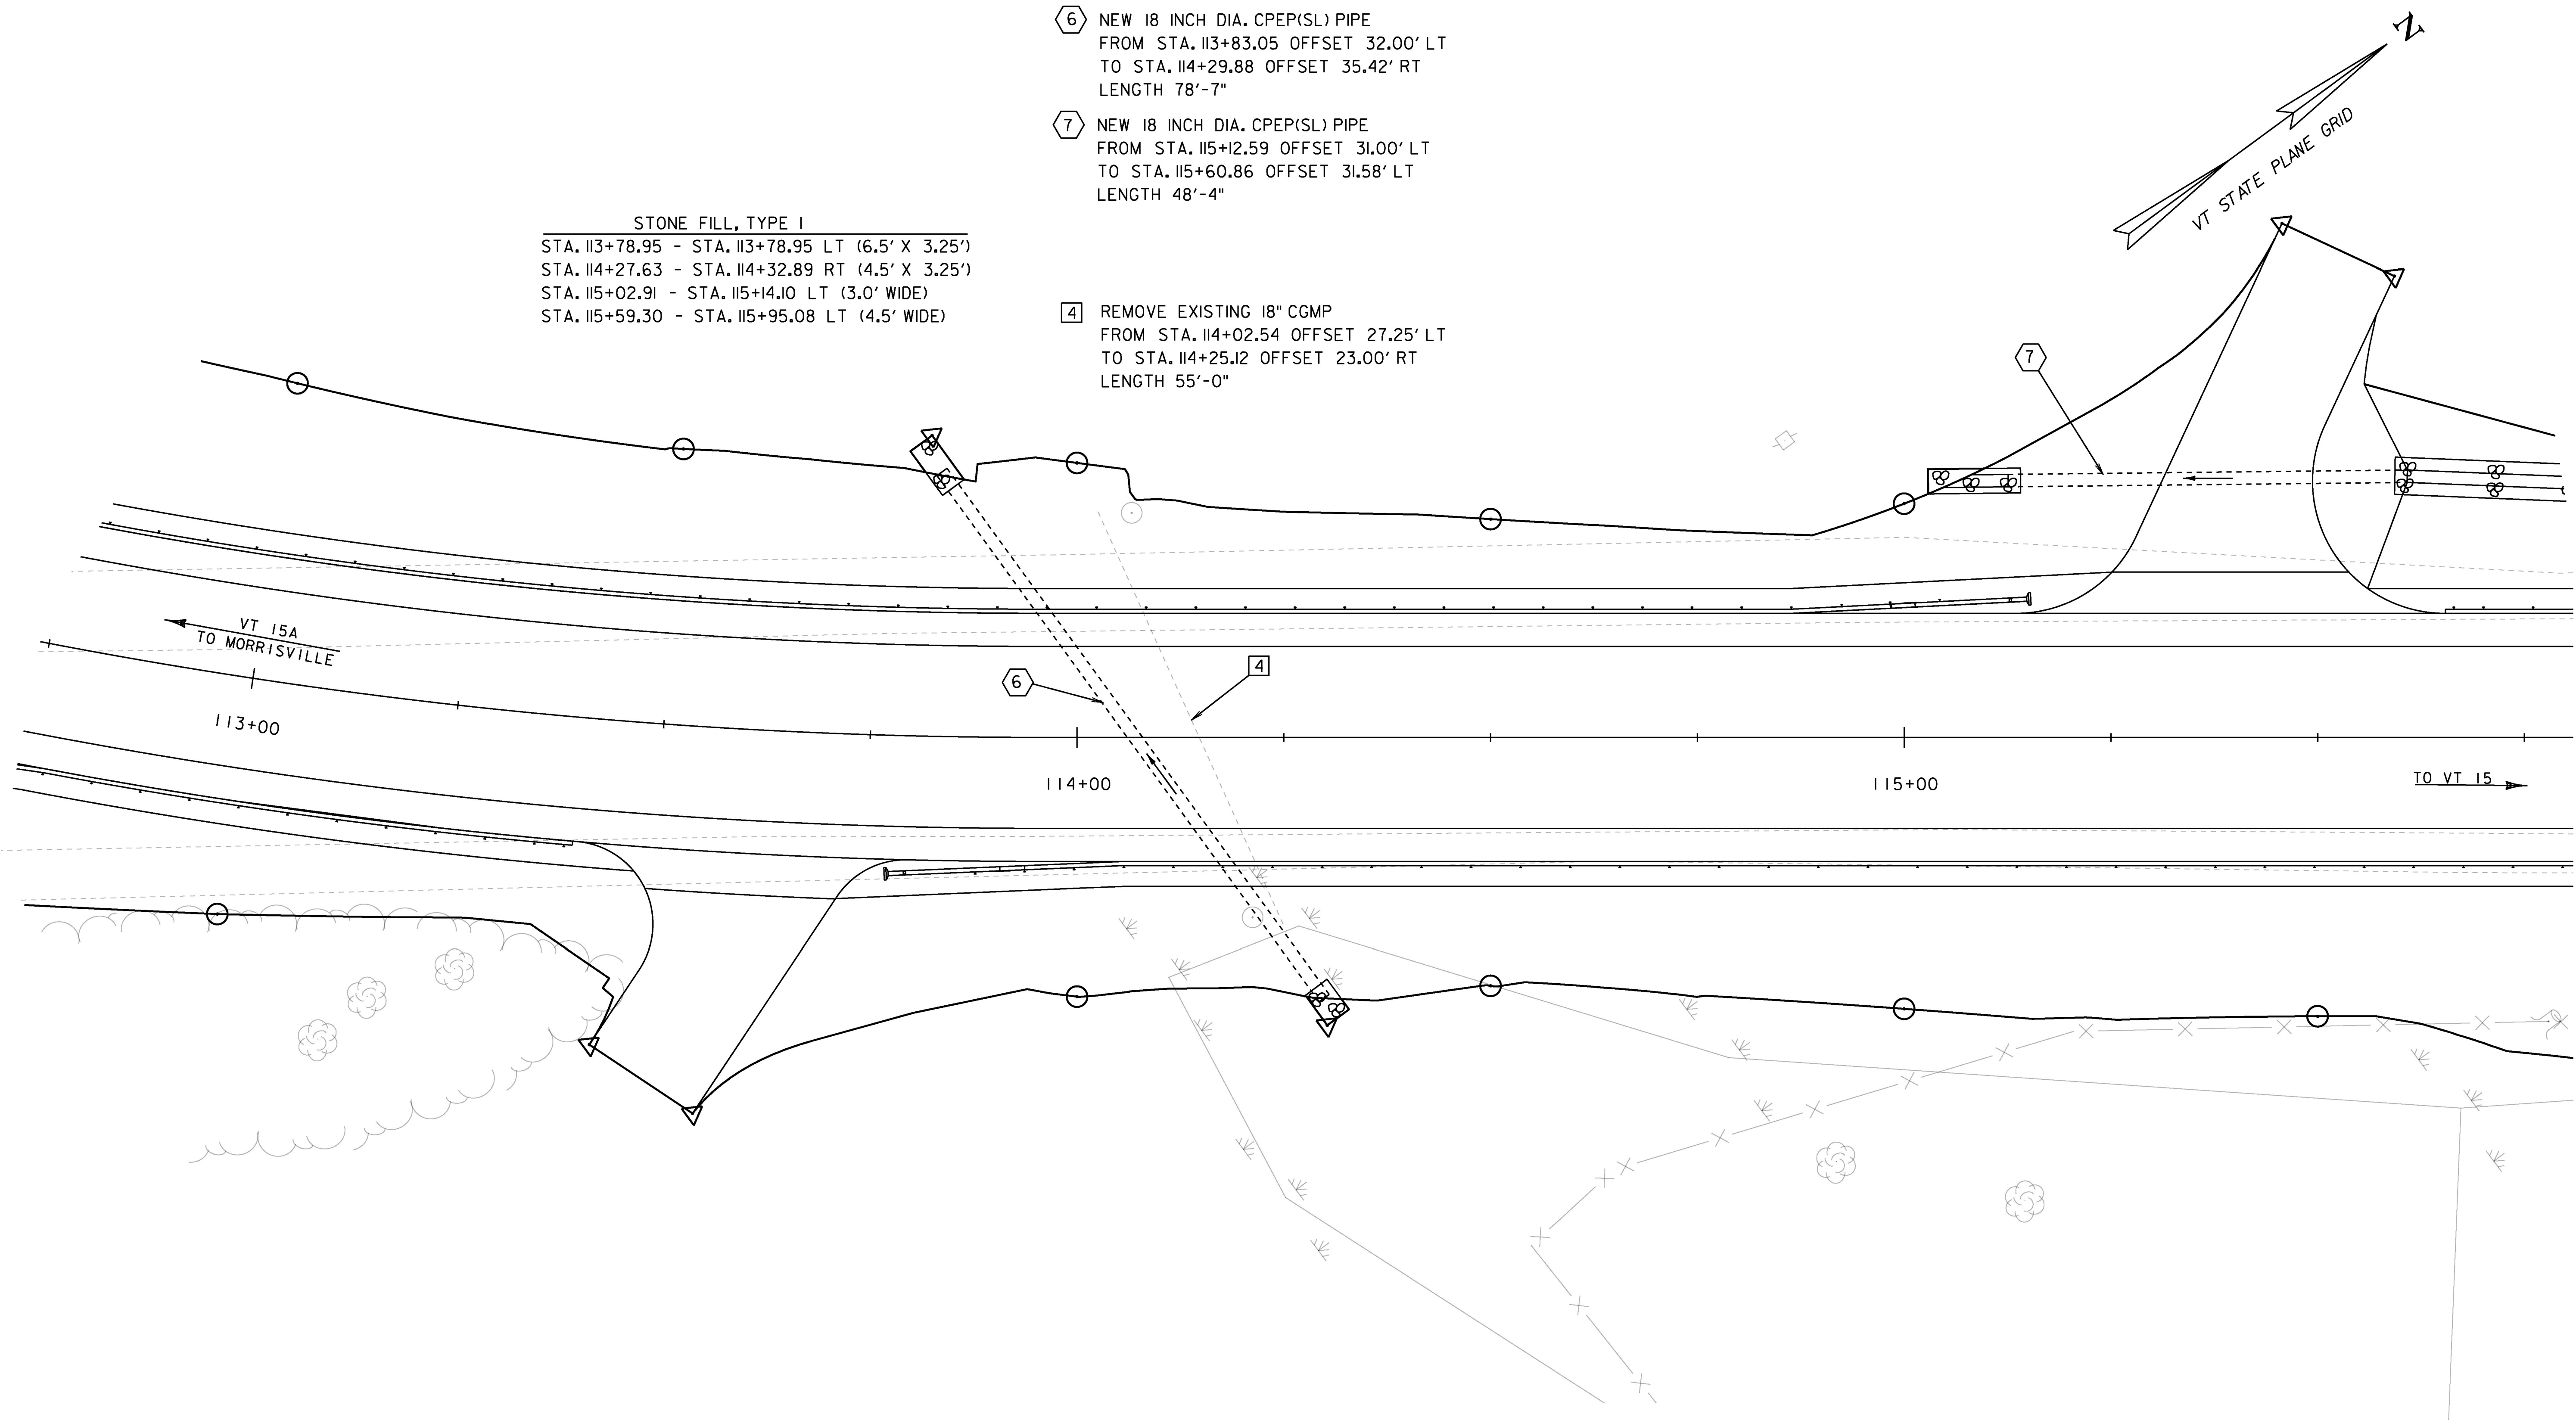

SCALE 1" = 10'-0"
 10 0 10

PROJECT NAME:	MORRISTOWN
PROJECT NUMBER:	BRS 0240(3)S/STP HES 030-2(28)
FILE NAME:	s78f329draInbdr.dgn
PROJECT LEADER:	C. CARLSON
DESIGNED BY:	C. BURRALL
VT 15A DRAINAGE LAYOUT SHEET 2	
PLOT DATE:	12-APR-2017
DRAWN BY:	G. ROKES
CHECKED BY:	J. LACROIX
SHEET	47 OF 175