



SEE CONTRACTORS EPSC PLAN

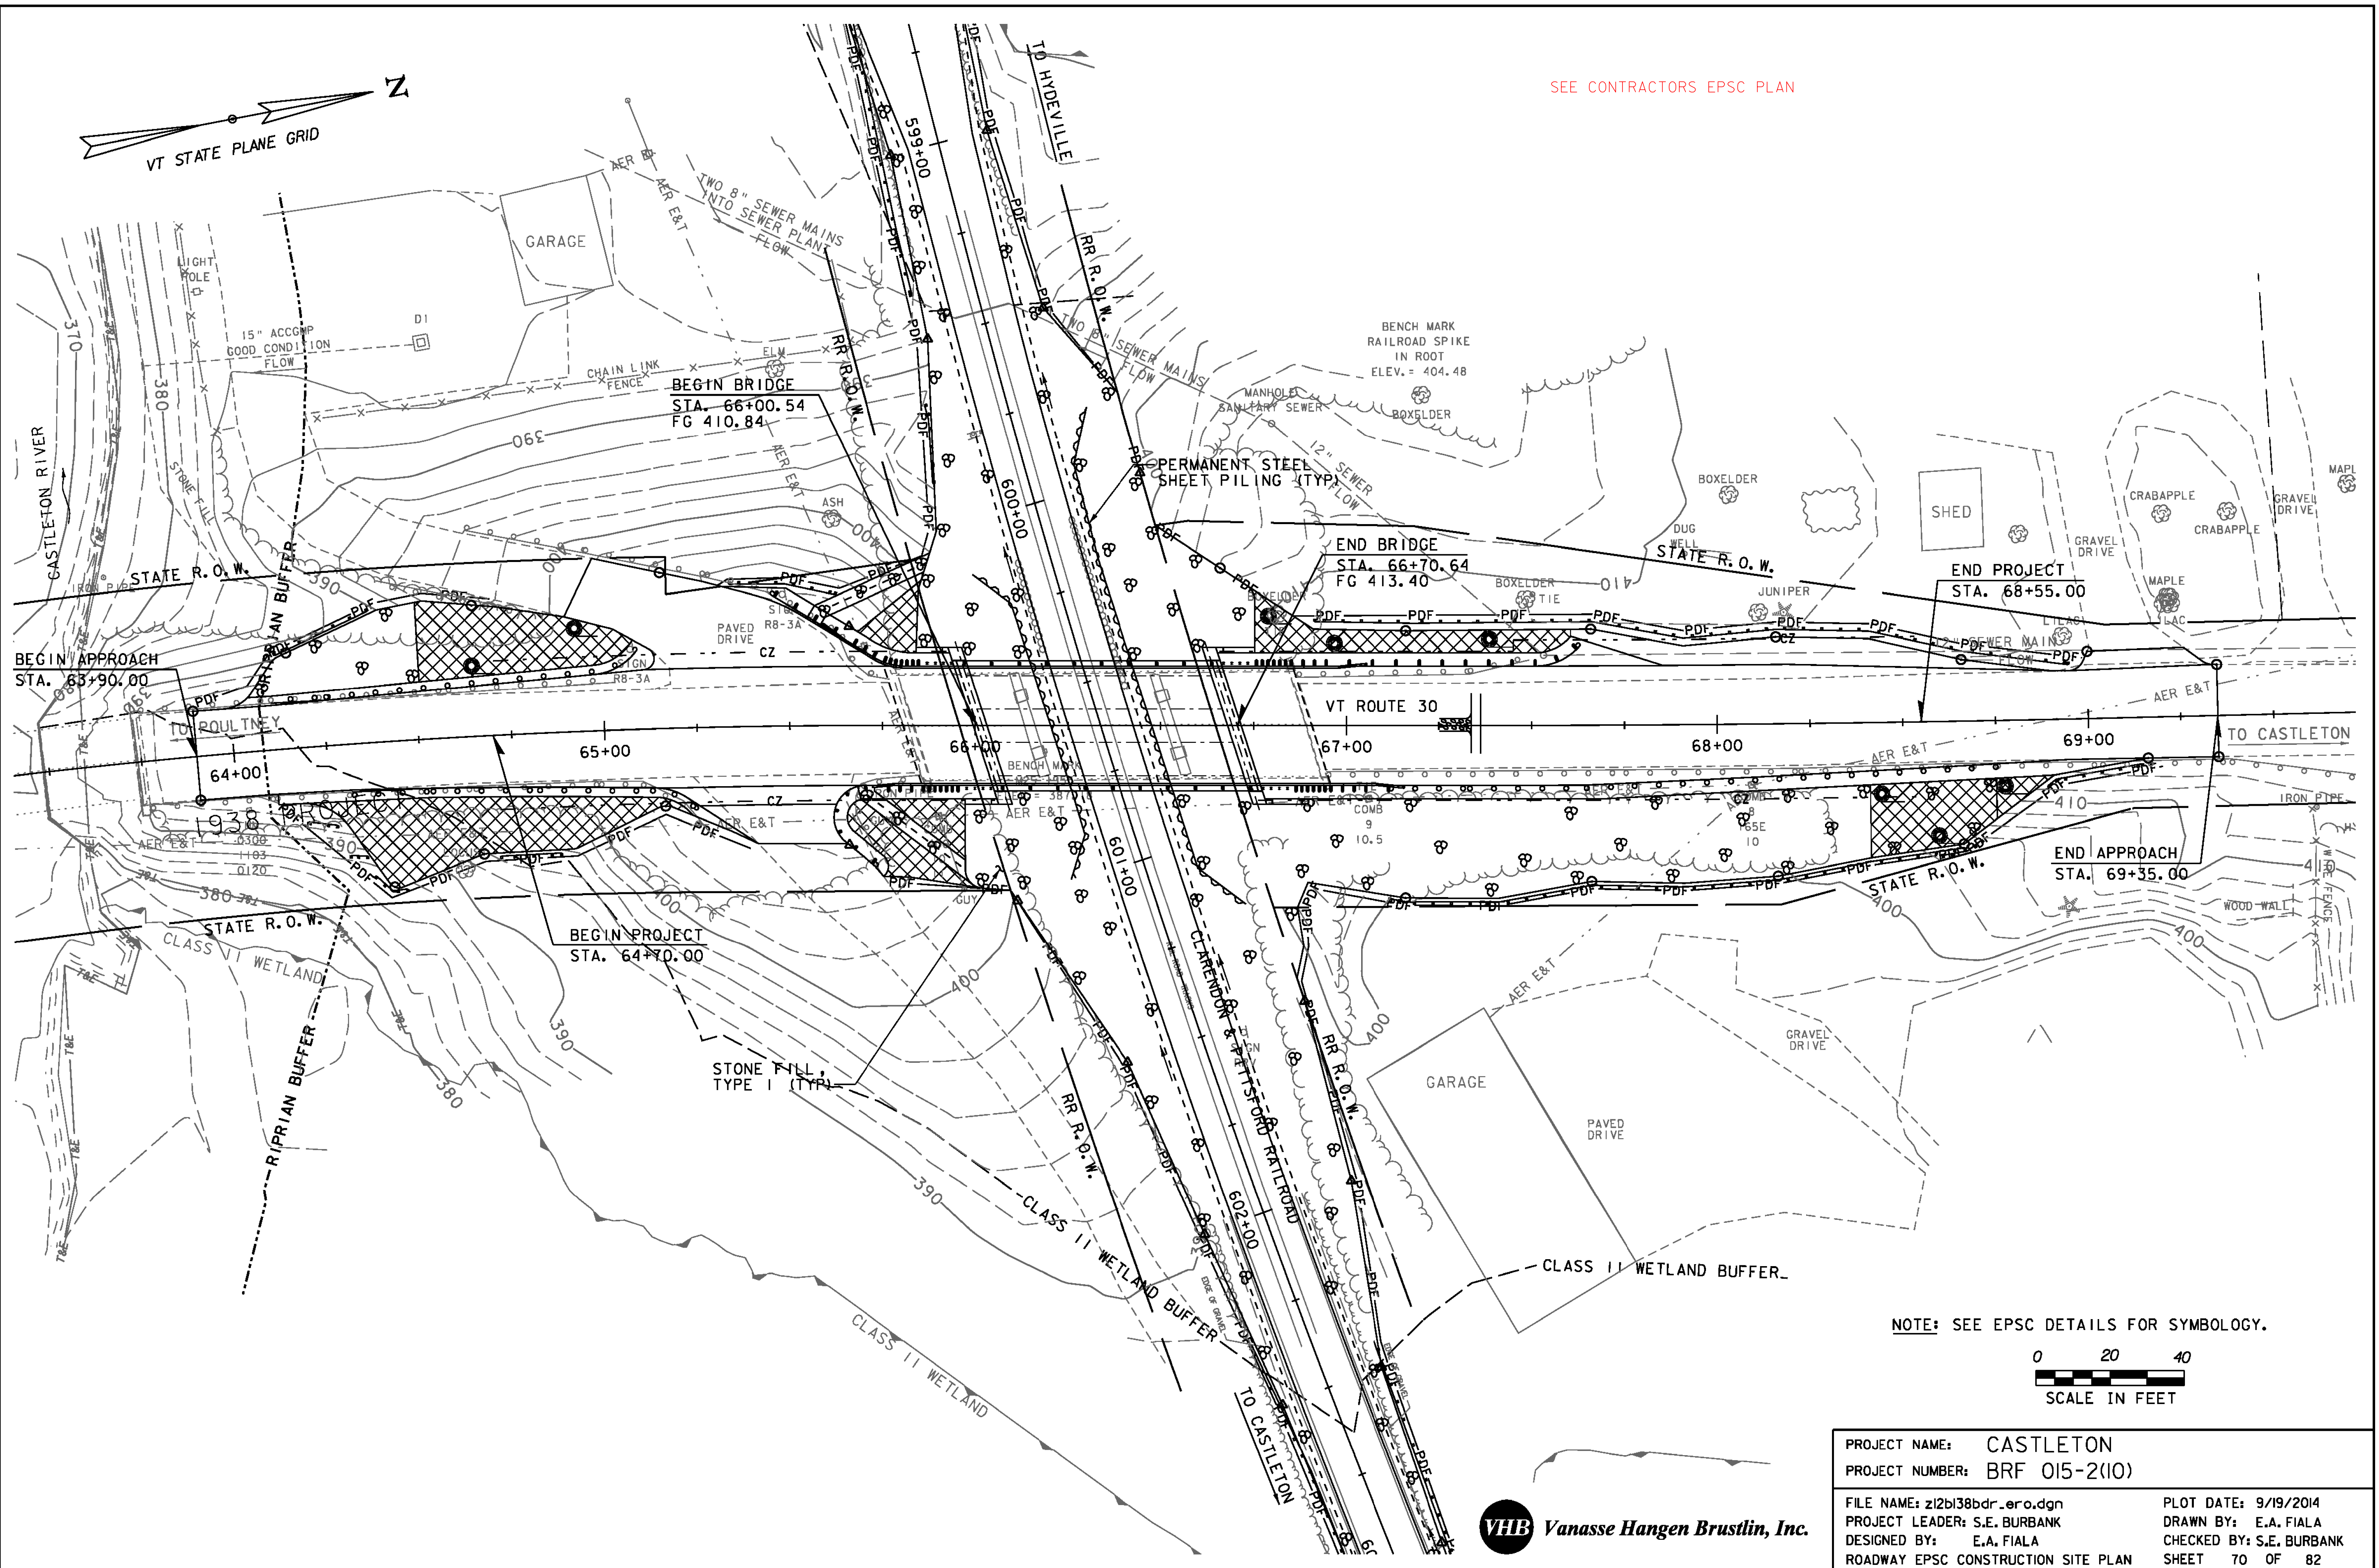

NOTE: SEE EPSC DETAILS FOR SYMBOLOLOGY.

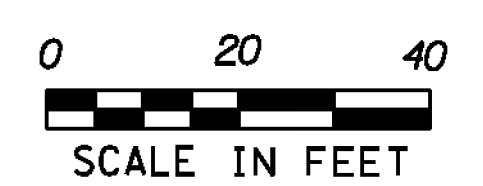

PROJECT NAME:	CASTLETON	FILE NAME:	z12b138bdr_ero.dgn	PLOT DATE:	9/19/2014
PROJECT NUMBER:	BRF 015-2(10)	PROJECT LEADER:	S.E. BURBANK	DRAWN BY:	E.A. FIALA
		DESIGNED BY:	E.A. FIALA	CHECKED BY:	S.E. BURBANK
		ROADWAY EPSC CONSTRUCTION SITE PLAN		SHEET	70 OF 82

