

SPECIAL PROVISION (ORNAMENTAL STREET LIGHT)

STA 115+17 RT
STA 115+83 RT
STA 115+83 LT
STA 116+30 LT
STA 116+56 RT
STA 116+83 LT (NO HOUSE SIDE SHIELD)

ELECTRICAL CONDUIT (2") (PVC) - LIGHTING CIRCUIT


STA 115+17 - 115+83 RT
STA 115+83 - 116+56 RT
STA 115+83 - 116+30 LT
STA 116+30 - 116+83 LT
STA 116+56 - 116+90 RT
STA 116+83 - 116+90 LT

ELECTRICAL CONDUIT SLEEVE (6") (PVC)

STA 116+38 - 116+76 LT

PULL BOX, STANDARD

STA 115+17 RT
STA 115+83 RT
~~STA 115+83 LT~~
~~STA 116+30 LT~~
~~STA 116+56 RT~~
~~STA 116+83 LT~~

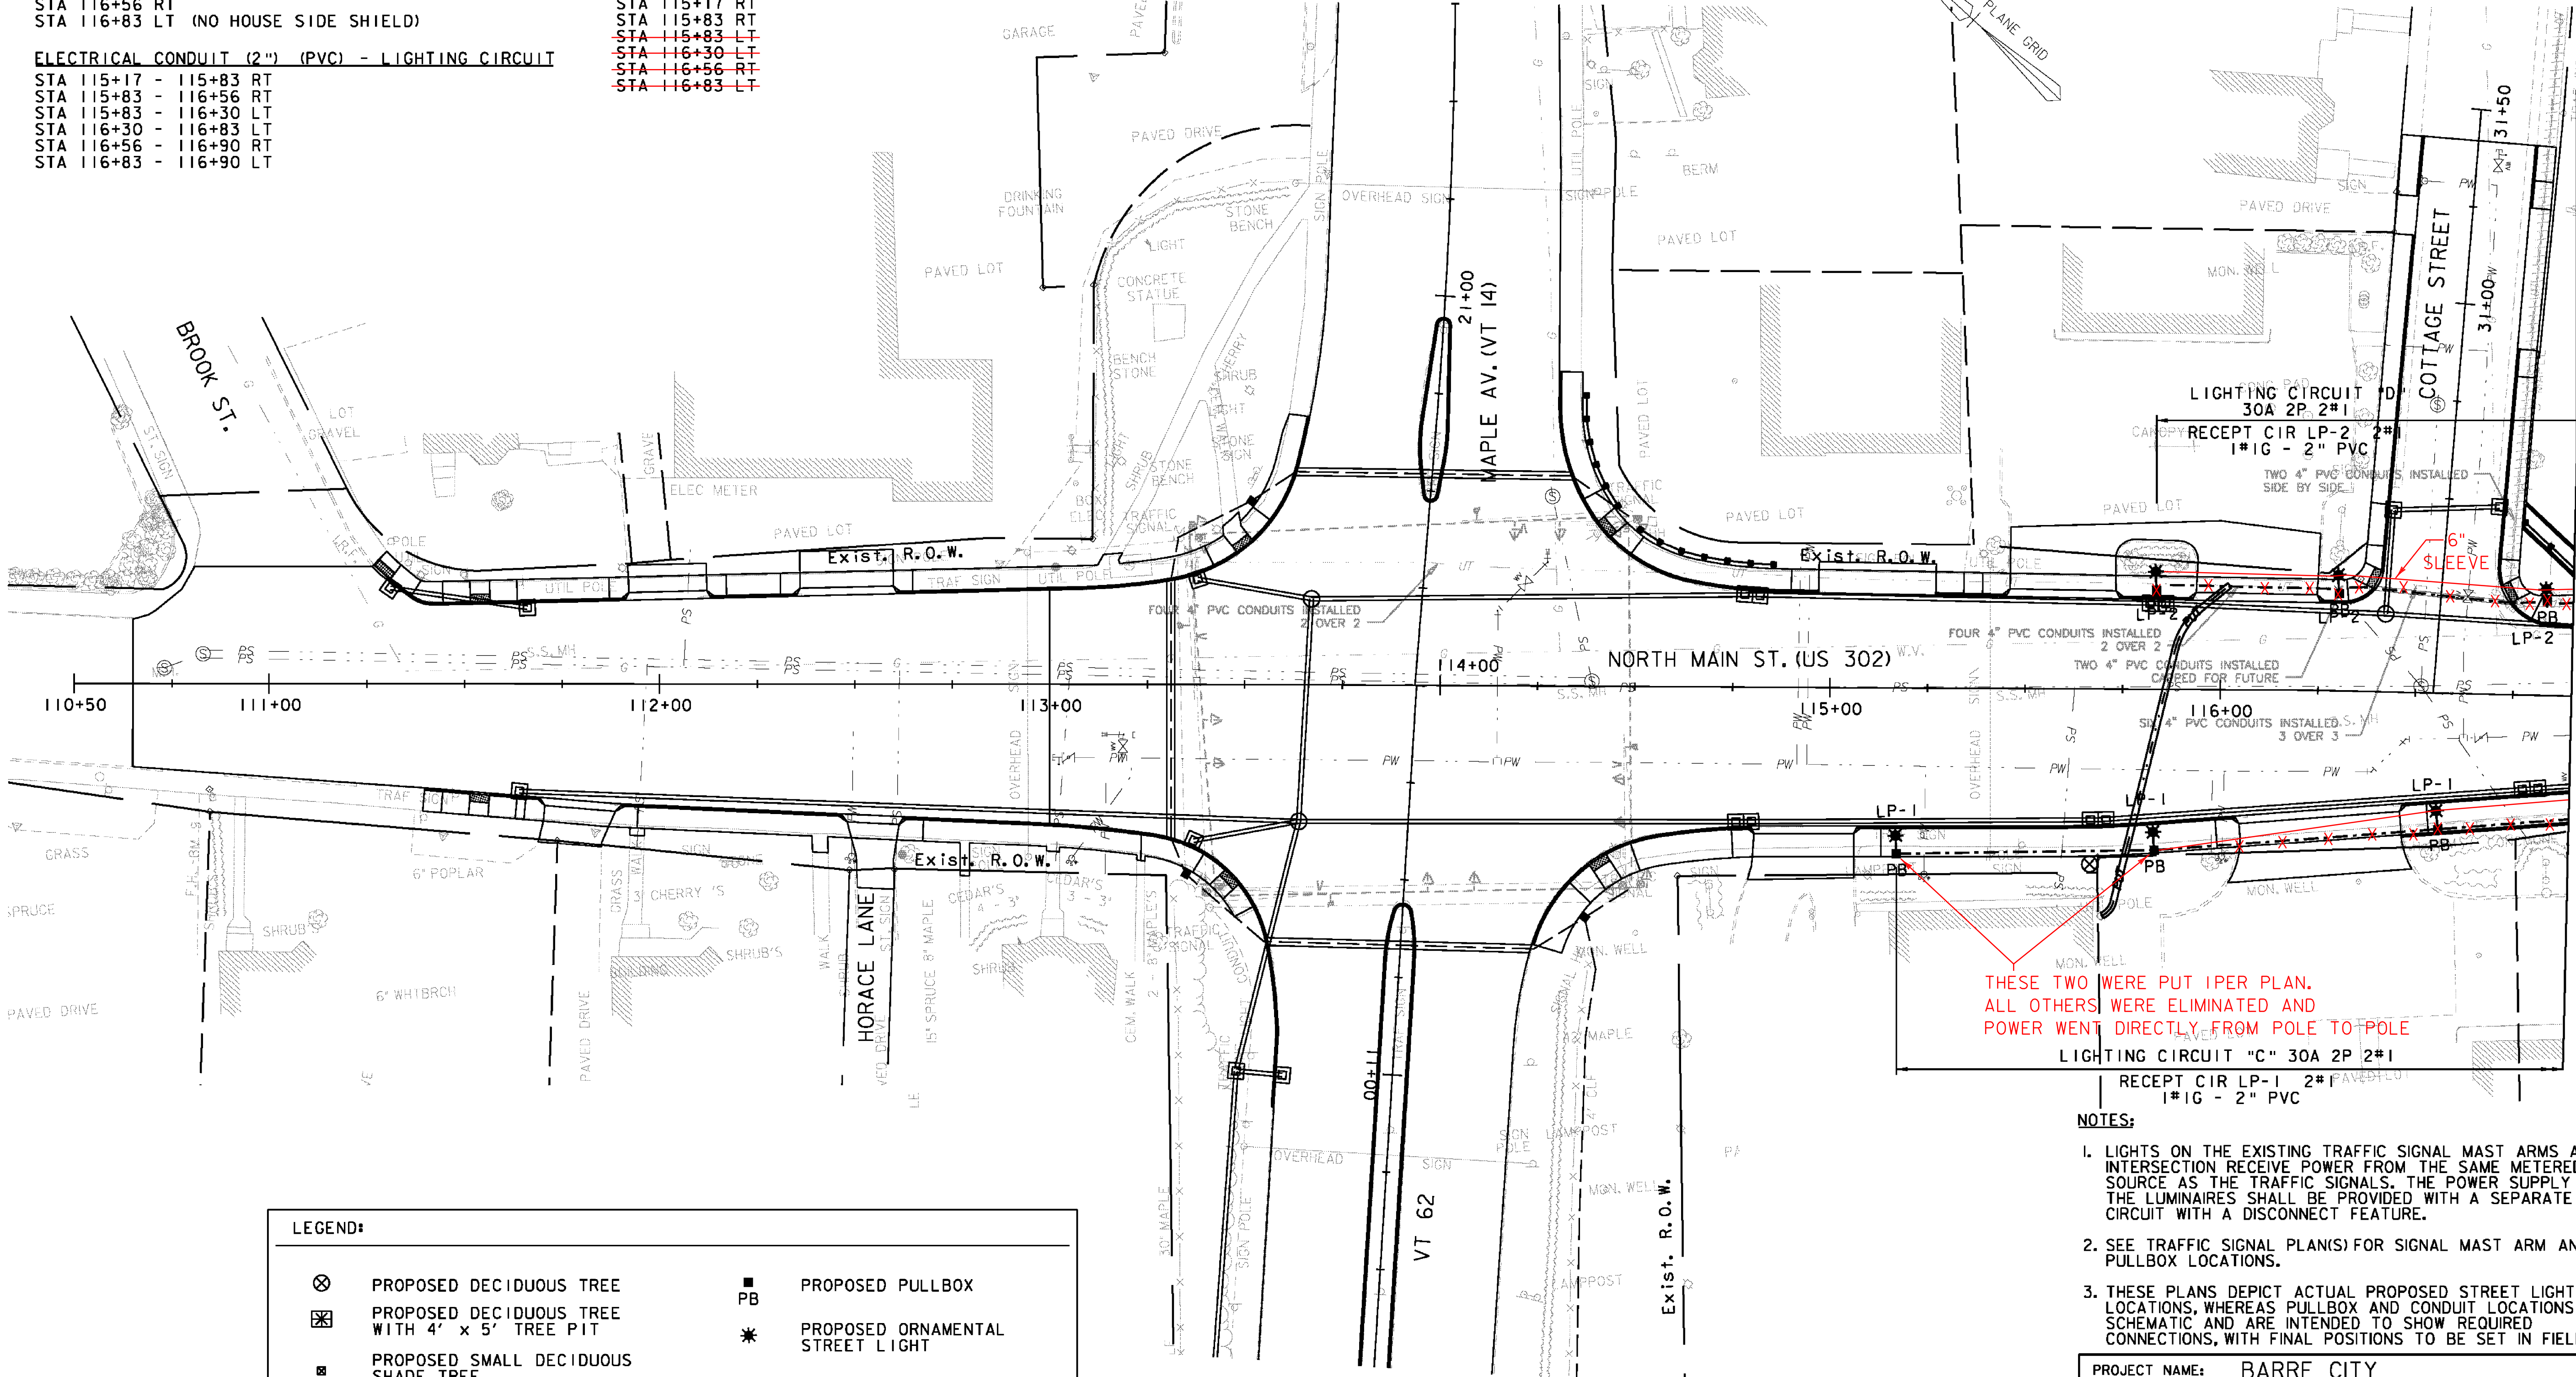

THESE TWO WERE PUT IPER PLAN.
ALL OTHERS WERE ELIMINATED AND
POWER WENT DIRECTLY FROM POLE TO POLE

NOTES:

1. LIGHTS ON THE EXISTING TRAFFIC SIGNAL MAST ARMS AT THE INTERSECTION RECEIVE POWER FROM THE SAME METERED SOURCE AS THE TRAFFIC SIGNALS. THE POWER SUPPLY FOR THE LUMINAIRES SHALL BE PROVIDED WITH A SEPARATE CIRCUIT WITH A DISCONNECT FEATURE.
2. SEE TRAFFIC SIGNAL PLAN(S) FOR SIGNAL MAST ARM AND PULLBOX LOCATIONS.
3. THESE PLANS DEPICT ACTUAL PROPOSED STREET LIGHT LOCATIONS, WHEREAS PULLBOX AND CONDUIT LOCATIONS ARE SCHEMATIC AND ARE INTENDED TO SHOW REQUIRED CONNECTIONS, WITH FINAL POSITIONS TO BE SET IN FIELD.

LEGEND:

- | | | | |
|-----|---|---|--------------------------------------|
| ⊗ | PROPOSED DECIDUOUS TREE | ■ | PROPOSED PULLBOX |
| ⊗ | PROPOSED DECIDUOUS TREE WITH 4' x 5' TREE PIT | * | PROPOSED ORNAMENTAL STREET LIGHT |
| ■ | PROPOSED SMALL DECIDUOUS SHADE TREE | ● | PROPOSED SIGNAL POLE WITH LUMINAIRE |
| --- | PROPOSED LIGHTING CONDUIT | — | PROPOSED FAIRPOINT DUCT BANK CONDUIT |
| --- | PROPOSED LIGHTING CONDUIT & SLEEVE | | |



VHB Vanasse Hangen Brustlin, Inc.

PROJECT NAME:	BARRE CITY	PLOT DATE:	3/23/2011
PROJECT NUMBER:	FEGC F 026-(K34) C/2	DRAWN BY:	D. PECK
FILE NAME:	z85b010bdr_11_C2	DESIGNED BY:	D. PECK
PROJECT LEADER:	G. BAKOS	CHECKED BY:	
STREET LIGHTING PLAN "I"		SHEET 79	OF 339