


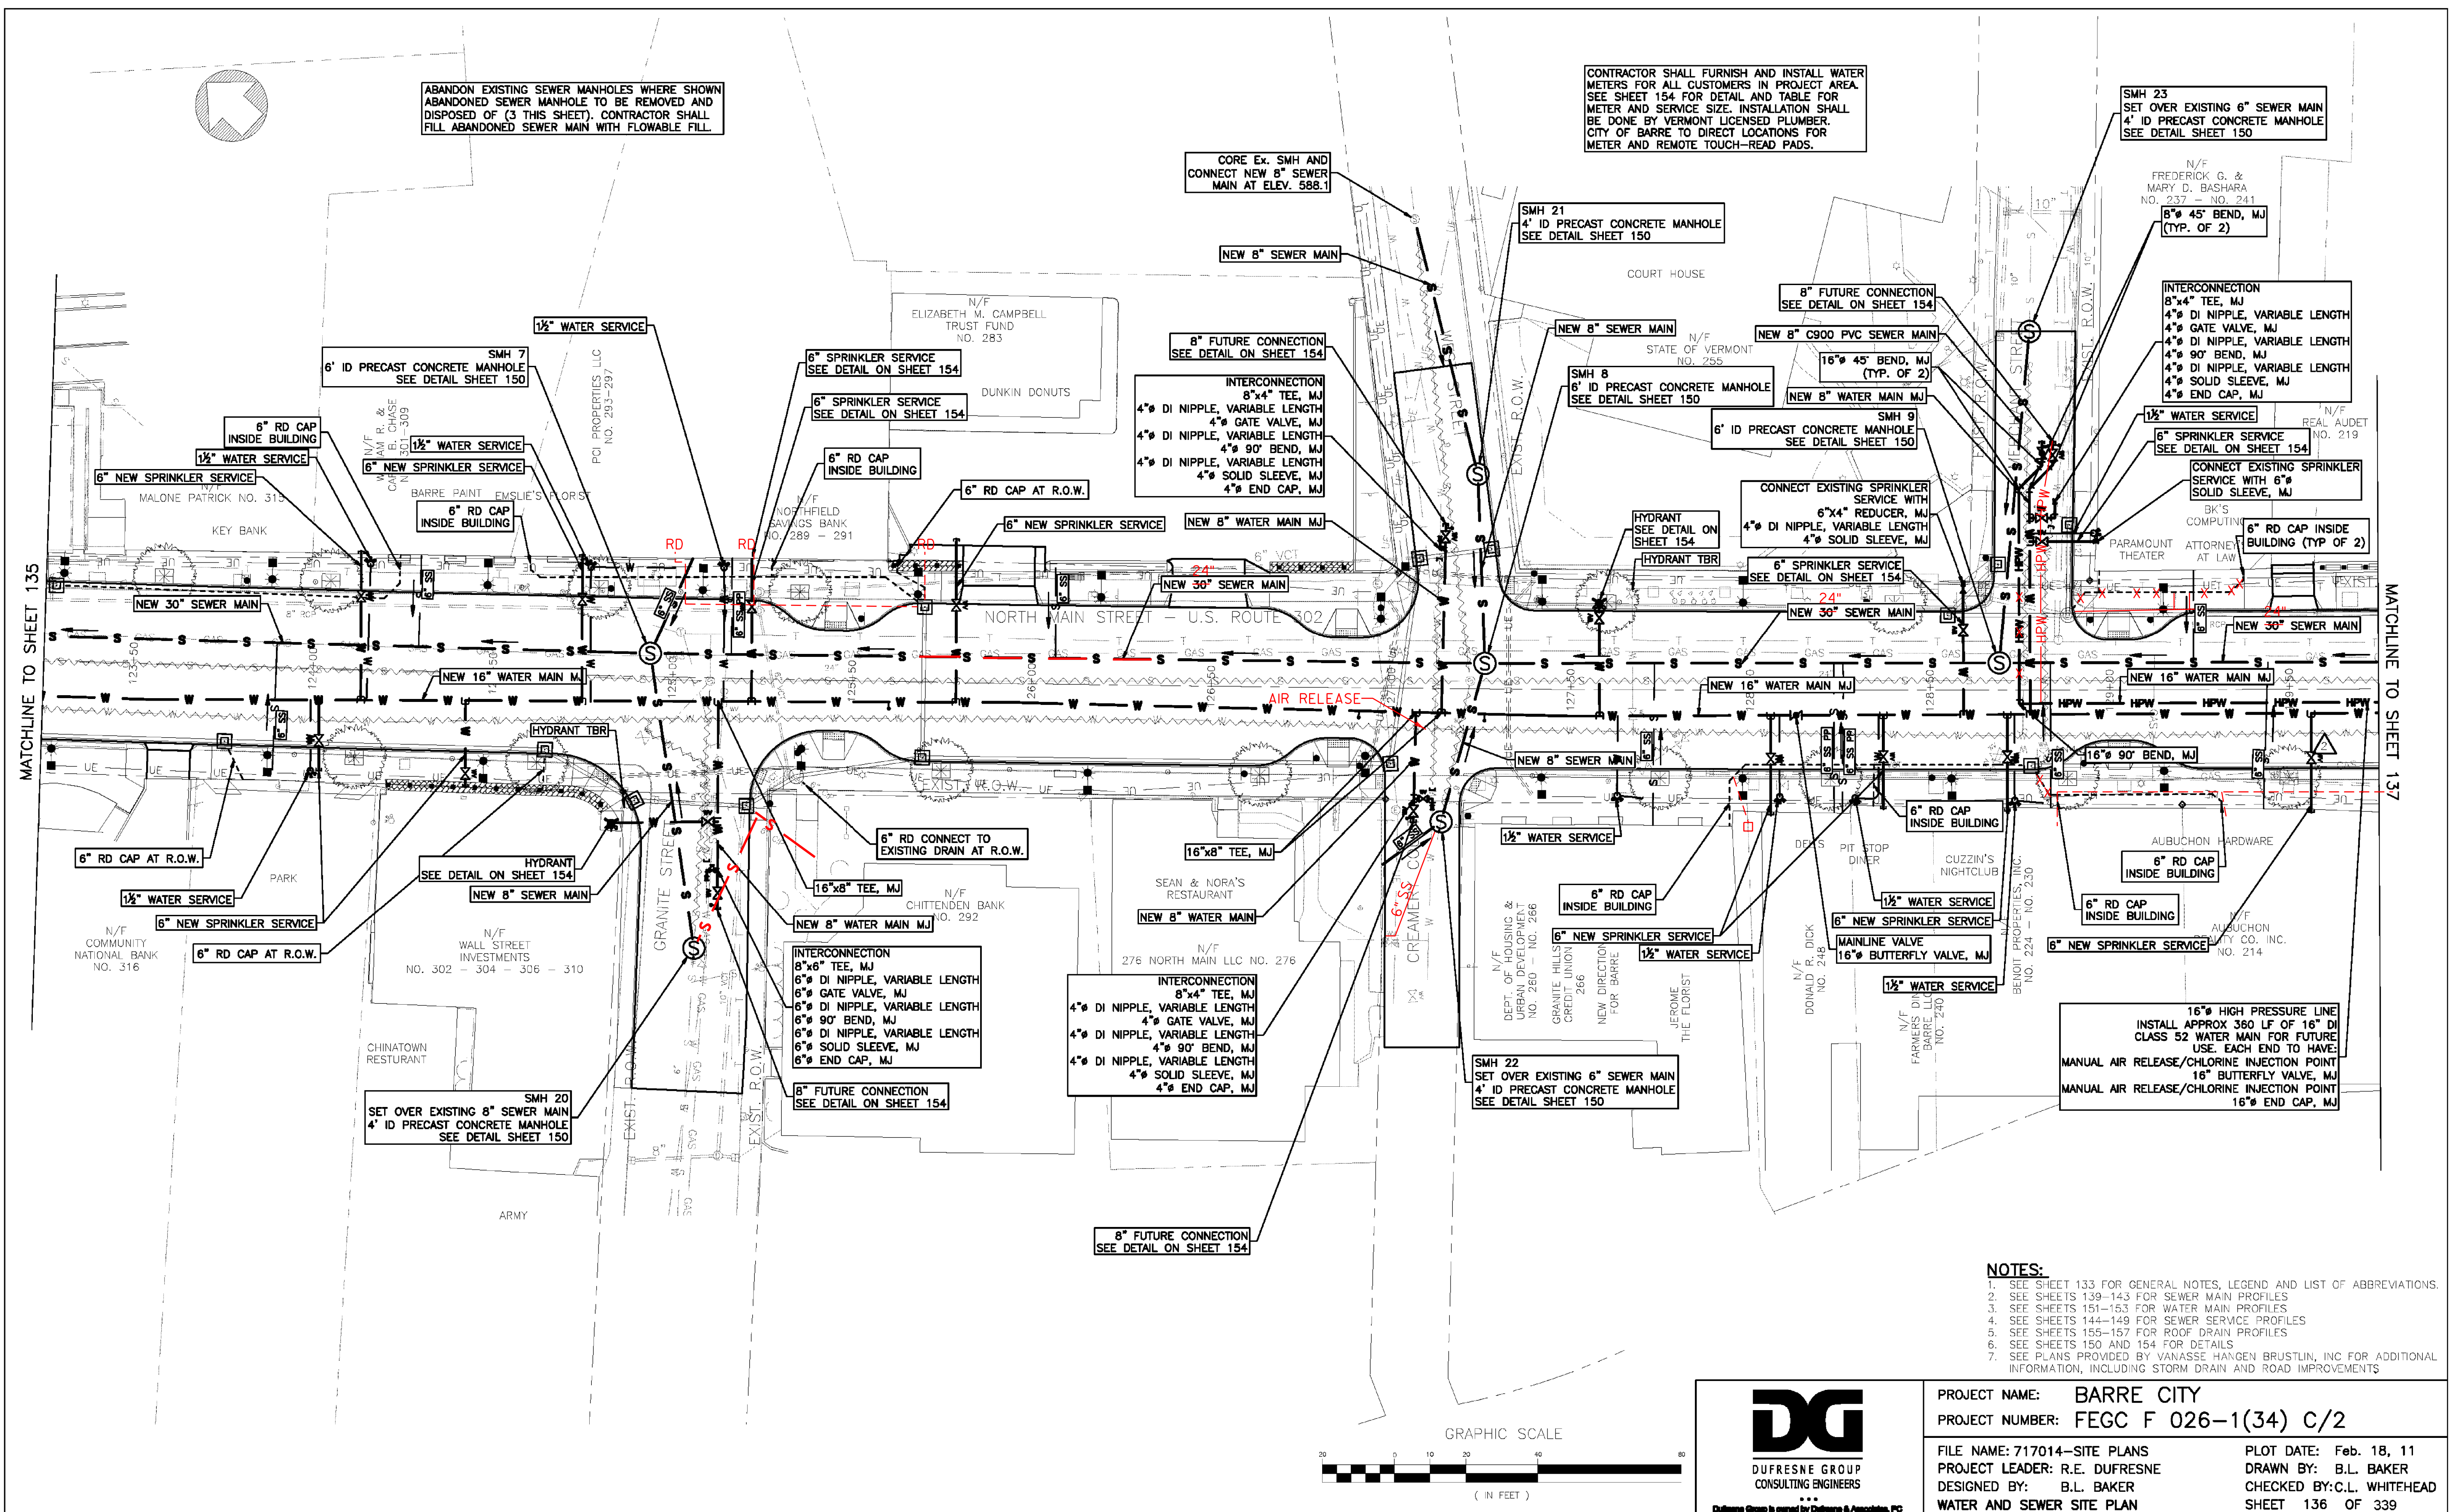

NOTES:

1. SEE SHEET 133 FOR GENERAL NOTES, LEGEND AND LIST OF ABBREVIATIONS.
2. SEE SHEETS 139-143 FOR SEWER MAIN PROFILES
3. SEE SHEETS 151-153 FOR WATER MAIN PROFILES
4. SEE SHEETS 144-149 FOR SEWER SERVICE PROFILES
5. SEE SHEETS 155-157 FOR ROOF DRAIN PROFILES
6. SEE SHEETS 150 AND 154 FOR DETS.
7. SEE PLANS PROVIDED BY VANASSE HANGEN BRUSTLIN, INC FOR ADDITIONAL INFORMATION, INCLUDING STORM DRAIN AND ROAD IMPROVEMENTS



DUFRESNE GROUP
CONSULTING ENGINEERS
...
The Group is owned by Dufresne & Associates, PC

PROJECT NAME:	BARRE CITY
PROJECT NUMBER:	FEGC F 026-1(34) C/2

FILE NAME: 717014-SITE PLANS
PROJECT LEADER: R.E. DUFRESNE
DESIGNED BY: B.L. BAKER
WATER AND SEWER SITE PLAN

PLOT DATE: Feb. 18, 11
DRAWN BY: B.L. BAKER
CHECKED BY: C.L. WHITEHEAD
SHEET 136 OF 339