


MATCH TO STA. 129+75 (SHEET 81)

MATCH TO STA. 136+00 (SHEET 83)

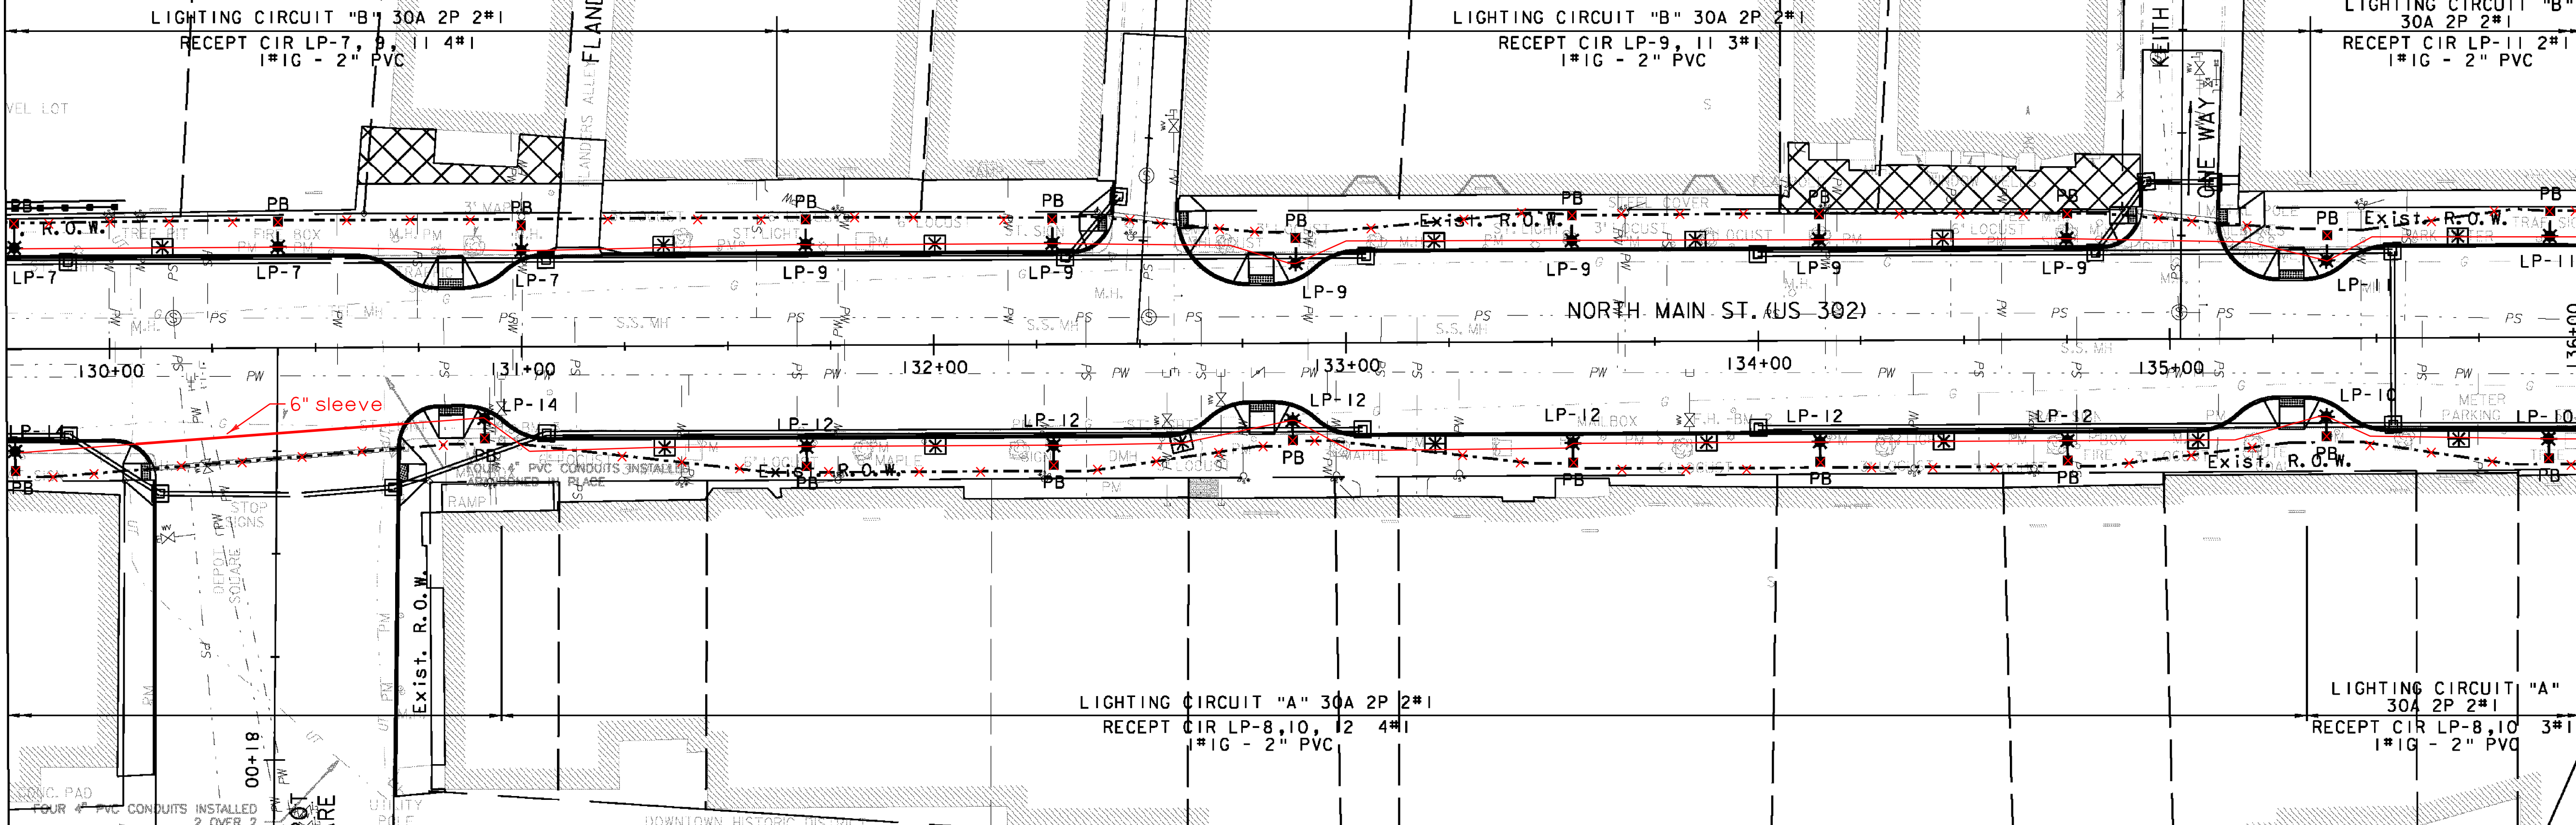

**SPECIAL PROVISION
ORNAMENTAL
STREET LIGHT**

STA 129+77 RT
STA 129+77 LT
STA 130+41 LT
STA 130+91 RT
STA 131+00 RT
STA 131+69 RT
STA 131+69 LT
STA 132+29 RT
STA 132+29 LT
STA 132+87 RT
STA 132+87 LT
STA 132+88 LT
STA 133+55 RT
STA 133+55 LT
STA 134+15 RT
STA 134+15 LT
STA 134+75 RT
STA 134+75 LT
STA 135+38 RT
STA 135+38 LT
STA 135+92 RT
STA 135+92 LT

~~PULL BOX, STANDARD~~

STA 129+77 RT
STA 129+77 LT
STA 130+41 LT
STA 130+91 RT
STA 131+00 RT
STA 131+69 RT
STA 131+69 LT
STA 132+29 RT
STA 132+29 LT
STA 132+87 RT
STA 132+87 LT
STA 132+88 LT

~~PULL BOX, STANDARD
(CONT.)~~

STA 133+55 RT
STA 133+55 LT
STA 134+15 RT
STA 134+15 LT
STA 134+75 RT
STA 134+75 LT
STA 135+38 RT
STA 135+38 LT
STA 135+92 RT
STA 135+92 LT

ELECTRICAL CONDUIT SLEEVE (6") (PVC)

STA 130+10 - 130+71 RT
STA 132+43 - 132+60 LT
STA 134+92 - 135+13 LT

**ELECTRICAL CONDUIT (2") (PVC)
LIGHTING CIRCUIT**

STA 129+75 - 129+77 LT
STA 129+75 - 129+77 RT
STA 129+77 - 130+91 RT
STA 129+77 - 130+41 LT
STA 130+41 - 131+00 LT
STA 130+91 - 131+69 RT
STA 131+00 - 131+69 LT
STA 131+69 - 132+29 RT
STA 131+69 - 132+29 LT
STA 132+29 - 132+88 LT
STA 132+29 - 132+87 RT
STA 132+87 - 133+55 RT
STA 132+88 - 133+55 LT
STA 133+55 - 134+15 LT
STA 133+55 - 134+15 RT
STA 134+15 - 134+75 RT
STA 134+15 - 134+75 LT
STA 134+75 - 135+38 RT
STA 134+75 - 135+38 LT
STA 135+38 - 135+92 RT
STA 135+38 - 135+92 LT
STA 135+92 - 136+00 LT
STA 135+92 - 136+00 RT

NOTES:

1. THESE PLANS DEPICT ACTUAL PROPOSED STREET LIGHT LOCATIONS, WHEREAS PULLBOX AND CONDUIT LOCATIONS ARE SCHEMATIC AND ARE INTENDED TO SHOW REQUIRED CONNECTIONS, WITH FINAL POSITIONS TO BE SET IN FIELD.

LEGEND:

	PROPOSED DECIDUOUS TREE		PROPOSED PULLBOX
	PROPOSED DECIDUOUS TREE WITH 4' x 5' TREE PIT		PROPOSED ORNAMENTAL STREET LIGHT
	PROPOSED SMALL DECIDUOUS SHADE TREE		PROPOSED SIGNAL POLE WITH LUMINAIRE
	PROPOSED LIGHTING CONDUIT		PROPOSED FAIRPOINT DUCT BANK CONDUIT
	PROPOSED LIGHTING CONDUIT & SLEEVE		



VHB Vanasse Hangen Brustlin, Inc.

PROJECT NAME: BARRE CITY	PLOT DATE: 3/9/2011
PROJECT NUMBER: FEGC F 026-(134) C/2	DRAWN BY: D. PECK
FILE NAME: z85b010bdr_if_c2	CHECKED BY:
PROJECT LEADER: G. BAKOS	SHEET 82 OF 339
DESIGNED BY: D. PECK	
STREET LIGHTING PLAN #4	