



ABANDON EXISTING SEWER MANHOLES WHERE SHOWN
 ABANDONED SEWER MANHOLE TO BE REMOVED AND
 DISPOSED OF (5 THIS SHEET). CONTRACTOR SHALL
 FILL ABANDONED SEWER MAIN WITH FLOWABLE FILL.

CONTRACTOR SHALL FURNISH AND INSTALL WATER
 METERS FOR ALL CUSTOMERS IN PROJECT AREA.
 SEE SHEET 154 FOR DETAIL AND TABLE FOR
 METER AND SERVICE SIZE. INSTALLATION SHALL
 BE DONE BY VERMONT LICENSED PLUMBER.
 CITY OF BARRE TO DIRECT LOCATIONS FOR
 METER AND REMOTE TOUCH-READ PADS.

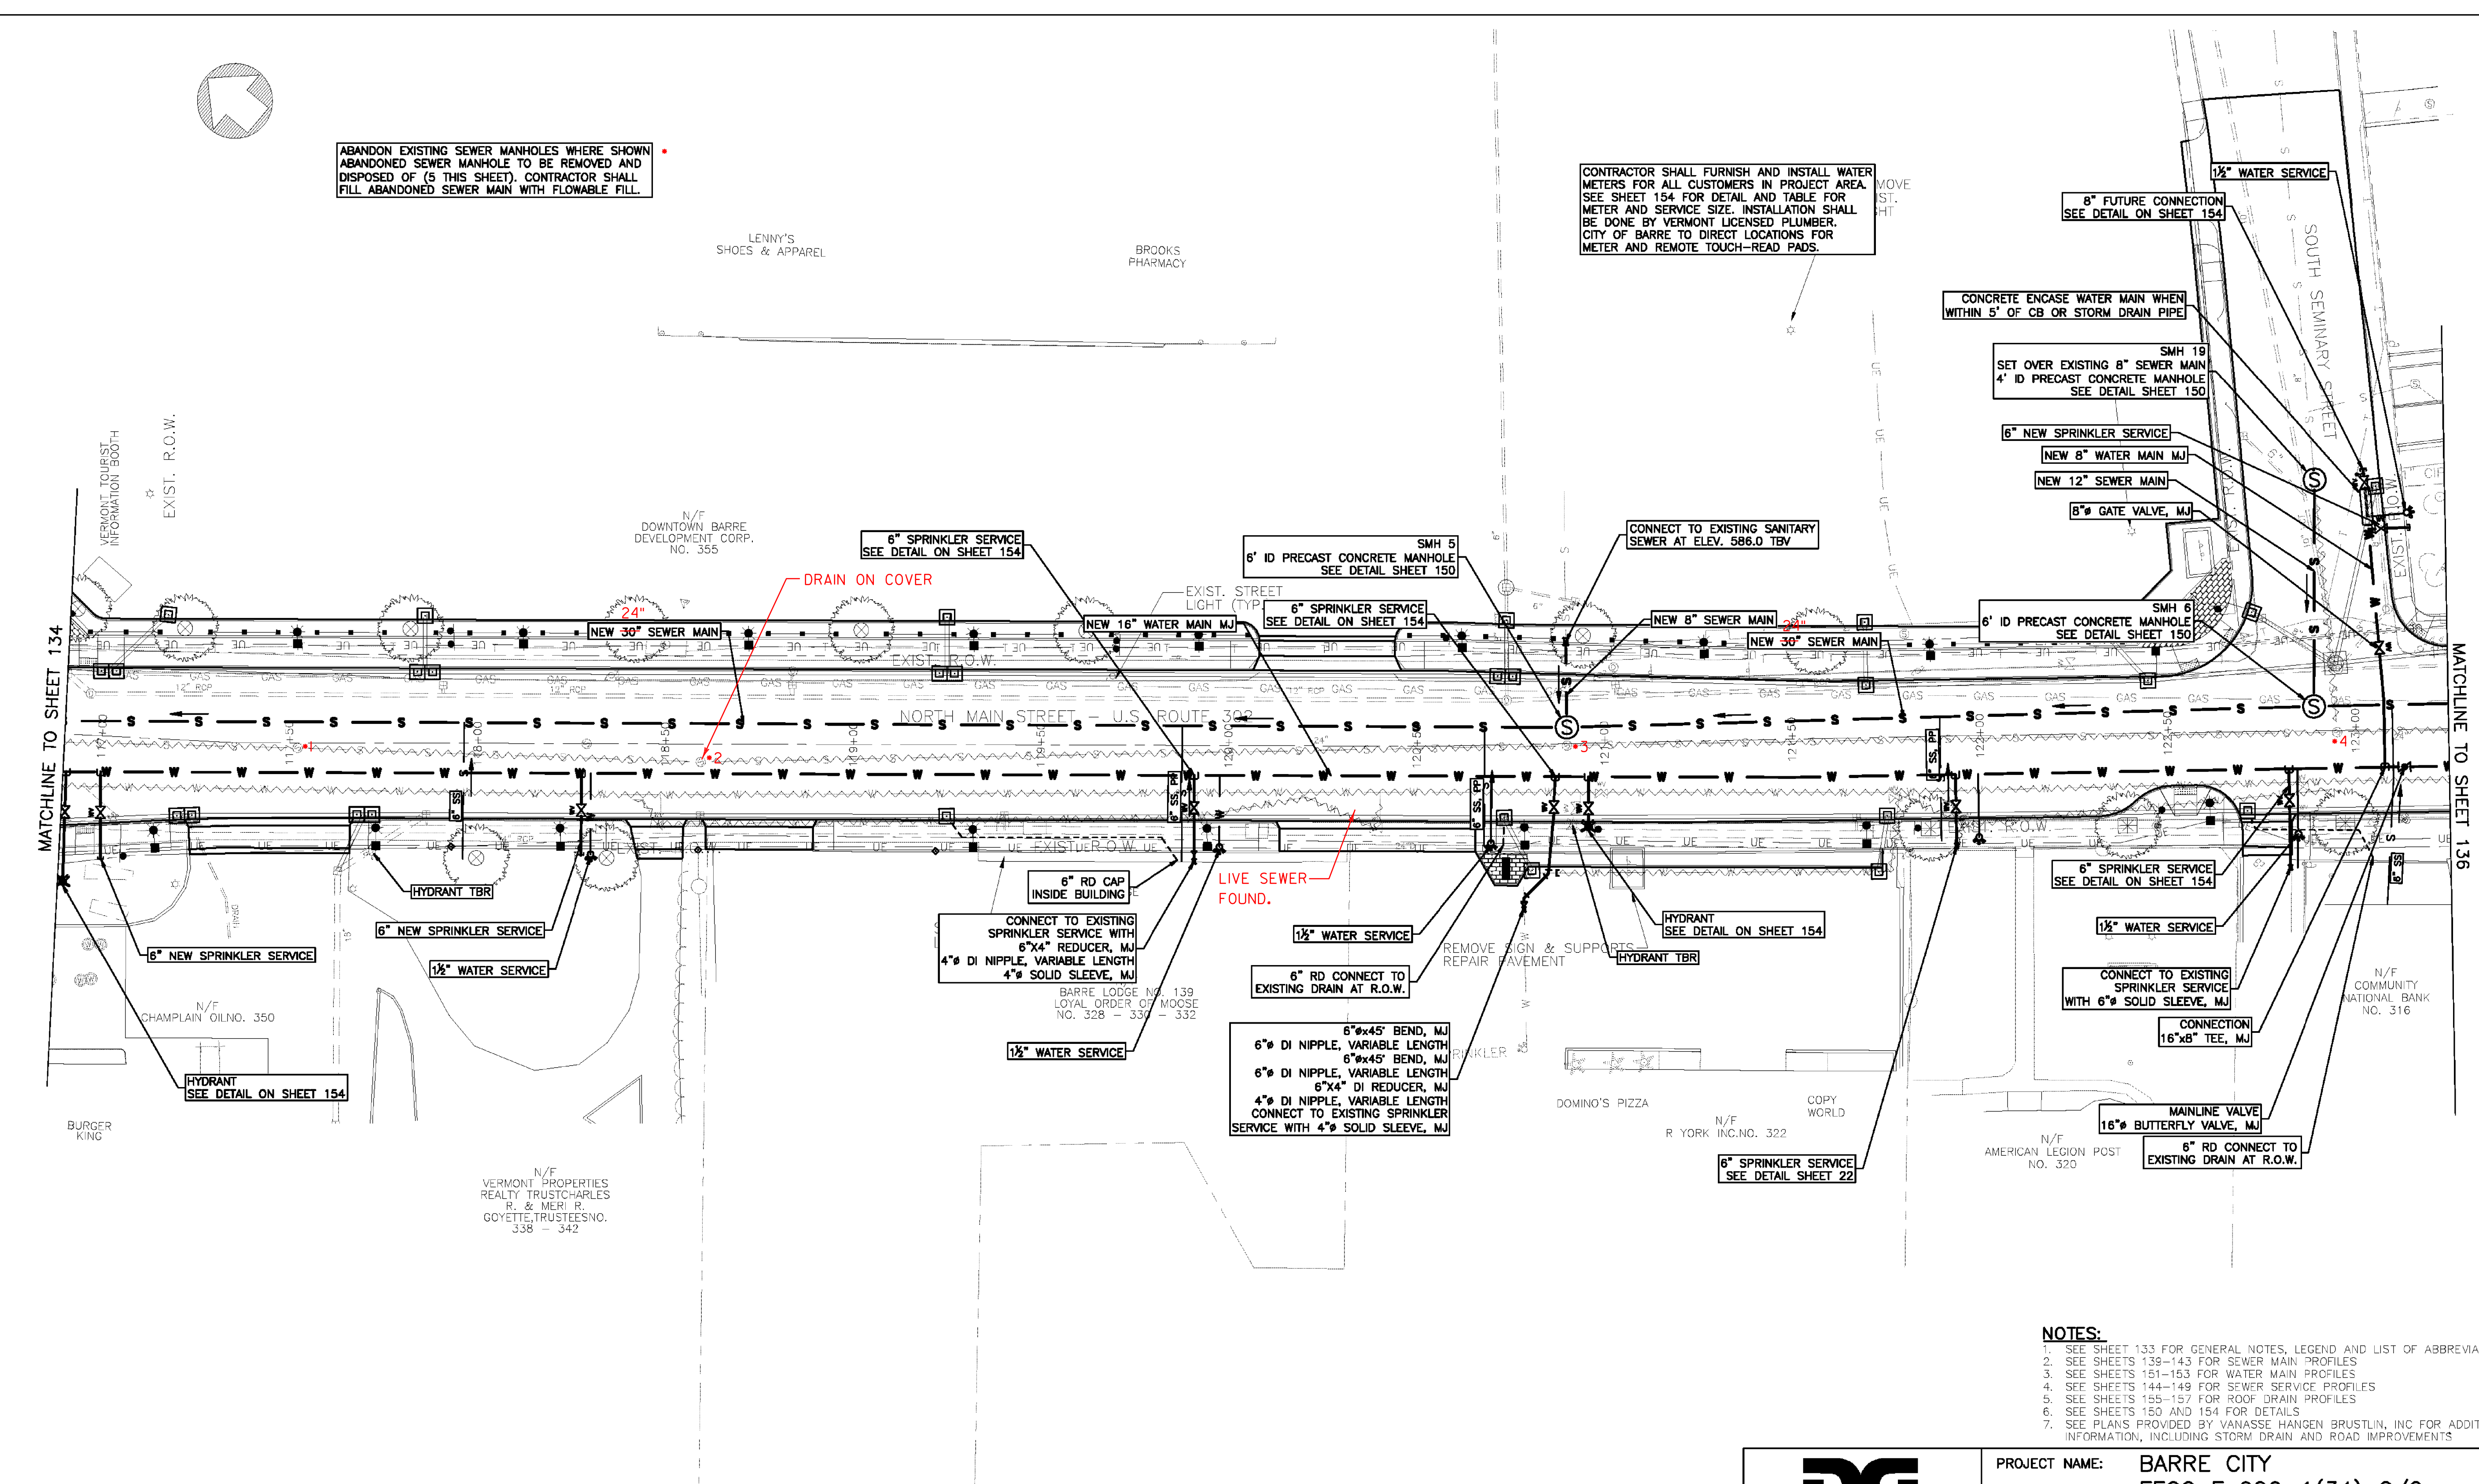

- NOTES:**
1. SEE SHEET 133 FOR GENERAL NOTES, LEGEND AND LIST OF ABBREVIATIONS.
 2. SEE SHEETS 139-143 FOR SEWER MAIN PROFILES
 3. SEE SHEETS 151-153 FOR WATER MAIN PROFILES
 4. SEE SHEETS 144-149 FOR SEWER SERVICE PROFILES
 5. SEE SHEETS 155-157 FOR ROOF DRAIN PROFILES
 6. SEE SHEETS 150 AND 154 FOR DETAILS
 7. SEE PLANS PROVIDED BY VANASSE HANGEN BRUSTLIN, INC FOR ADDITIONAL INFORMATION, INCLUDING STORM DRAIN AND ROAD IMPROVEMENTS

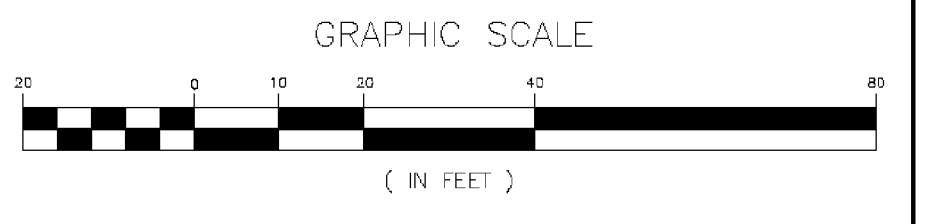

PROJECT NAME: BARRE CITY
 PROJECT NUMBER: FEGC F 026-1(34) C/2
 FILE NAME: 717014-SITE PLANS
 PROJECT LEADER: R.E. DUFRESNE
 DESIGNED BY: B.L. BAKER
 WATER AND SEWER SITE PLAN

PLOT DATE: Feb. 18, 11
 DRAWN BY: B.L. BAKER
 CHECKED BY: C.L. WHITHEAD
 SHEET 135 OF 339