

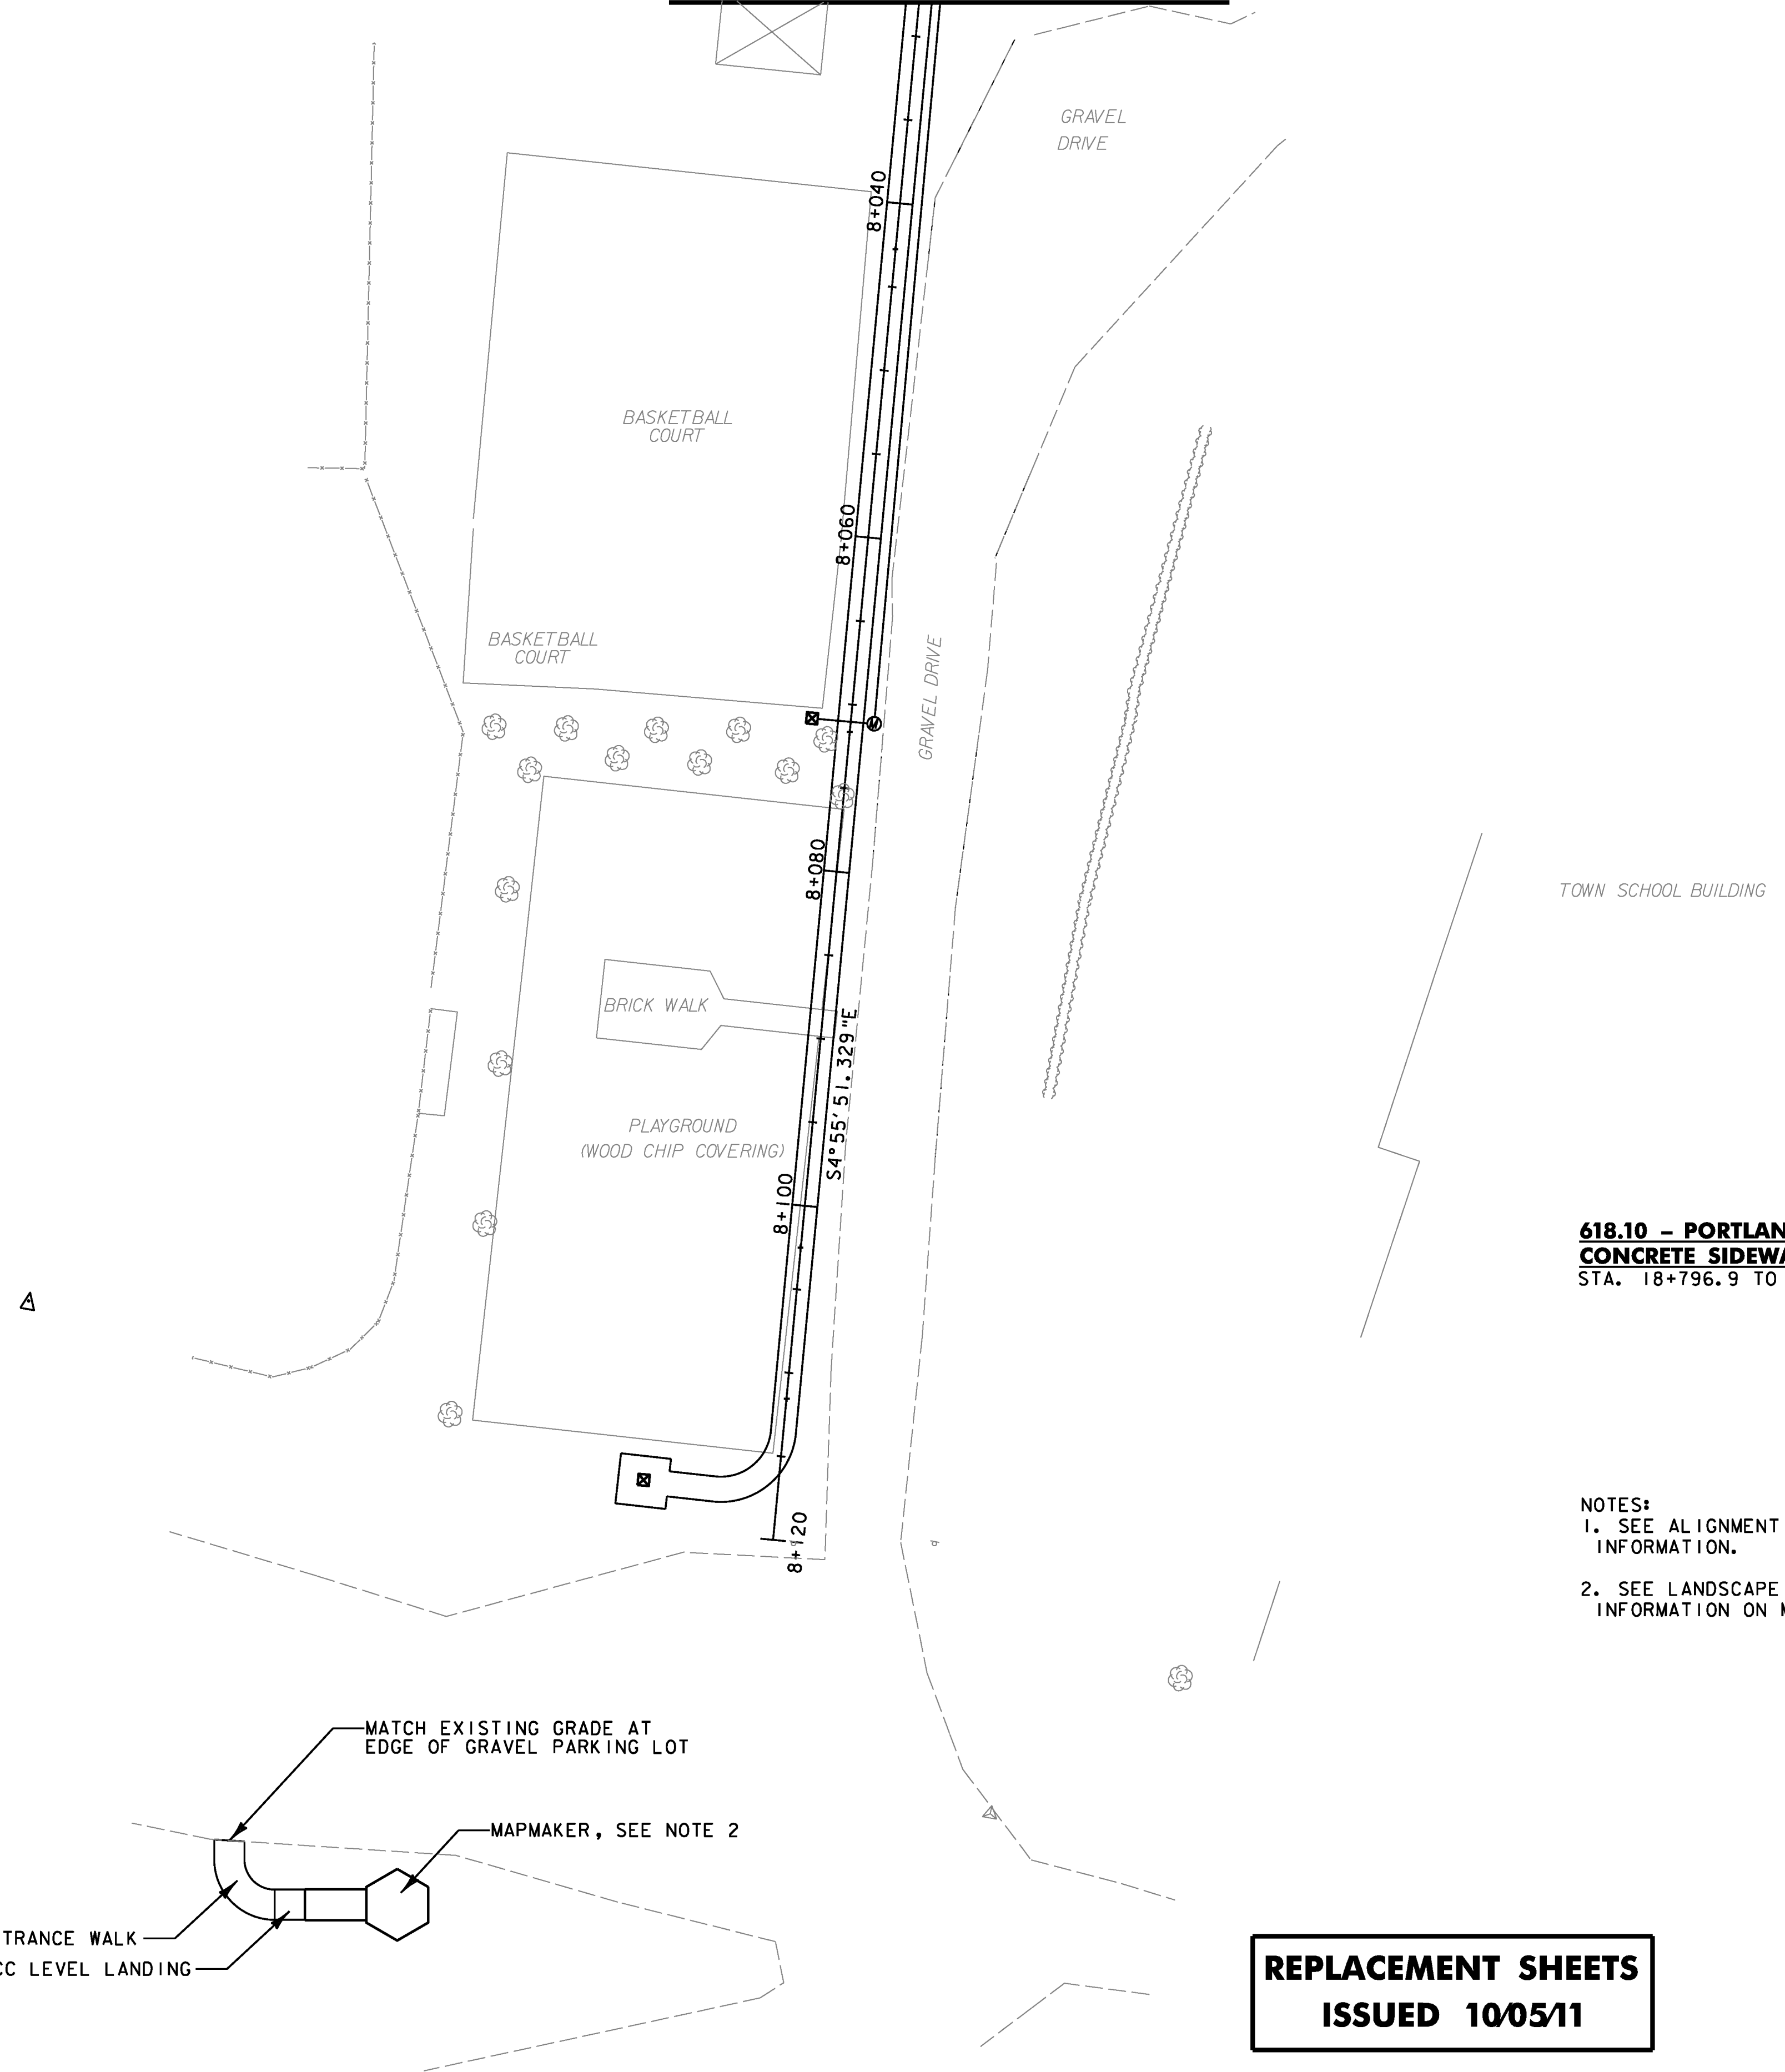


MATCH LINE - SEE SHEET CP-3

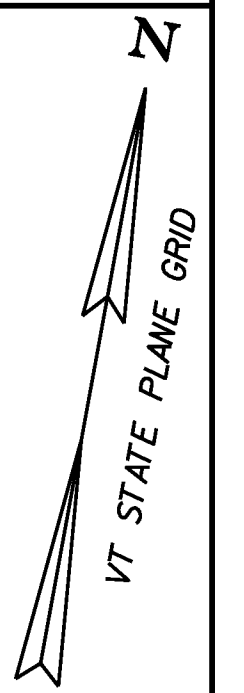


**618.10 - PORTLAND CEMENT
CONCRETE SIDEWALK, 125MM**
STA. 18+796.9 TO 8+117.2

- NOTES:
1. SEE ALIGNMENT PLANS FOR SIDEWALK LAYOUT INFORMATION.
 2. SEE LANDSCAPE AND LIGHTING PLANS FOR MORE INFORMATION ON MAPMAKER.

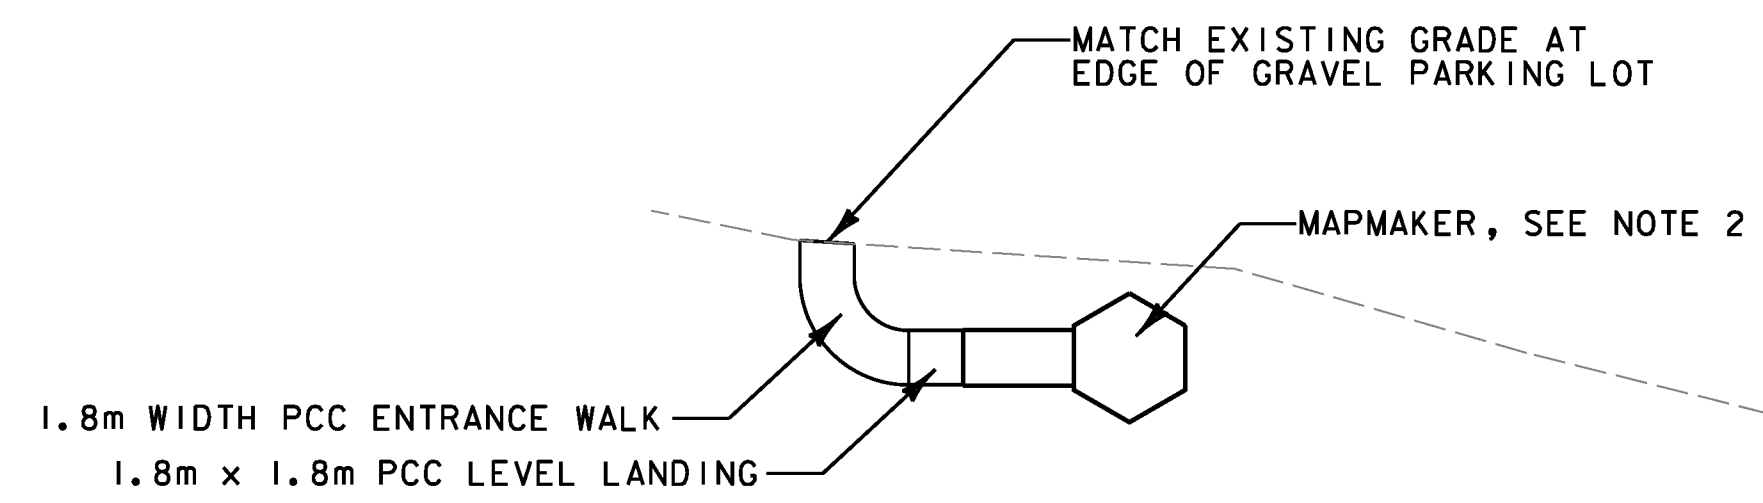

**REPLACEMENT SHEETS
ISSUED 10/05/11**

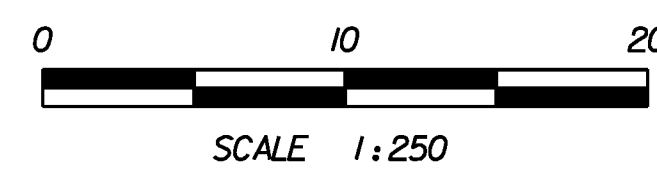

PROJECT NAME: DANVILLE	PLOT DATE: 10/4/2011
PROJECT NUMBER: F EGC 028-3(32)	DRAWN BY: STANTEC
FILE NAME: ...\\PlotFiles\027 a1111.PTF	CHECKED BY: STANTEC
DESIGN SUPERVISOR: GARY SANTY	SHEET 73 OF 306
DESIGNED BY: STANTEC	
CONSTRUCTION PLAN CP-11	