

LANDSCAPE AND LIGHTING LEGEND

	PROPOSED CONIFEROUS	} SHOWN AT APPROXIMATE 20-YEAR GROWTH SPREAD
	PROPOSED DECIDUOUS	
	EXISTING TREES	
	LIGHTING LOCATIONS (ARROW SHOWS DISTRIBUTION DIRECTION)	
	GRANITE POST LOCATIONS	
	HANDHOLE	
	ROUTE 2 LIGHTING METER PEDESTAL SEE DETAIL ON LIGHTING DETAILS SHEET LTD-6	
	DANVILLE GREEN METER PEDESTAL SEE DETAIL ON LIGHTING DETAILS SHEET LTD-6	
	LANDSCAPING DETAIL SHEET	
	LANDSCAPE BACKFILL	
	WIRED CONDUIT (PVC) (50mm)	
	ELECTRICAL CONDUIT SLEEVE (200mm) (PVC)	

679.45 - LIGHT POLE


POLE NO.	LOCATION	FIXTURE TYPE	WATTS	TYPE	MOUNTING HEIGHT
SL-32	18+931.00, 6.86M RT	B	175	III	5.48M
SL-34	18+965.00, 6.63M RT	B	175	III	5.48M
SL-36	18+990.00, 6.63M RT	B	175	III	5.48M
SL-38	19+011.50, 6.63M RT	B	175	III	5.48M
SL-40	19+035.50, 6.63M RT	B	175	III	5.48M
SL-42	19+057.50, 6.63M RT	B	175	III	5.48M

678.26 - JUNCTION BOX

HAND HOLE NO.	LOCATION
HH-10	19+020.6, 6.93M RT

656.30 - DECIDUOUS TREES

STA.	NO.	LOCATION	DESCRIPTION
18+937.2	1	RT	COMMON HACKBERRY
18+937.2 - 18+946.9	2	LT	COMMON HACKBERRY
18+971.0	1	RT	LITTLE KING RIVER BIRCH
18+975.1 - 18+985.4	2	LT	RED OAK
19+007.9 - 19+043.0	3	LT	AMERICAN HOPHORNBEAM - AUTUMN BLAZE MAPLES
19+013.0 - 19+025.0	2	RT	19+000 JAPANESE TREE LILAC
19+067.8	1	LT	GREEN MOUNTAIN SUGAR MAPLE

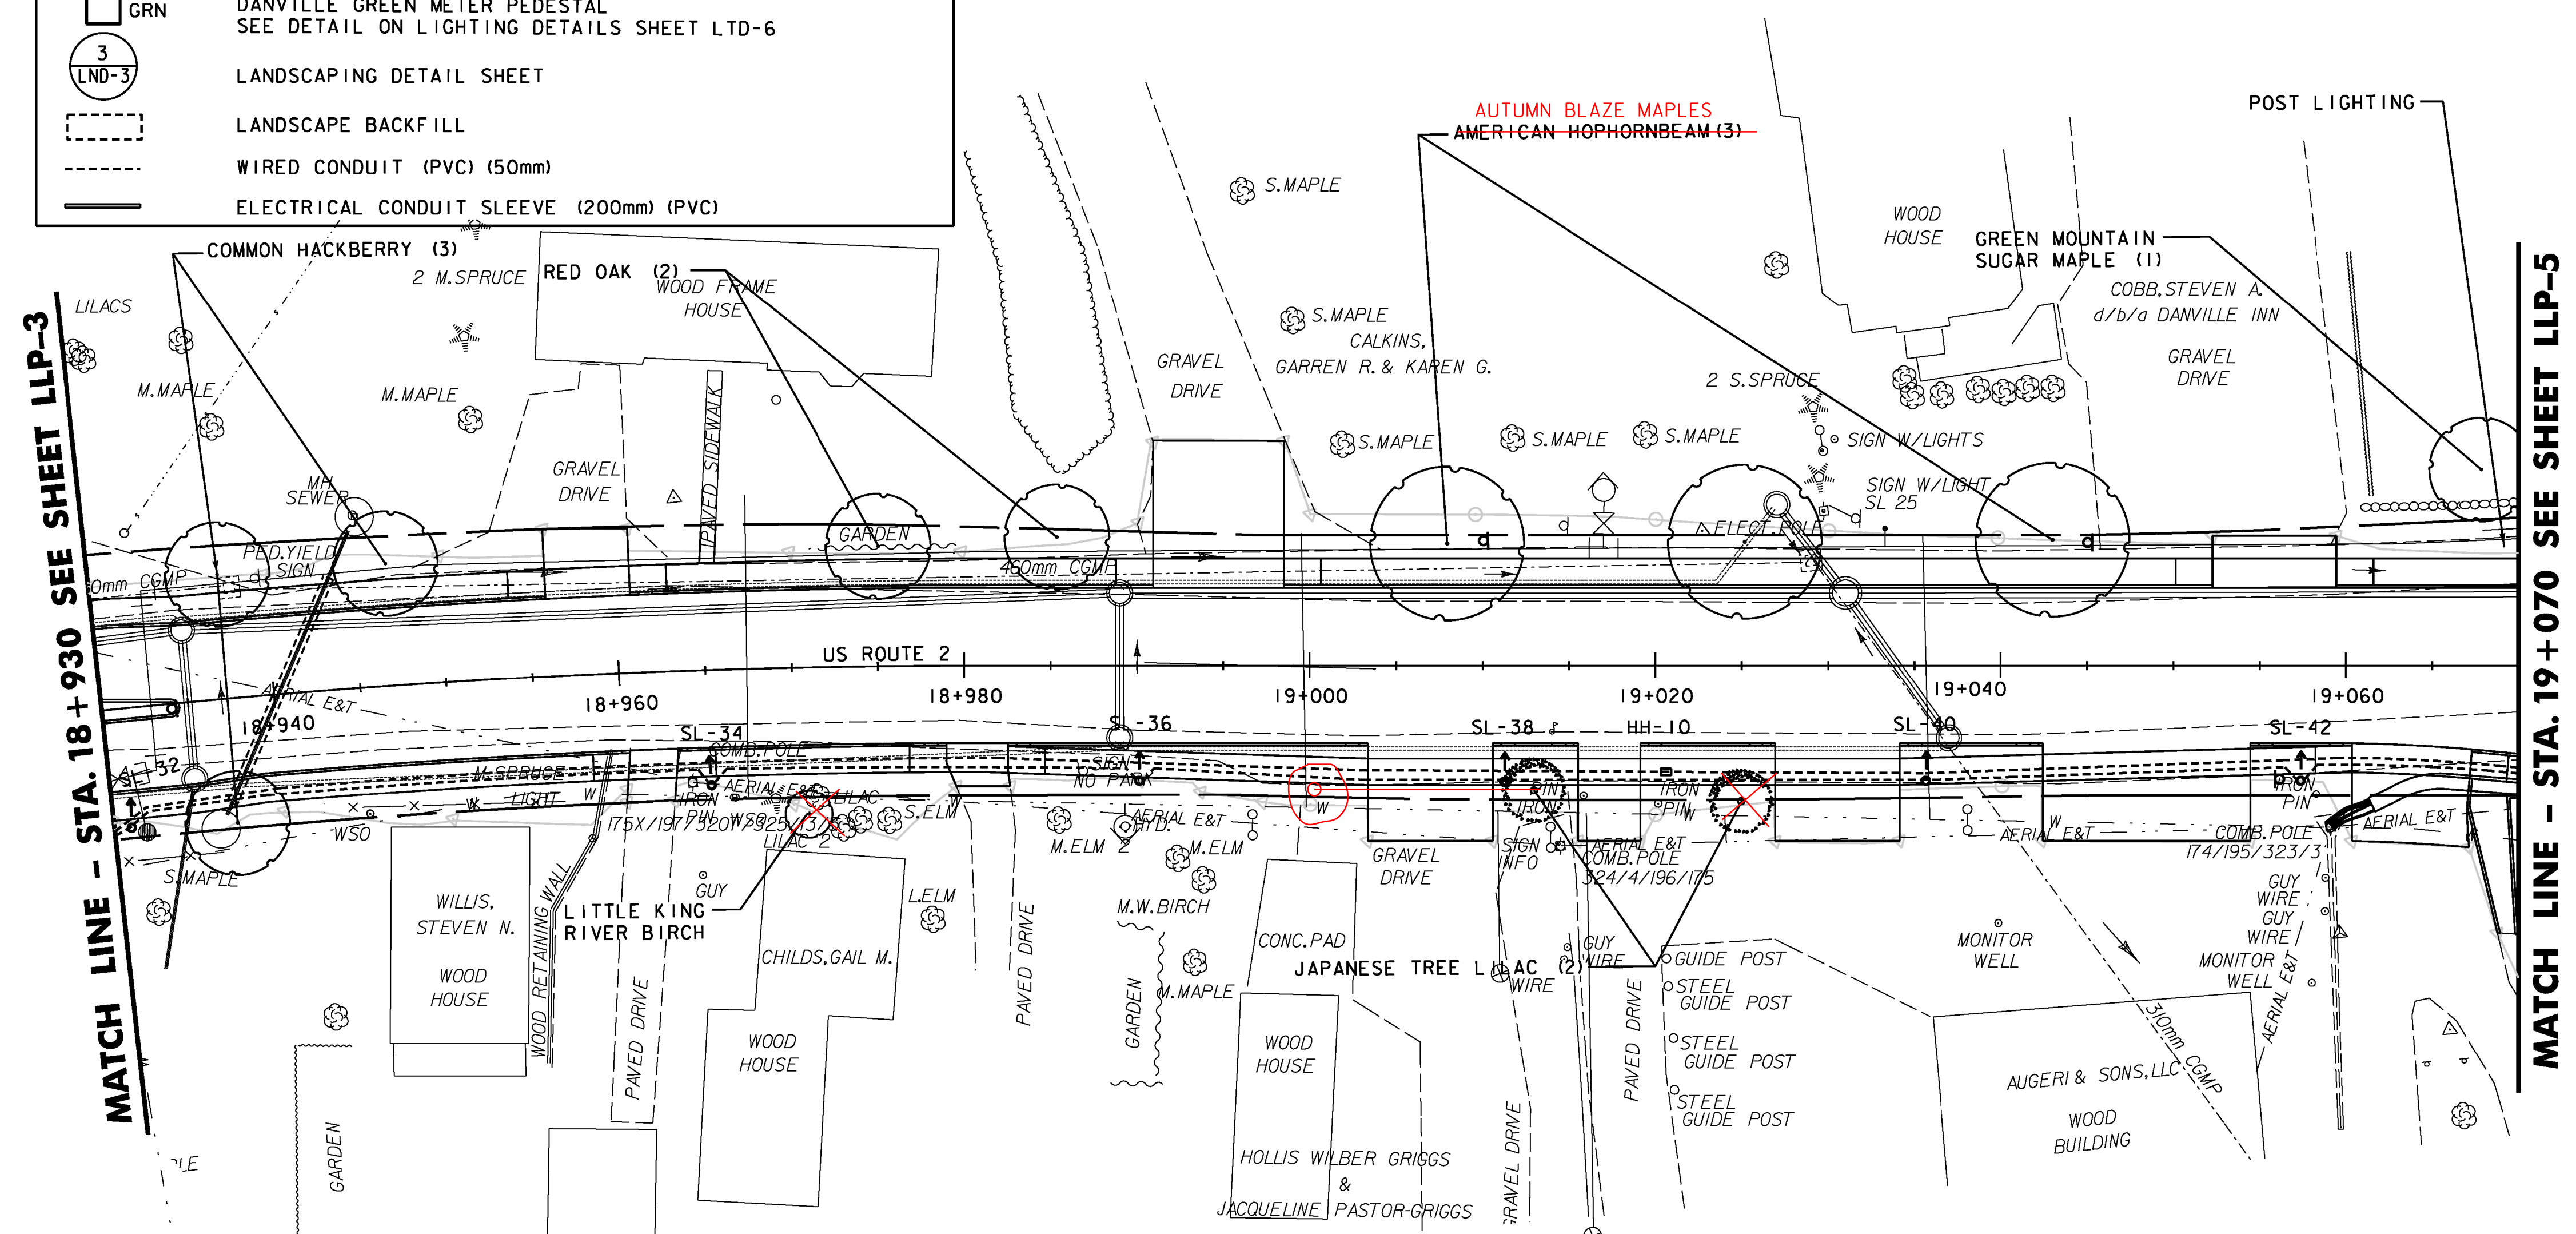


MATCH LINE - STA. 18+930 SEE SHEET LLP-3

MATCH LINE - STA. 19+070 SEE SHEET LLP-5

- NOTES:**
- ALL TREES ARE TO BE STAKED AND PLANTED SO TRUNK IS A MINIMUM OF 1M FROM EDGE OF ALL SIDEWALKS AND FROM SUBASE FOR FUTURE SIDEWALK (EAST OF STA 2+220 ON RTE 2) - SEE CROSS SECTIONS.
 - FINAL PLANTING LOCATION ARE TO BE APPROVED BY VTRANS PRIOR TO PLACEMENT OF LANDSCAPE BACKFILL AND INSTALLATION OF ALL TREES AND SHRUBS.

**REPLACEMENT SHEETS
ISSUED 02/24/2012**

DATUM	
VERTICAL	NAVD88
HORIZONTAL	NAD83(92)

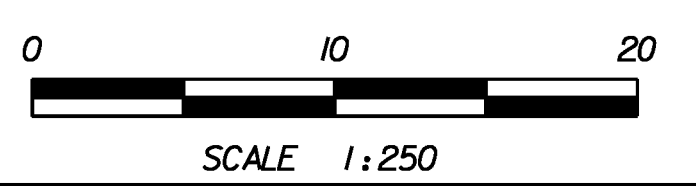

PROJECT NAME:	DANVILLE
PROJECT NUMBER:	F EGC 028-3(32)
FILE NAME:	...\\PlotFiles\080 1104.prf
DESIGN SUPERVISOR:	GARY SANTY
DESIGNED BY:	STANTEC
LANDSCAPE & LIGHTING PLAN LLP-4	
PLOT DATE:	2/24/2012
DRAWN BY:	STANTEC
CHECKED BY:	STANTEC
SHEET	180 OF 306

STA 18+930 TO 19+070

2/24/2012 11:45:55 PM V:\1953\active\19530033_1092\Revised Plans\PlotFiles\080 1104.prf